



Project: COUNTY OFFICE COMPLEX
(Approx. 2,664 SF)
For: MINISTRY OF MINES AND ENERGY
Location: ZWEDRU CITY, GRAND GEDEH, LIBERIA
Date: AUGUST 15, 2026

TABLE OF CONTENT:

- 1. Foundation Plan
 - 1.1 Foundation Details
 - 1.2 Foundation Tie Beam
- 2. Floor Plan
- 3. Elevations
- 4. Roof Plan
- 5. Ceiling Plan
- 6. Lighting Plan
- 7. Sewer Plumbing Plan



Autodesk Revit

OWNER:

**MINISTRY OF
MINES AND
ENERGY**

PROJECT:

**COUNTY
OFFICE
COMPLEX**

Cover sheet

IFB #:
MME/SBA/NCB/006/26


Date: July 2025


Drawn By: MME ENGR



Table of Contents

A102 - Floor Plan	2
1.1 A102 - Floor Plan	
A104 - Roof Plan	3
1.1 A104 - Roof Plan	
A105 - Ceiling Plan	4
1.1 A105 - Ceiling Plan	
A106 - Door & Window Schedule	5
1.1 A106 - Door & Window Schedule	
A107 - Elevations	6
1.1 A107 - Elevations	
A108 - Elevations 1	7
1.1 A108 - Elevations 1	
E101 - Lighting Plan	8
1.1 E101 - Lighting Plan	
E102 - Receptacle & Switches Plan	9
1.1 E102 - Receptacle & Switches Plan	
E103 - Electrical Details	10
1.1 E103 - Electrical Details	
P101 - Sewer Plumbing Plan	11
1.1 P101 - Sewer Plumbing Plan	
P102 - Sewage Plumbing Plan	12
1.1 P102 - Sewage Plumbing Plan	
P103 - Plumbing Details	13
1.1 P103 - Plumbing Details	
S101 - Foundation Plan	14
1.1 S101 - Foundation Plan	
S102 - Foundation Tie Beam	15
1.1 S102 - Foundation Tie Beam	
S103 - Foundation Details	16
1.1 S103 - Foundation Details	
S104 - Roof Framing Plan	17
1.1 S104 - Roof Framing Plan	
S105 - Roof Details	18
1.1 S105 - Roof Details	
S106 - Sections Details	19
1.1 S106 - Sections Details	

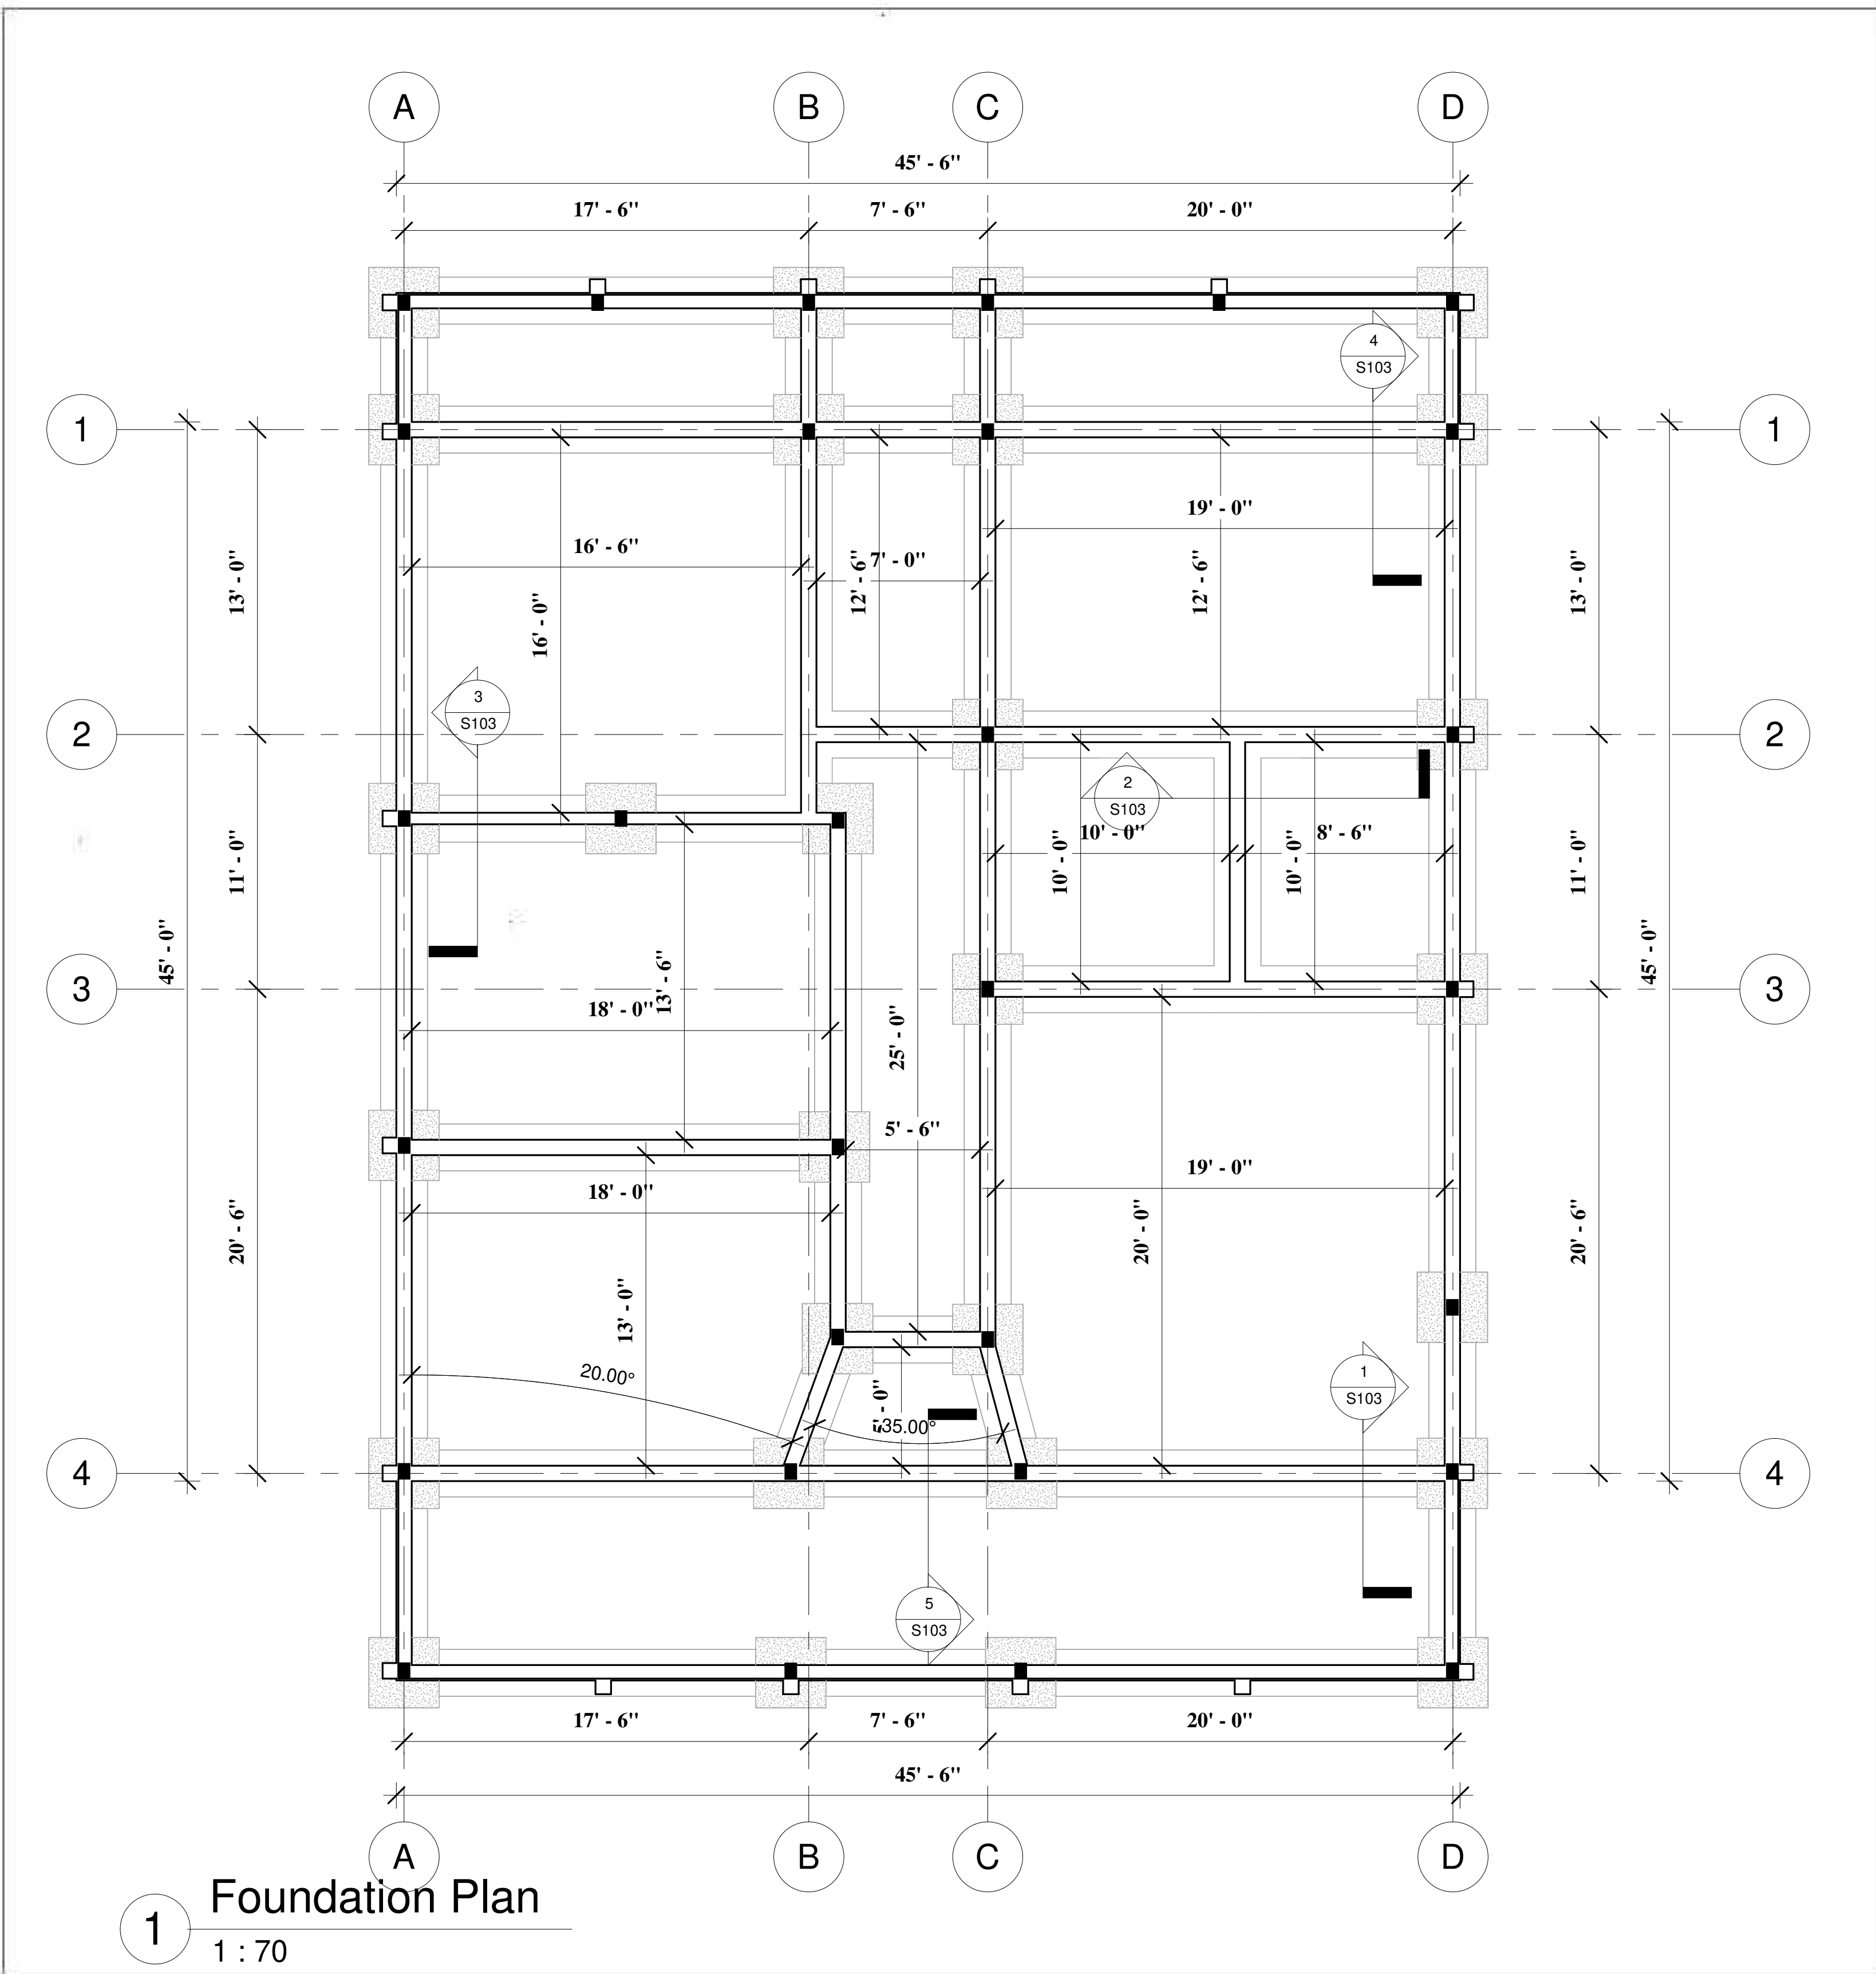

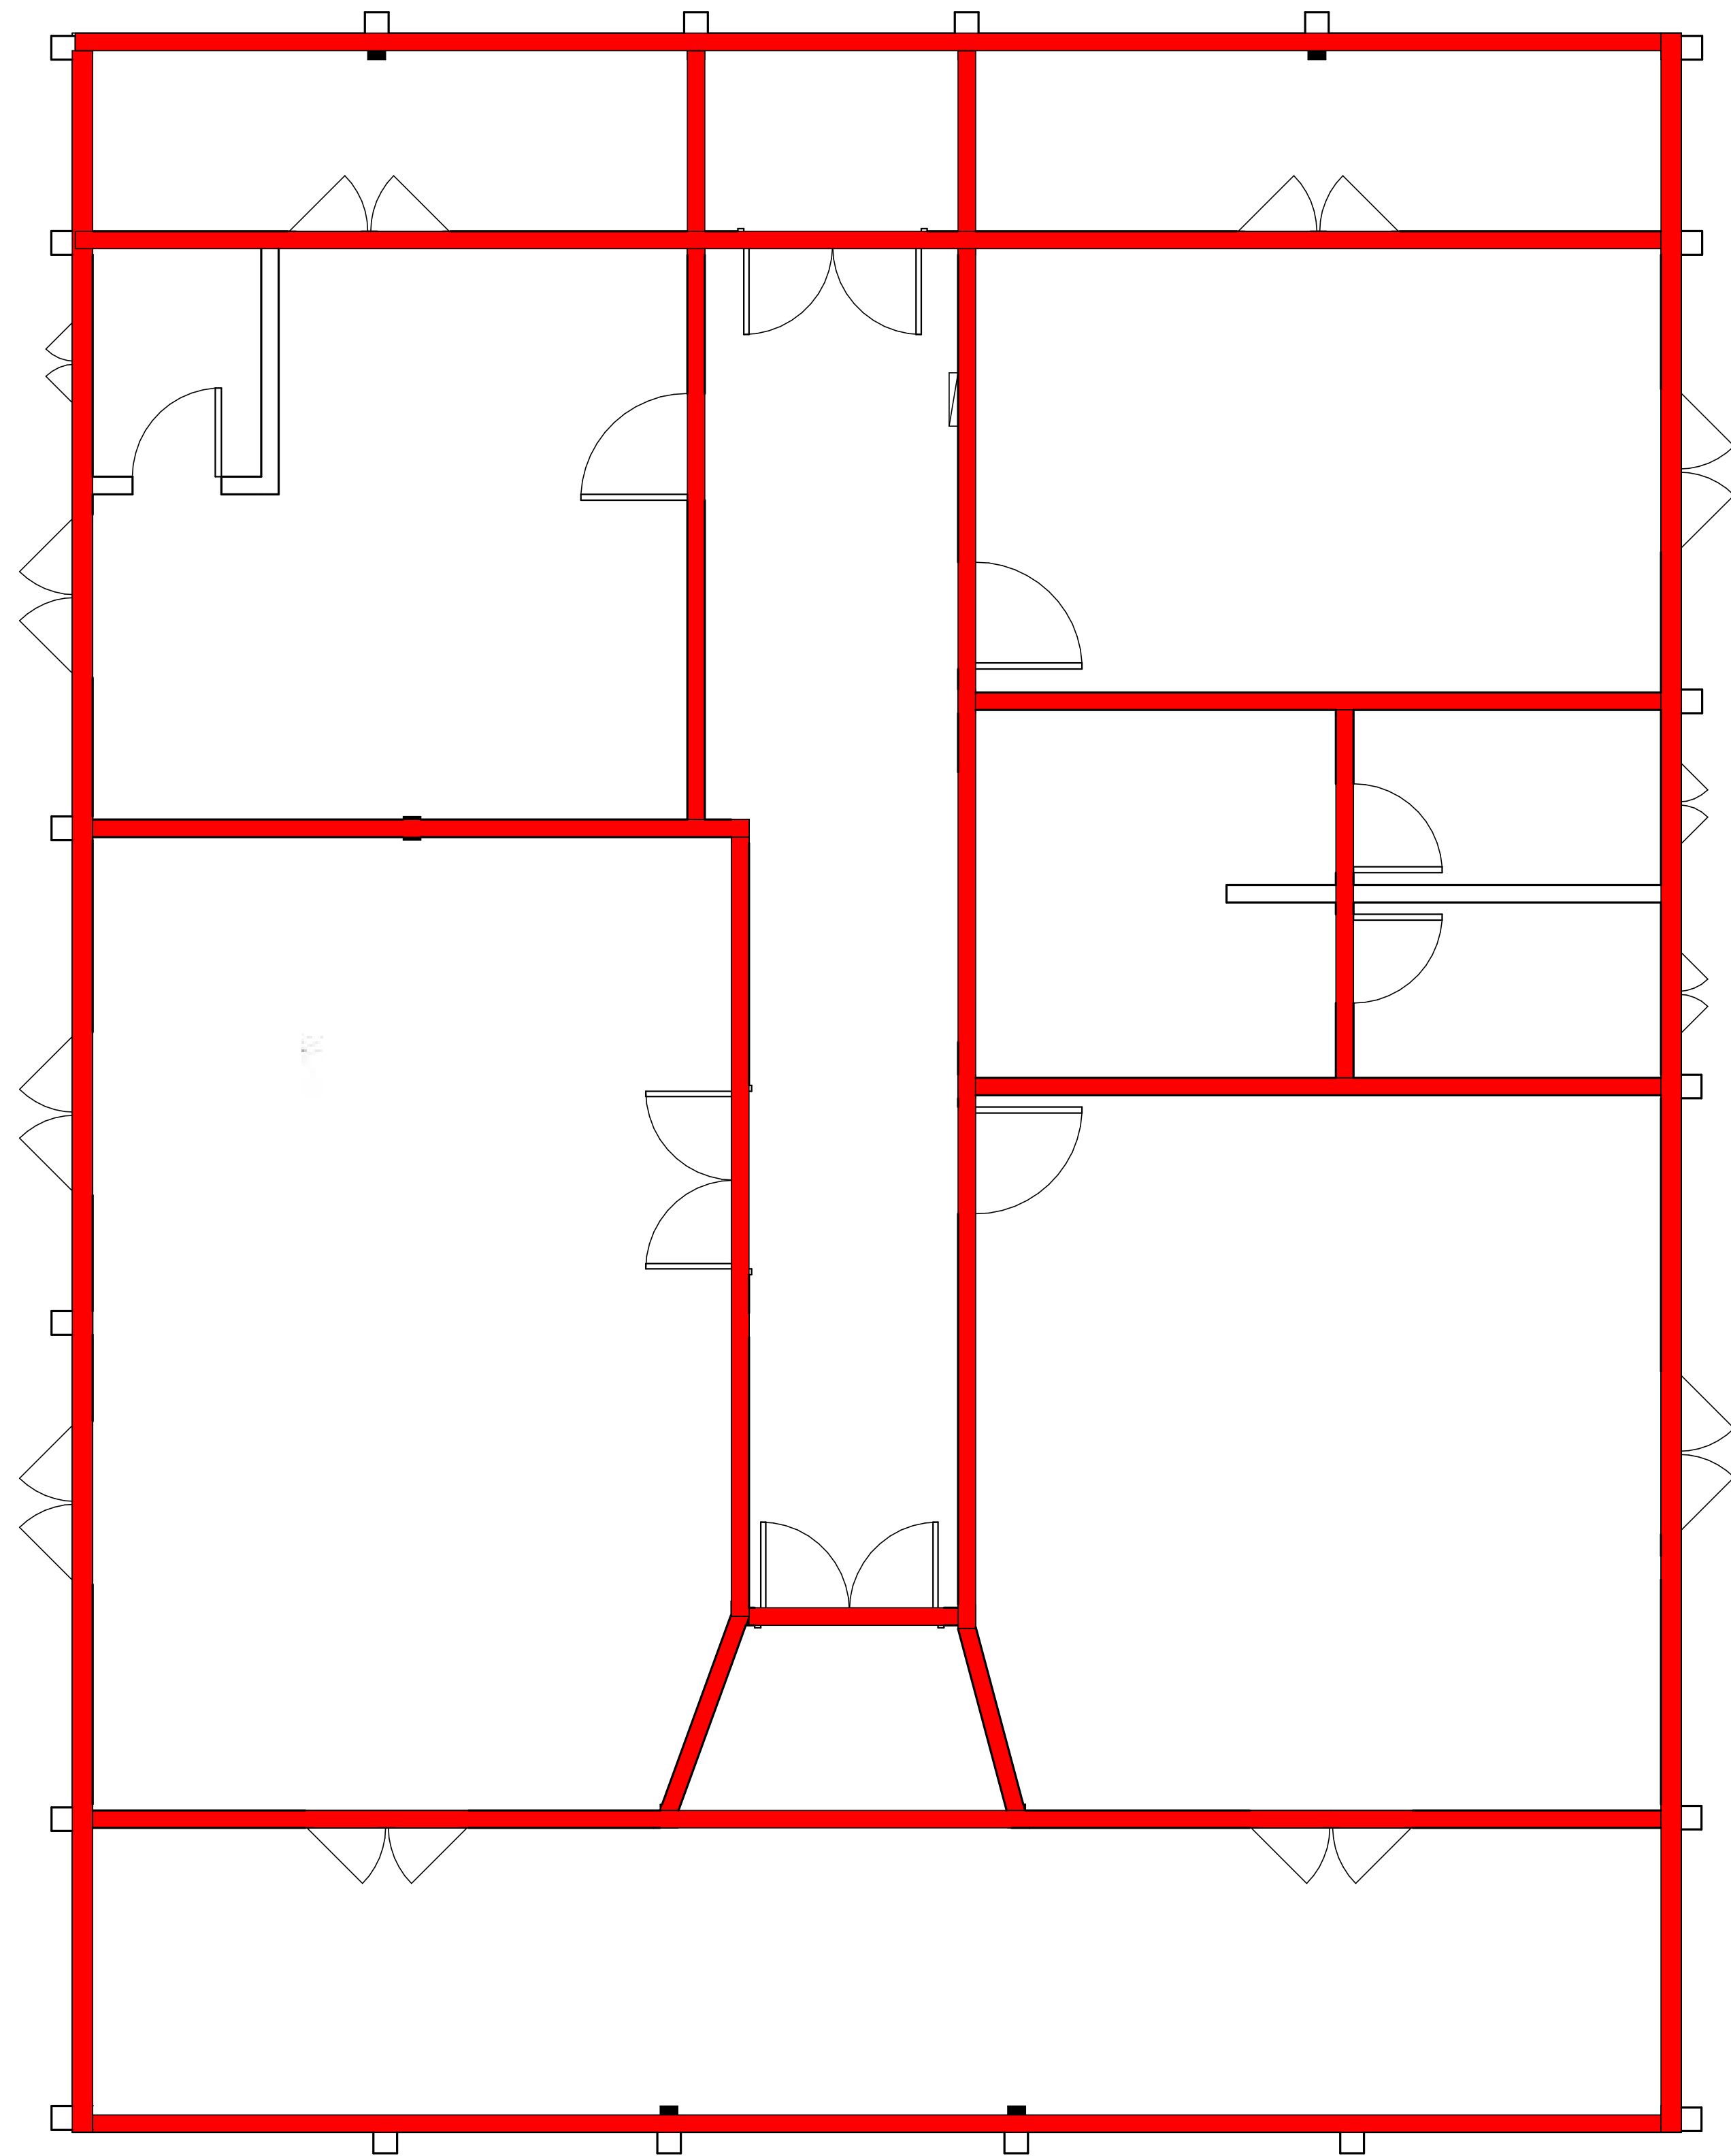

1 Tie Beam
1 : 55


IFC DRAWING

Owner:
Ministry of Mines
and Energy

Project:
County Office

TIE BEAM

Project Number	002
Date	JULY 2026
Drawn By	MME Engineers
Checked By	
S102	
Scale	

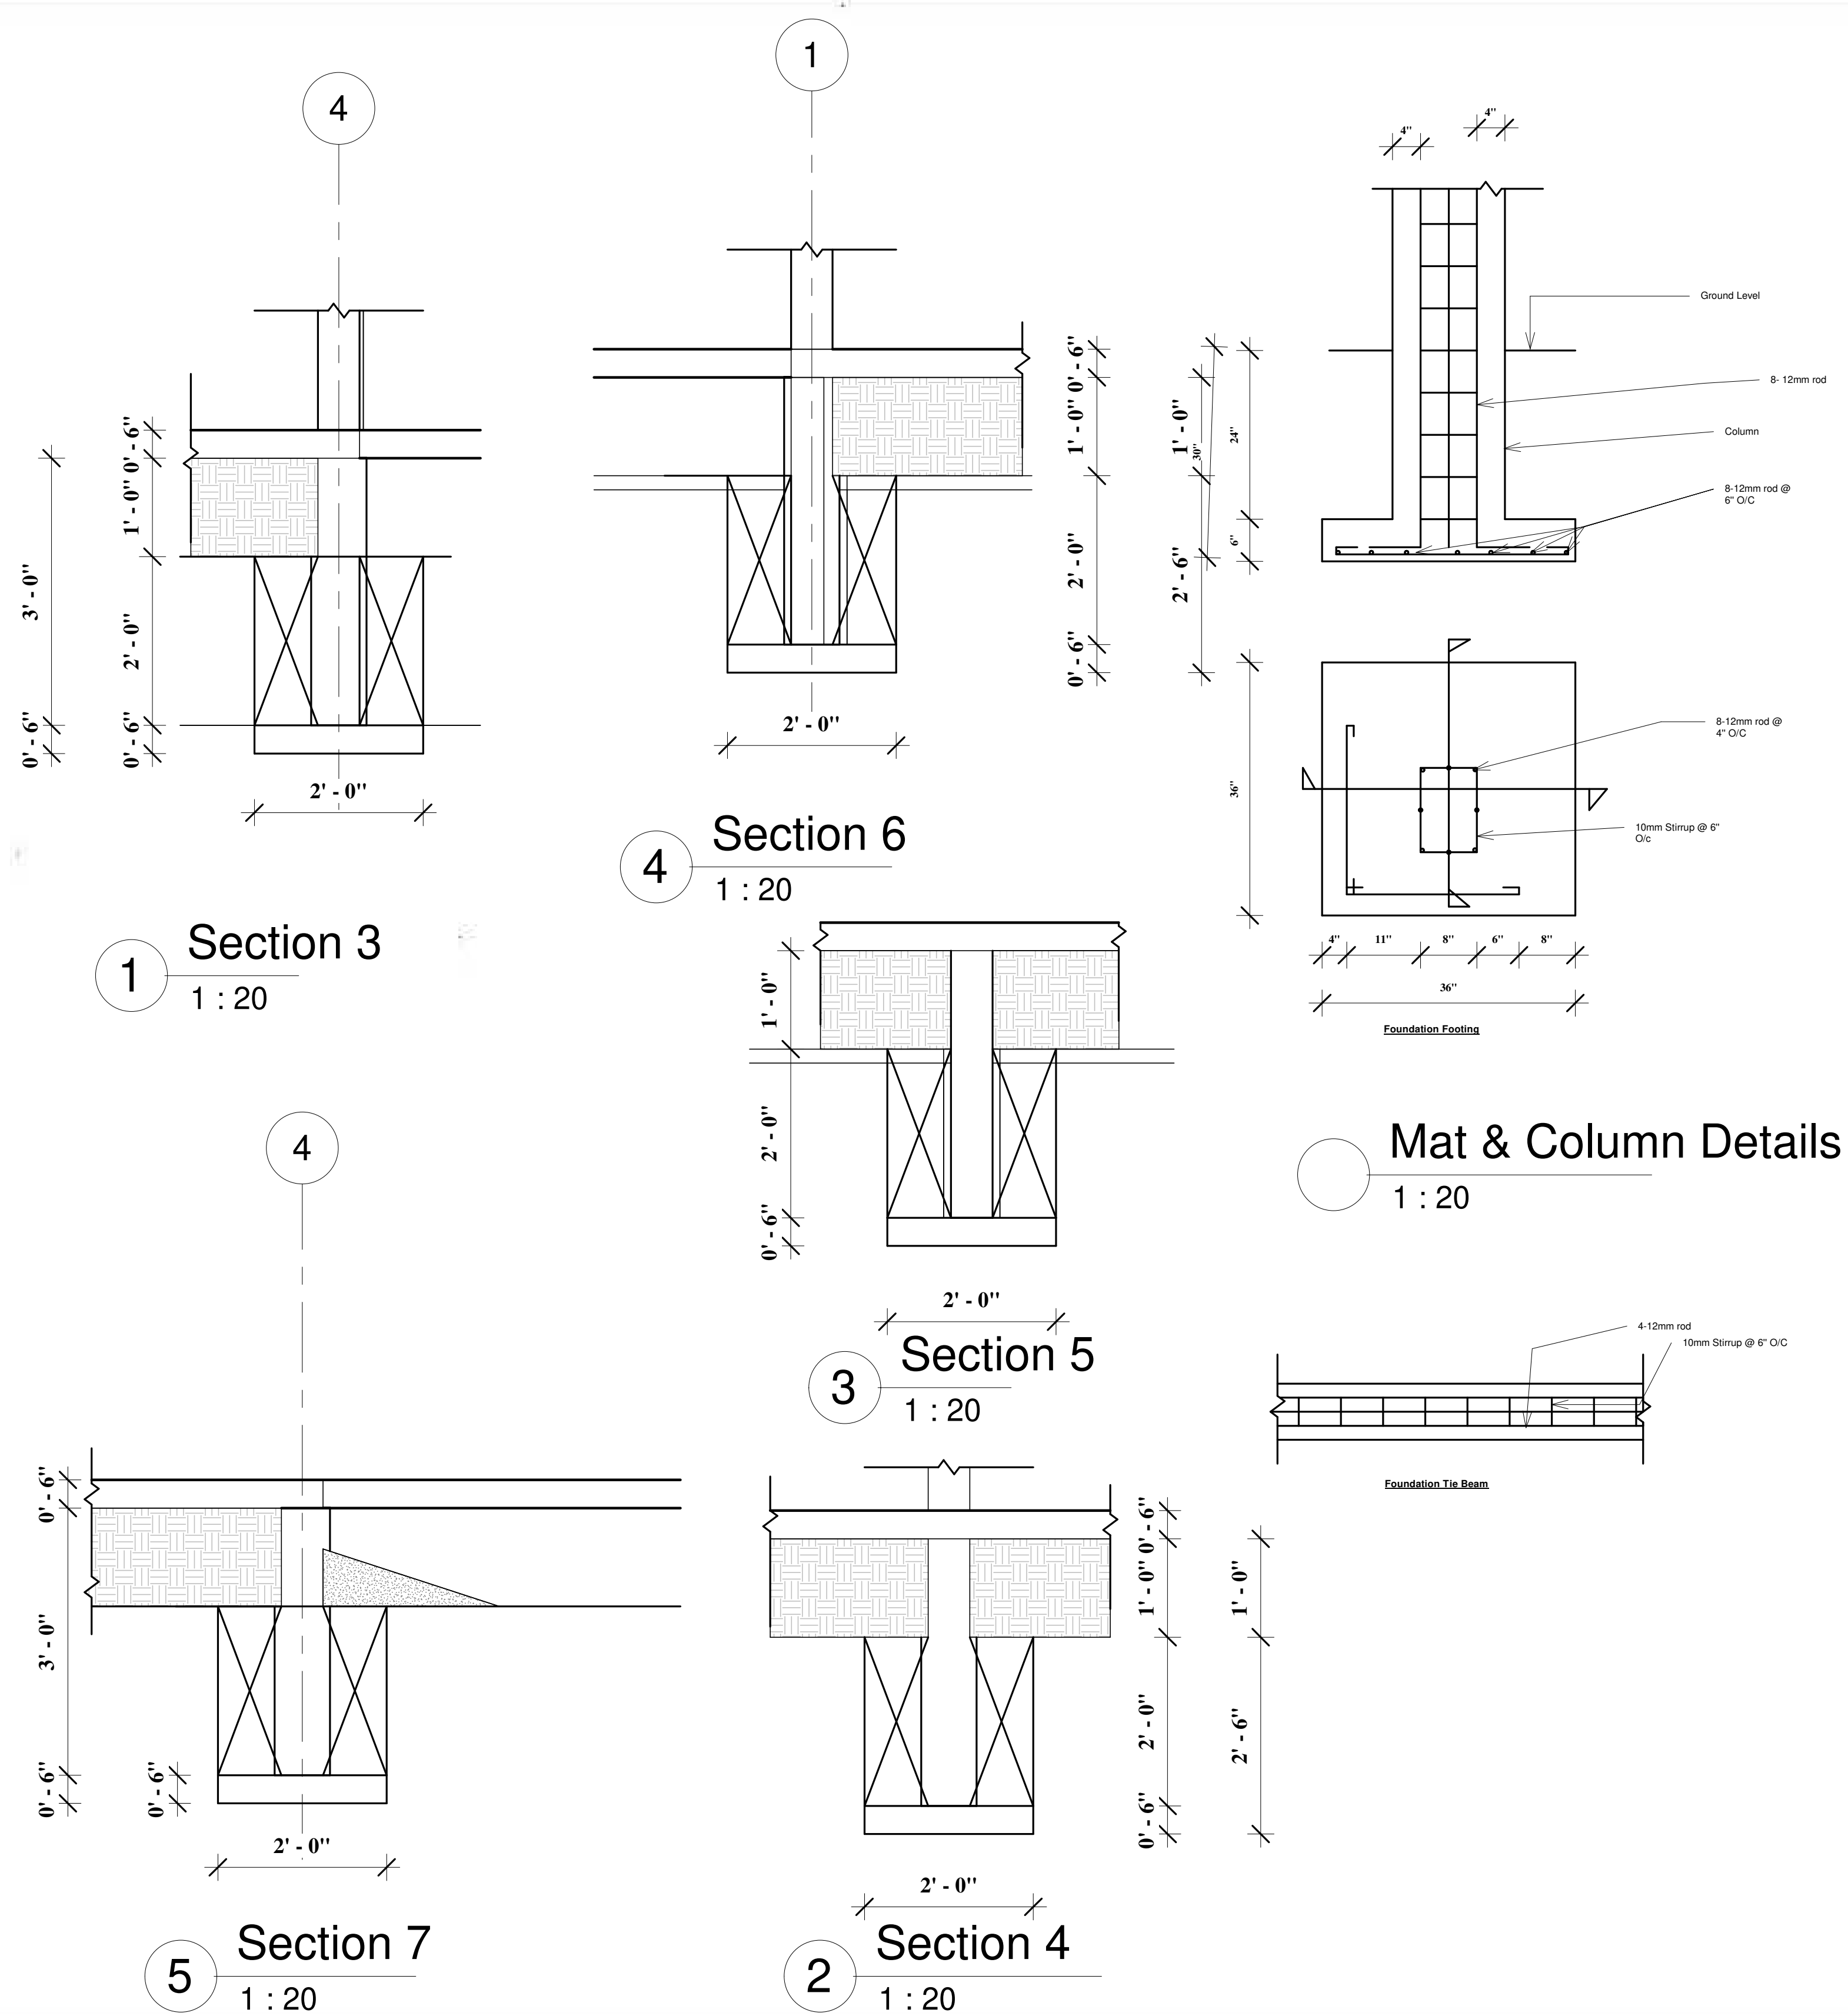


IFC DRAWING

Owner:
Ministry of Mines
and Energy

Project:
County Office


FOUNDATION DETAILS

Project Number	002
Date	JULY 2026
Drawn By	MME Engineers
Checked By	
	S103
Scale	

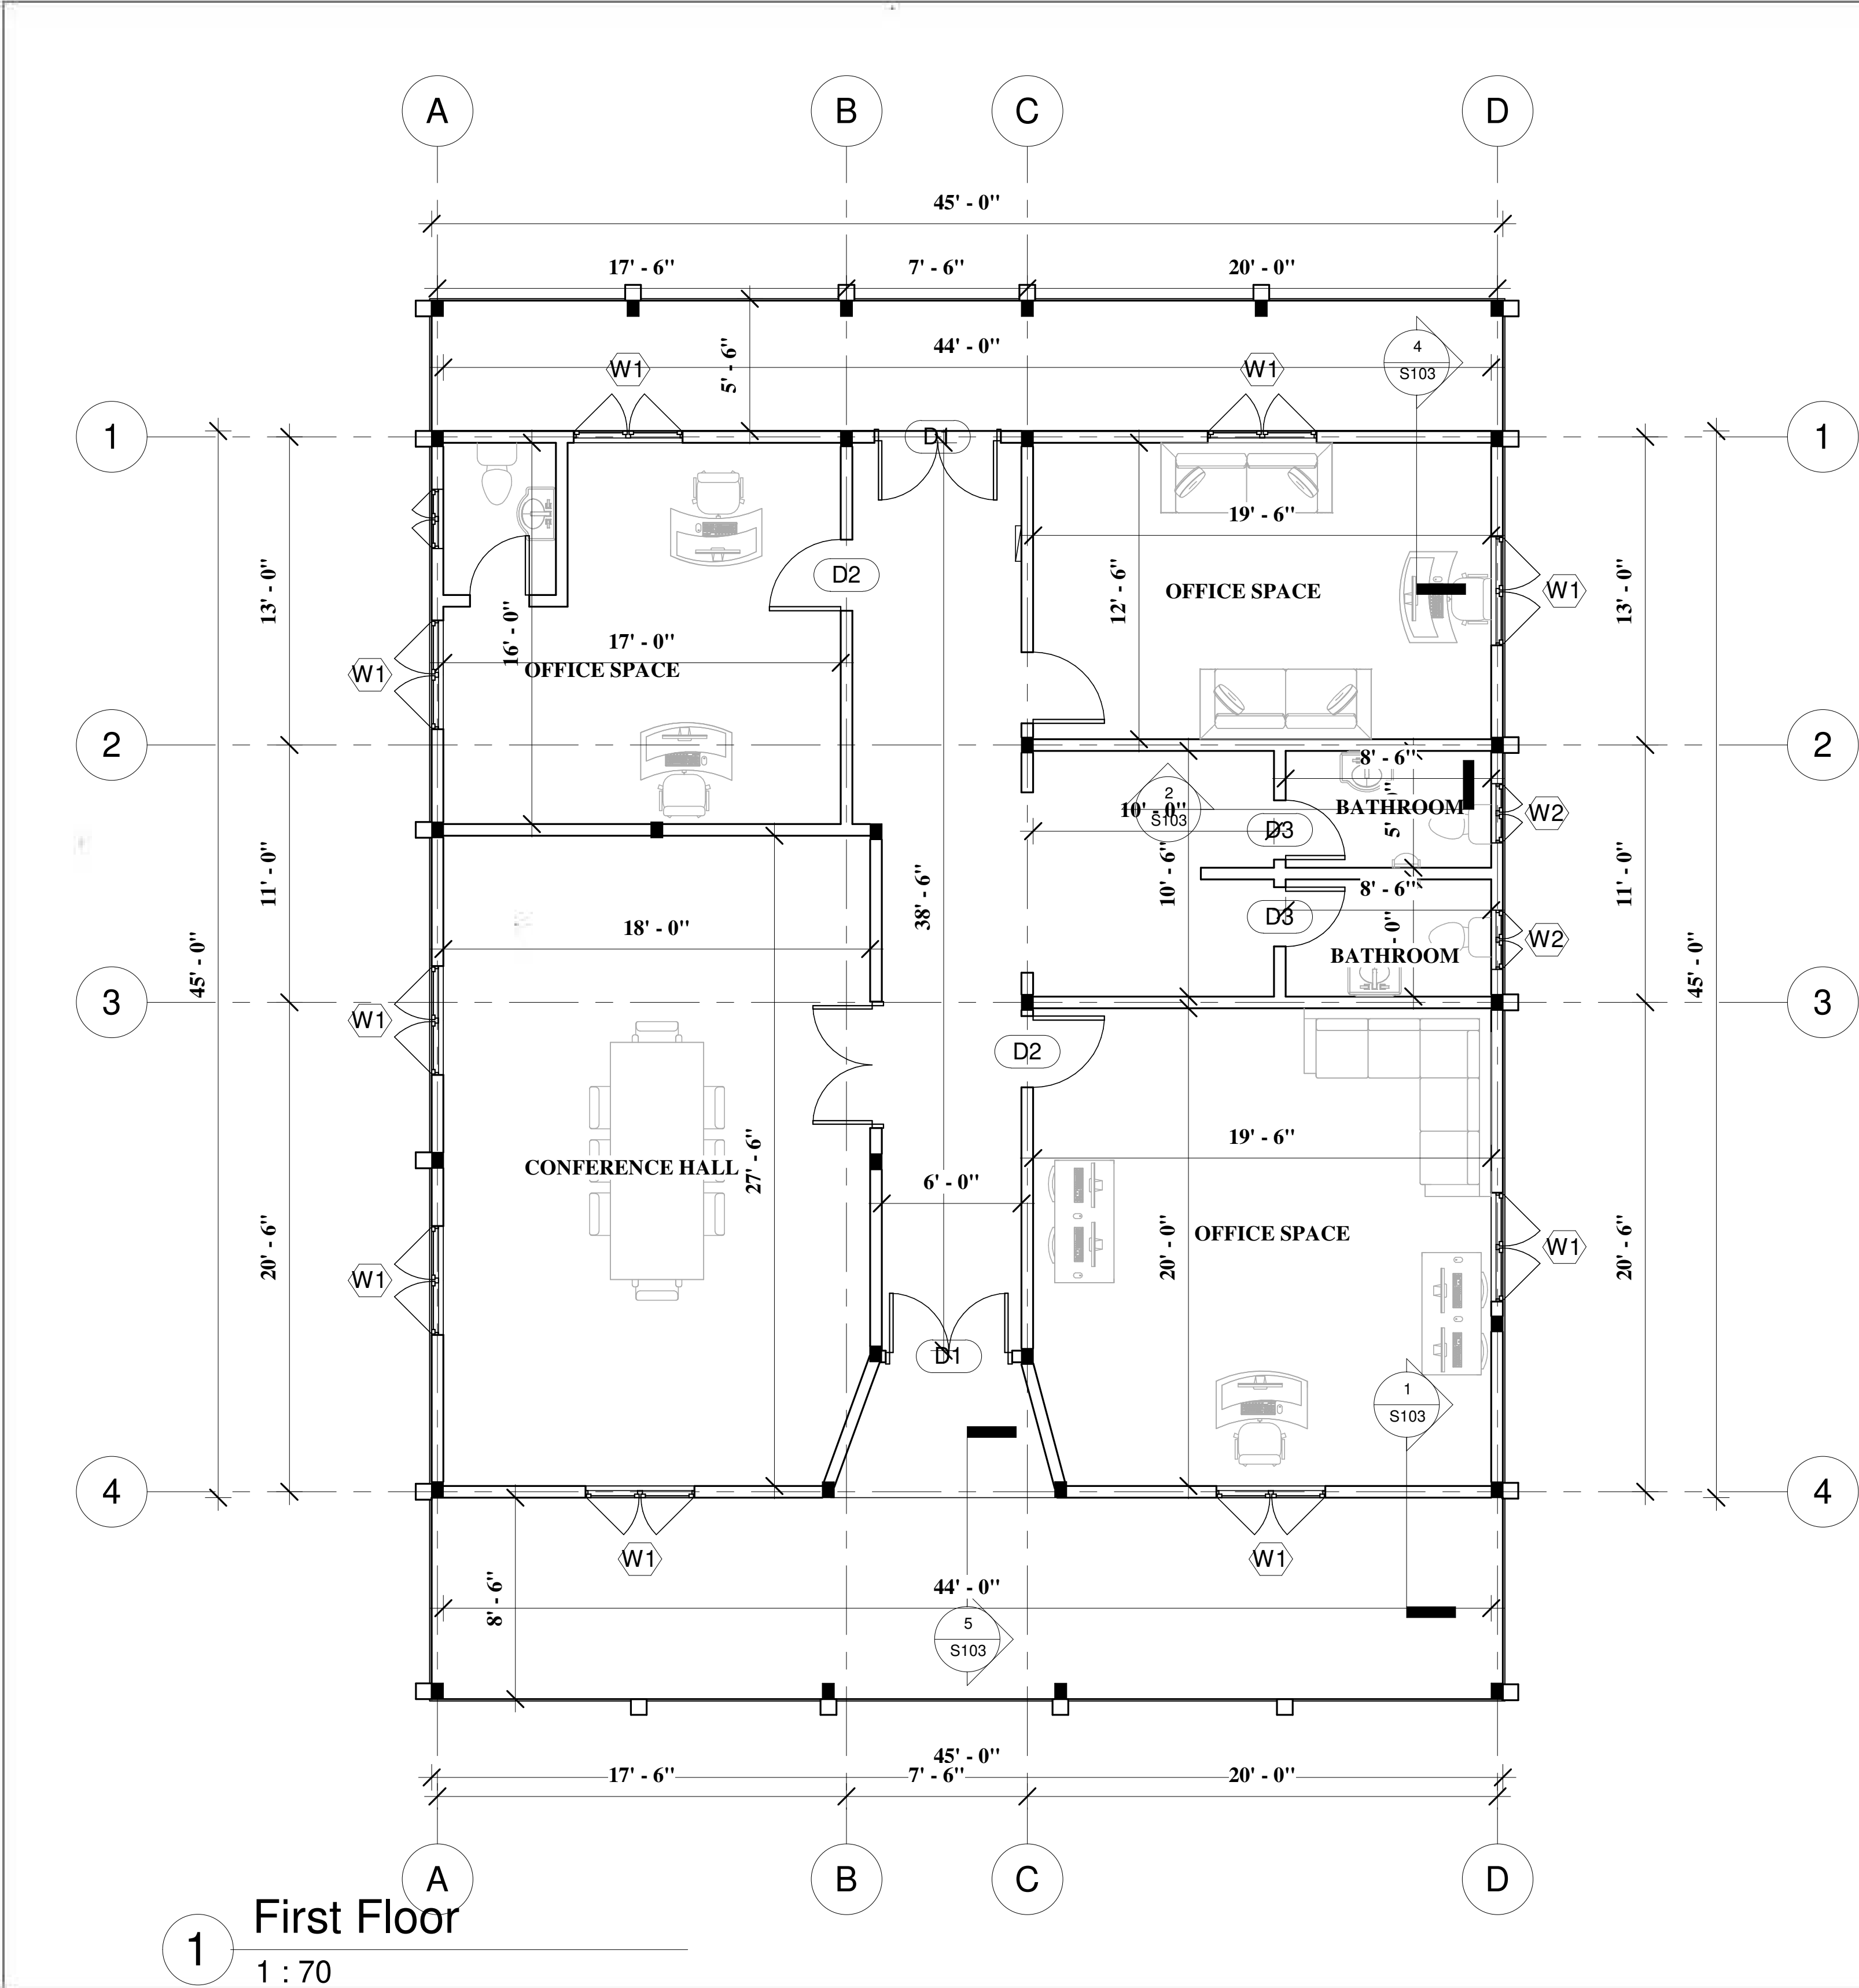

IFC DRAWING	
Owner: Ministry of Mines and Energy	
Project: County Office	
FLOOR PLAN	
Project Number	002
Date	JULY 2026
Drawn By	MME Engineers
Checked By	
A102	
Scale	

1 : 62
1
Roof Plan

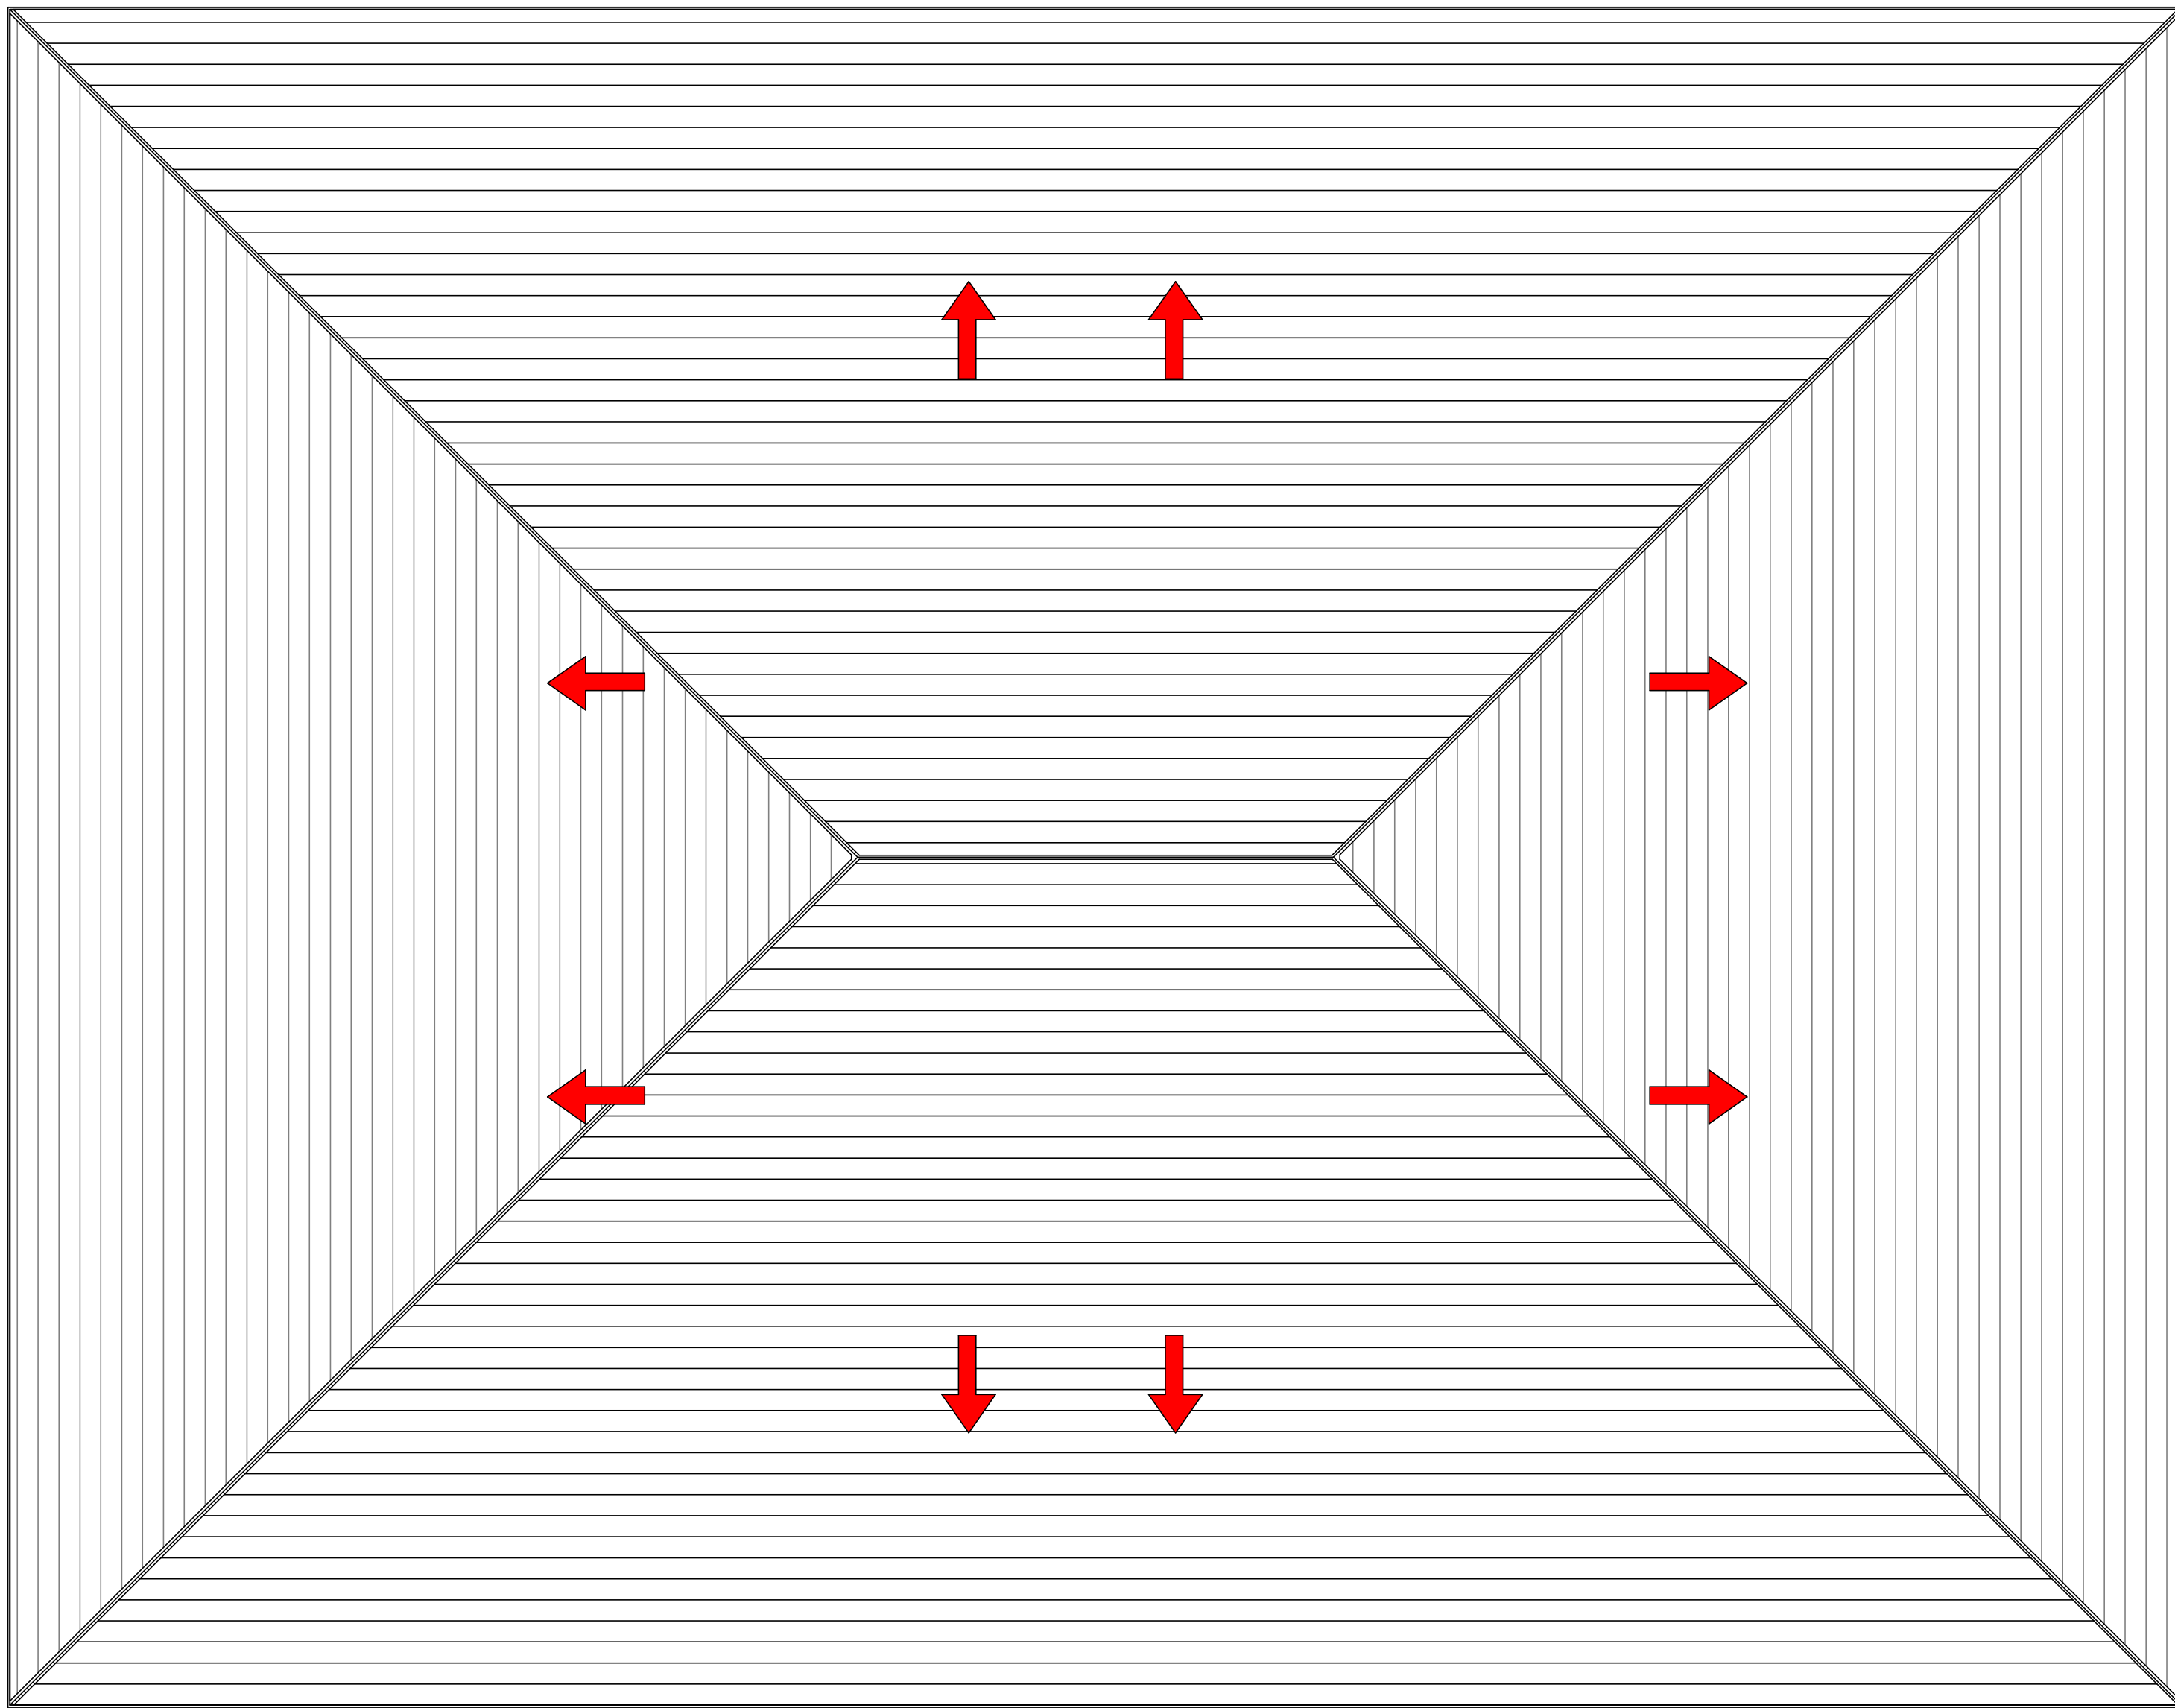

IFC DRAWING

Owner:
Ministry of Mines
and Energy

Project:
County Office

ROOF PLAN

Project Number: 002


Date: JULY 2026

Drawn By: MME Engineers

Checked By:

A104

Scale:

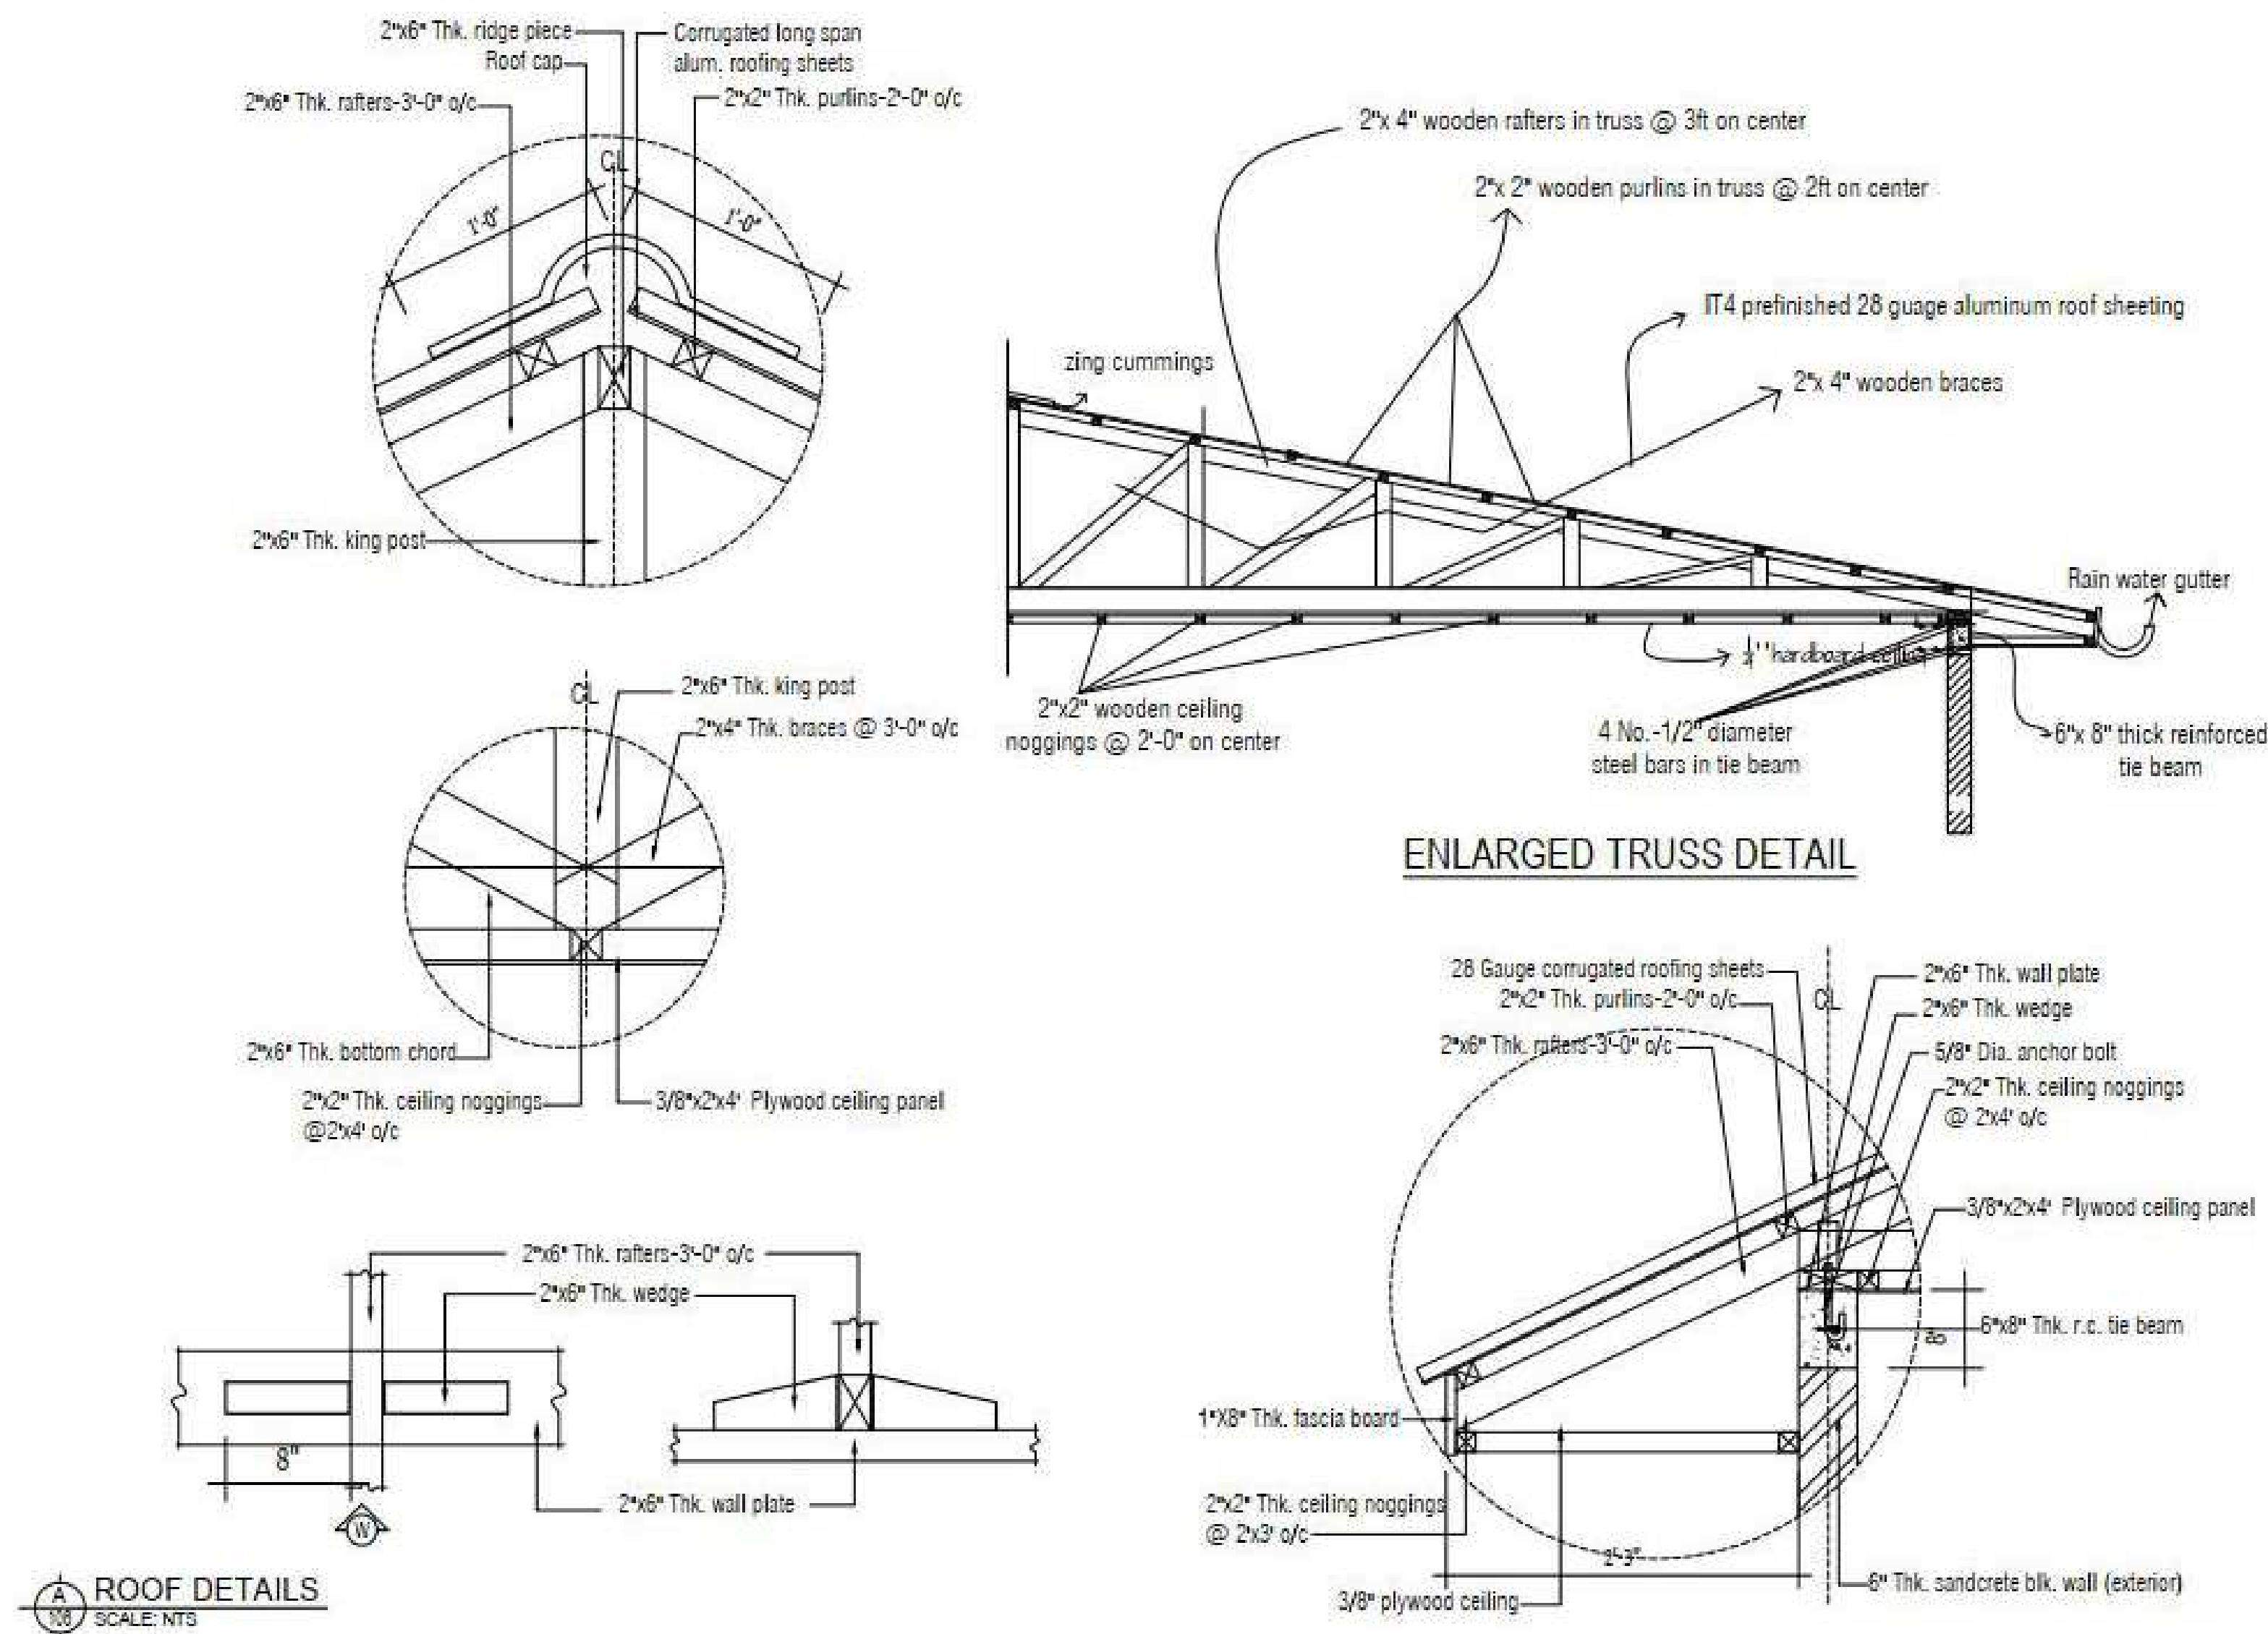


IFC DRAWING

Owner:
Ministry of Mines
and Energy


Project:
County Office

ROOF DETAILS

Project Number	002
Date	JULY 2026
Drawn By	MME Engineers
Checked By	
S105	
Scale	

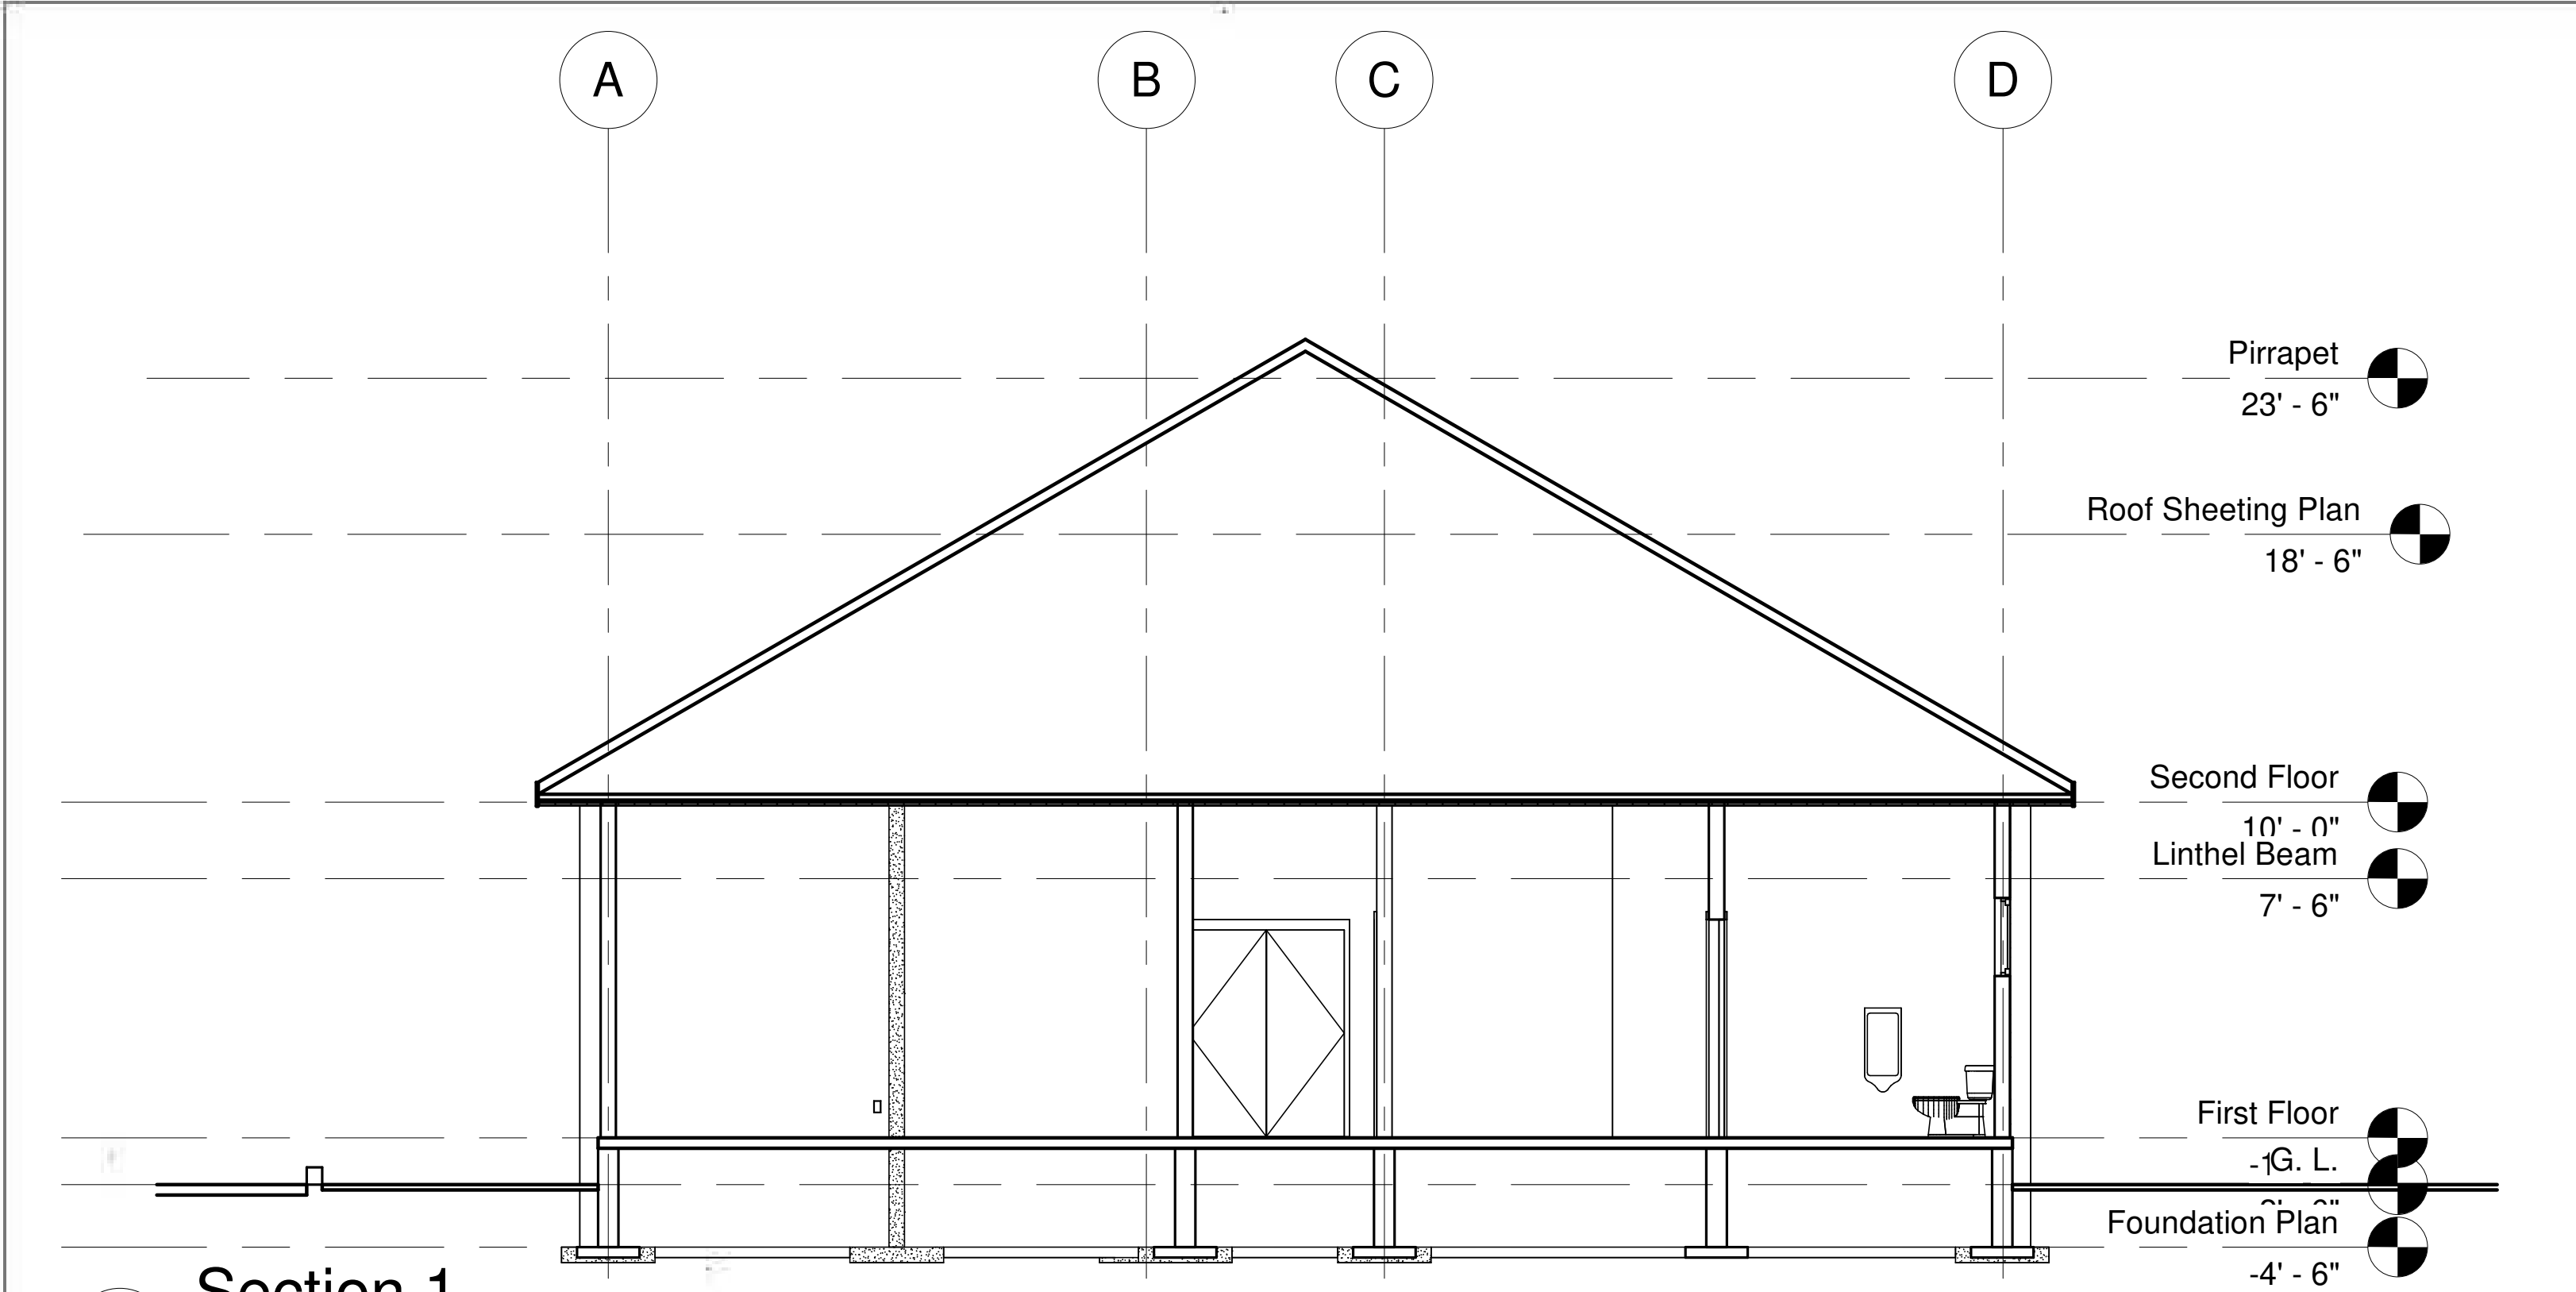

1 Section 1
1 : 73

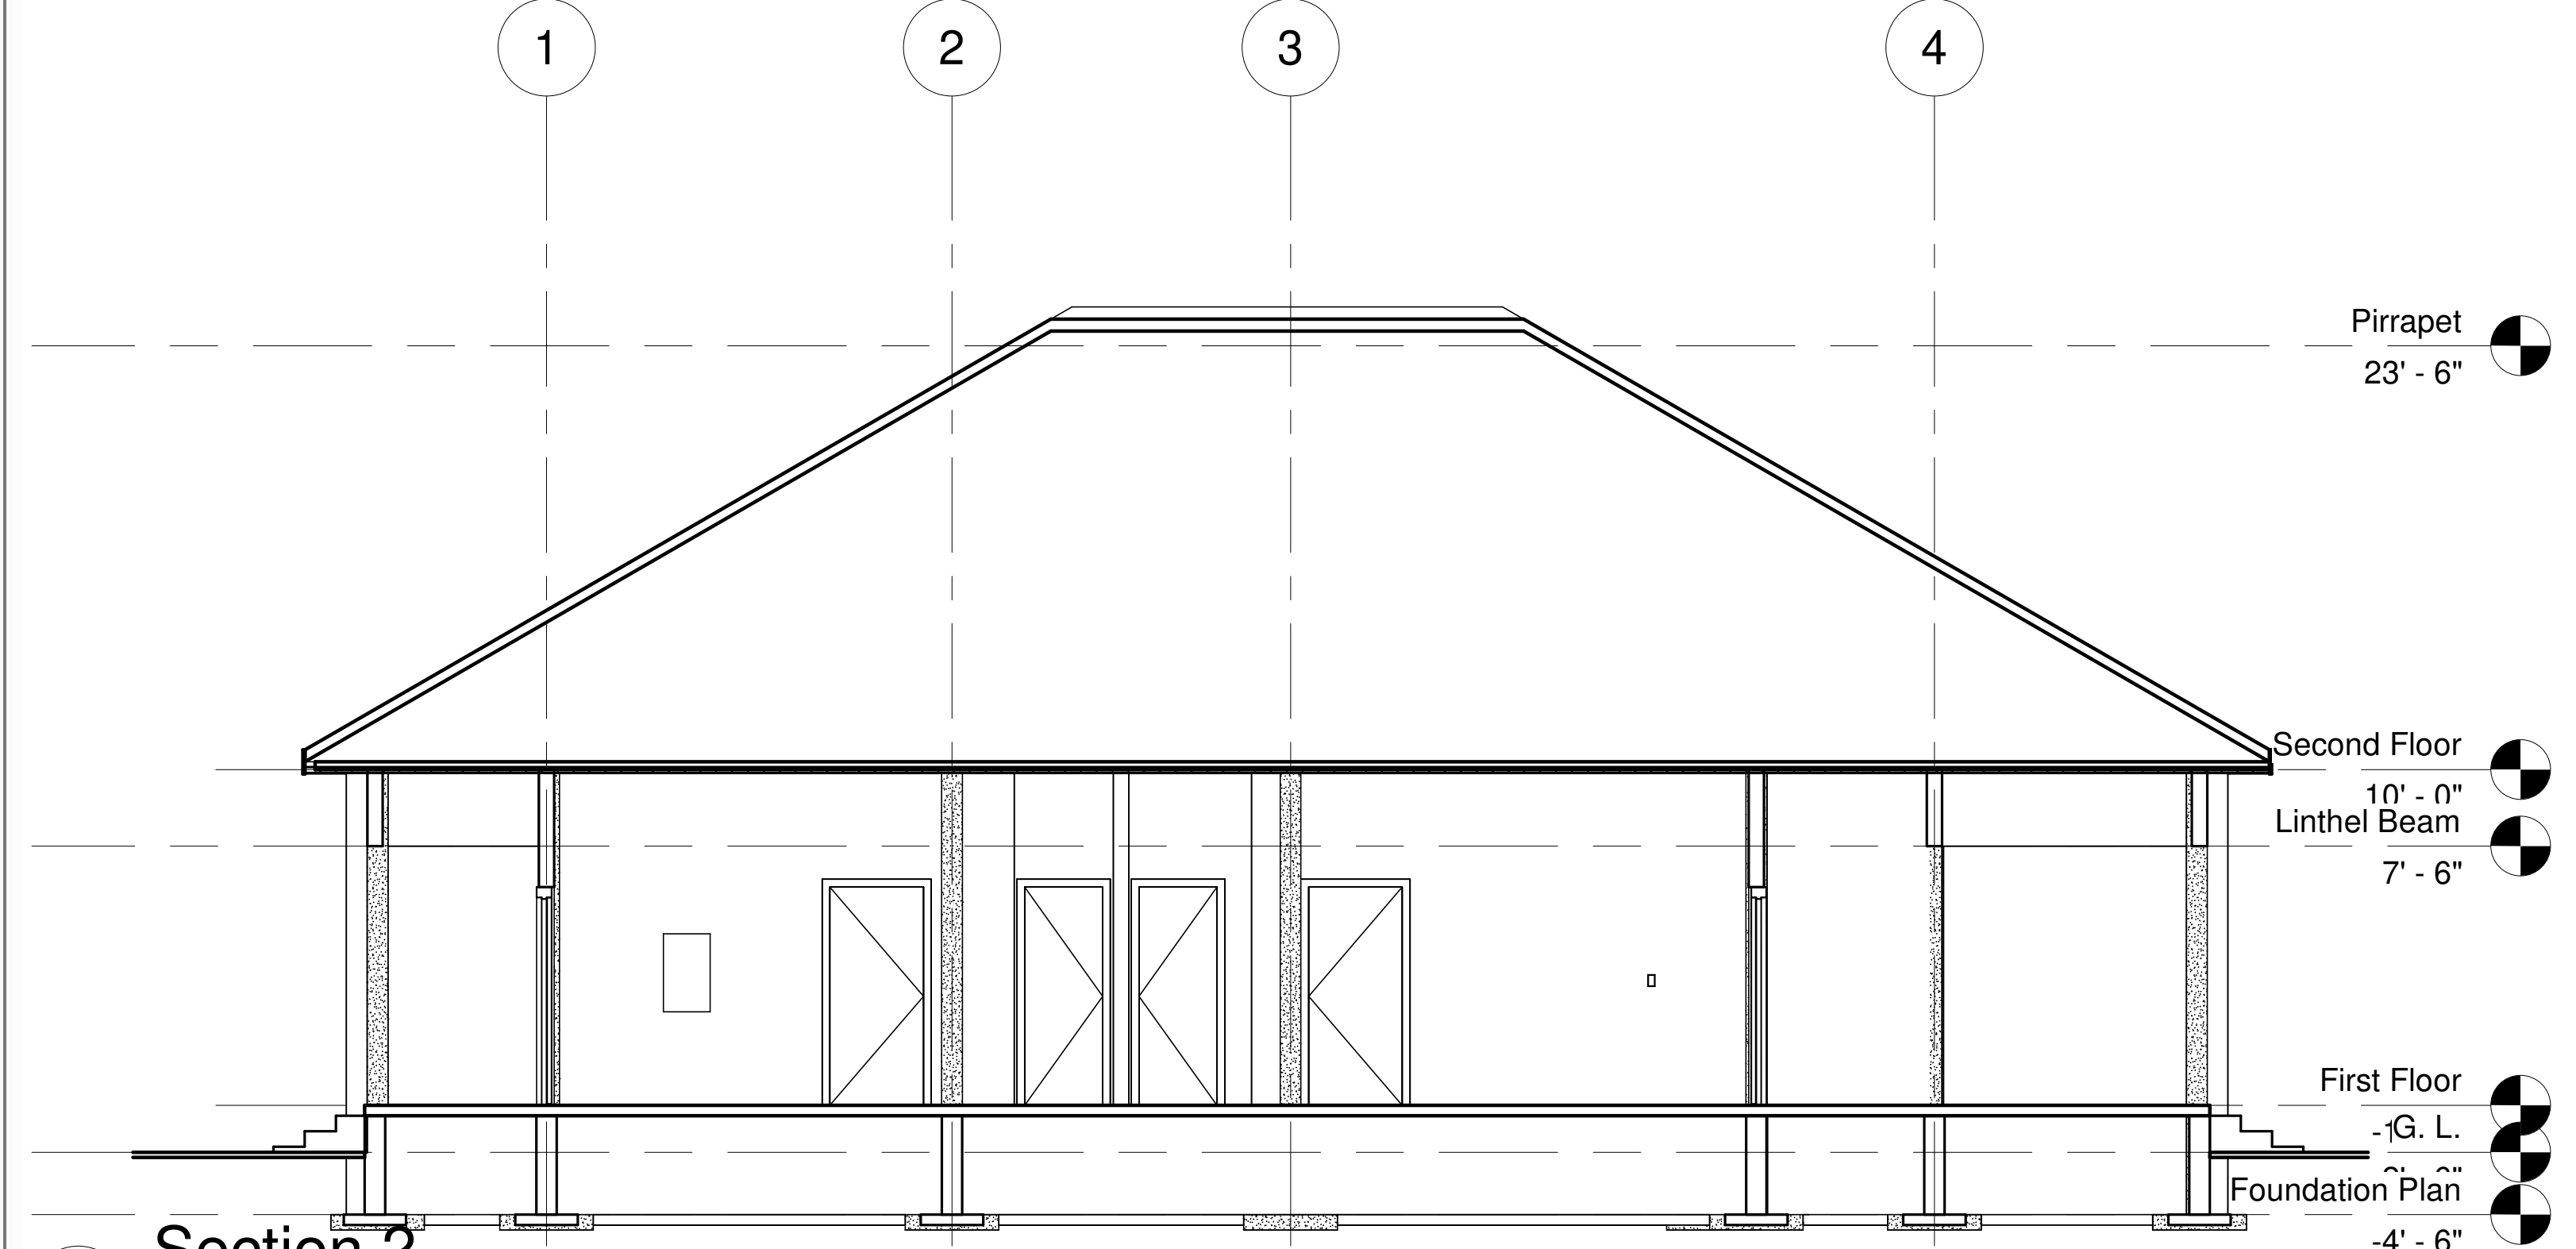

2 Section 2
1 : 73


IFC DRAWING

Owner:
Ministry of Mines
and Energy

Project:
County Office

SECTION DETAILS

Project Number	002
Date	JULY 2026
Drawn By	MME Engineers
Checked By	
S106	
Scale	

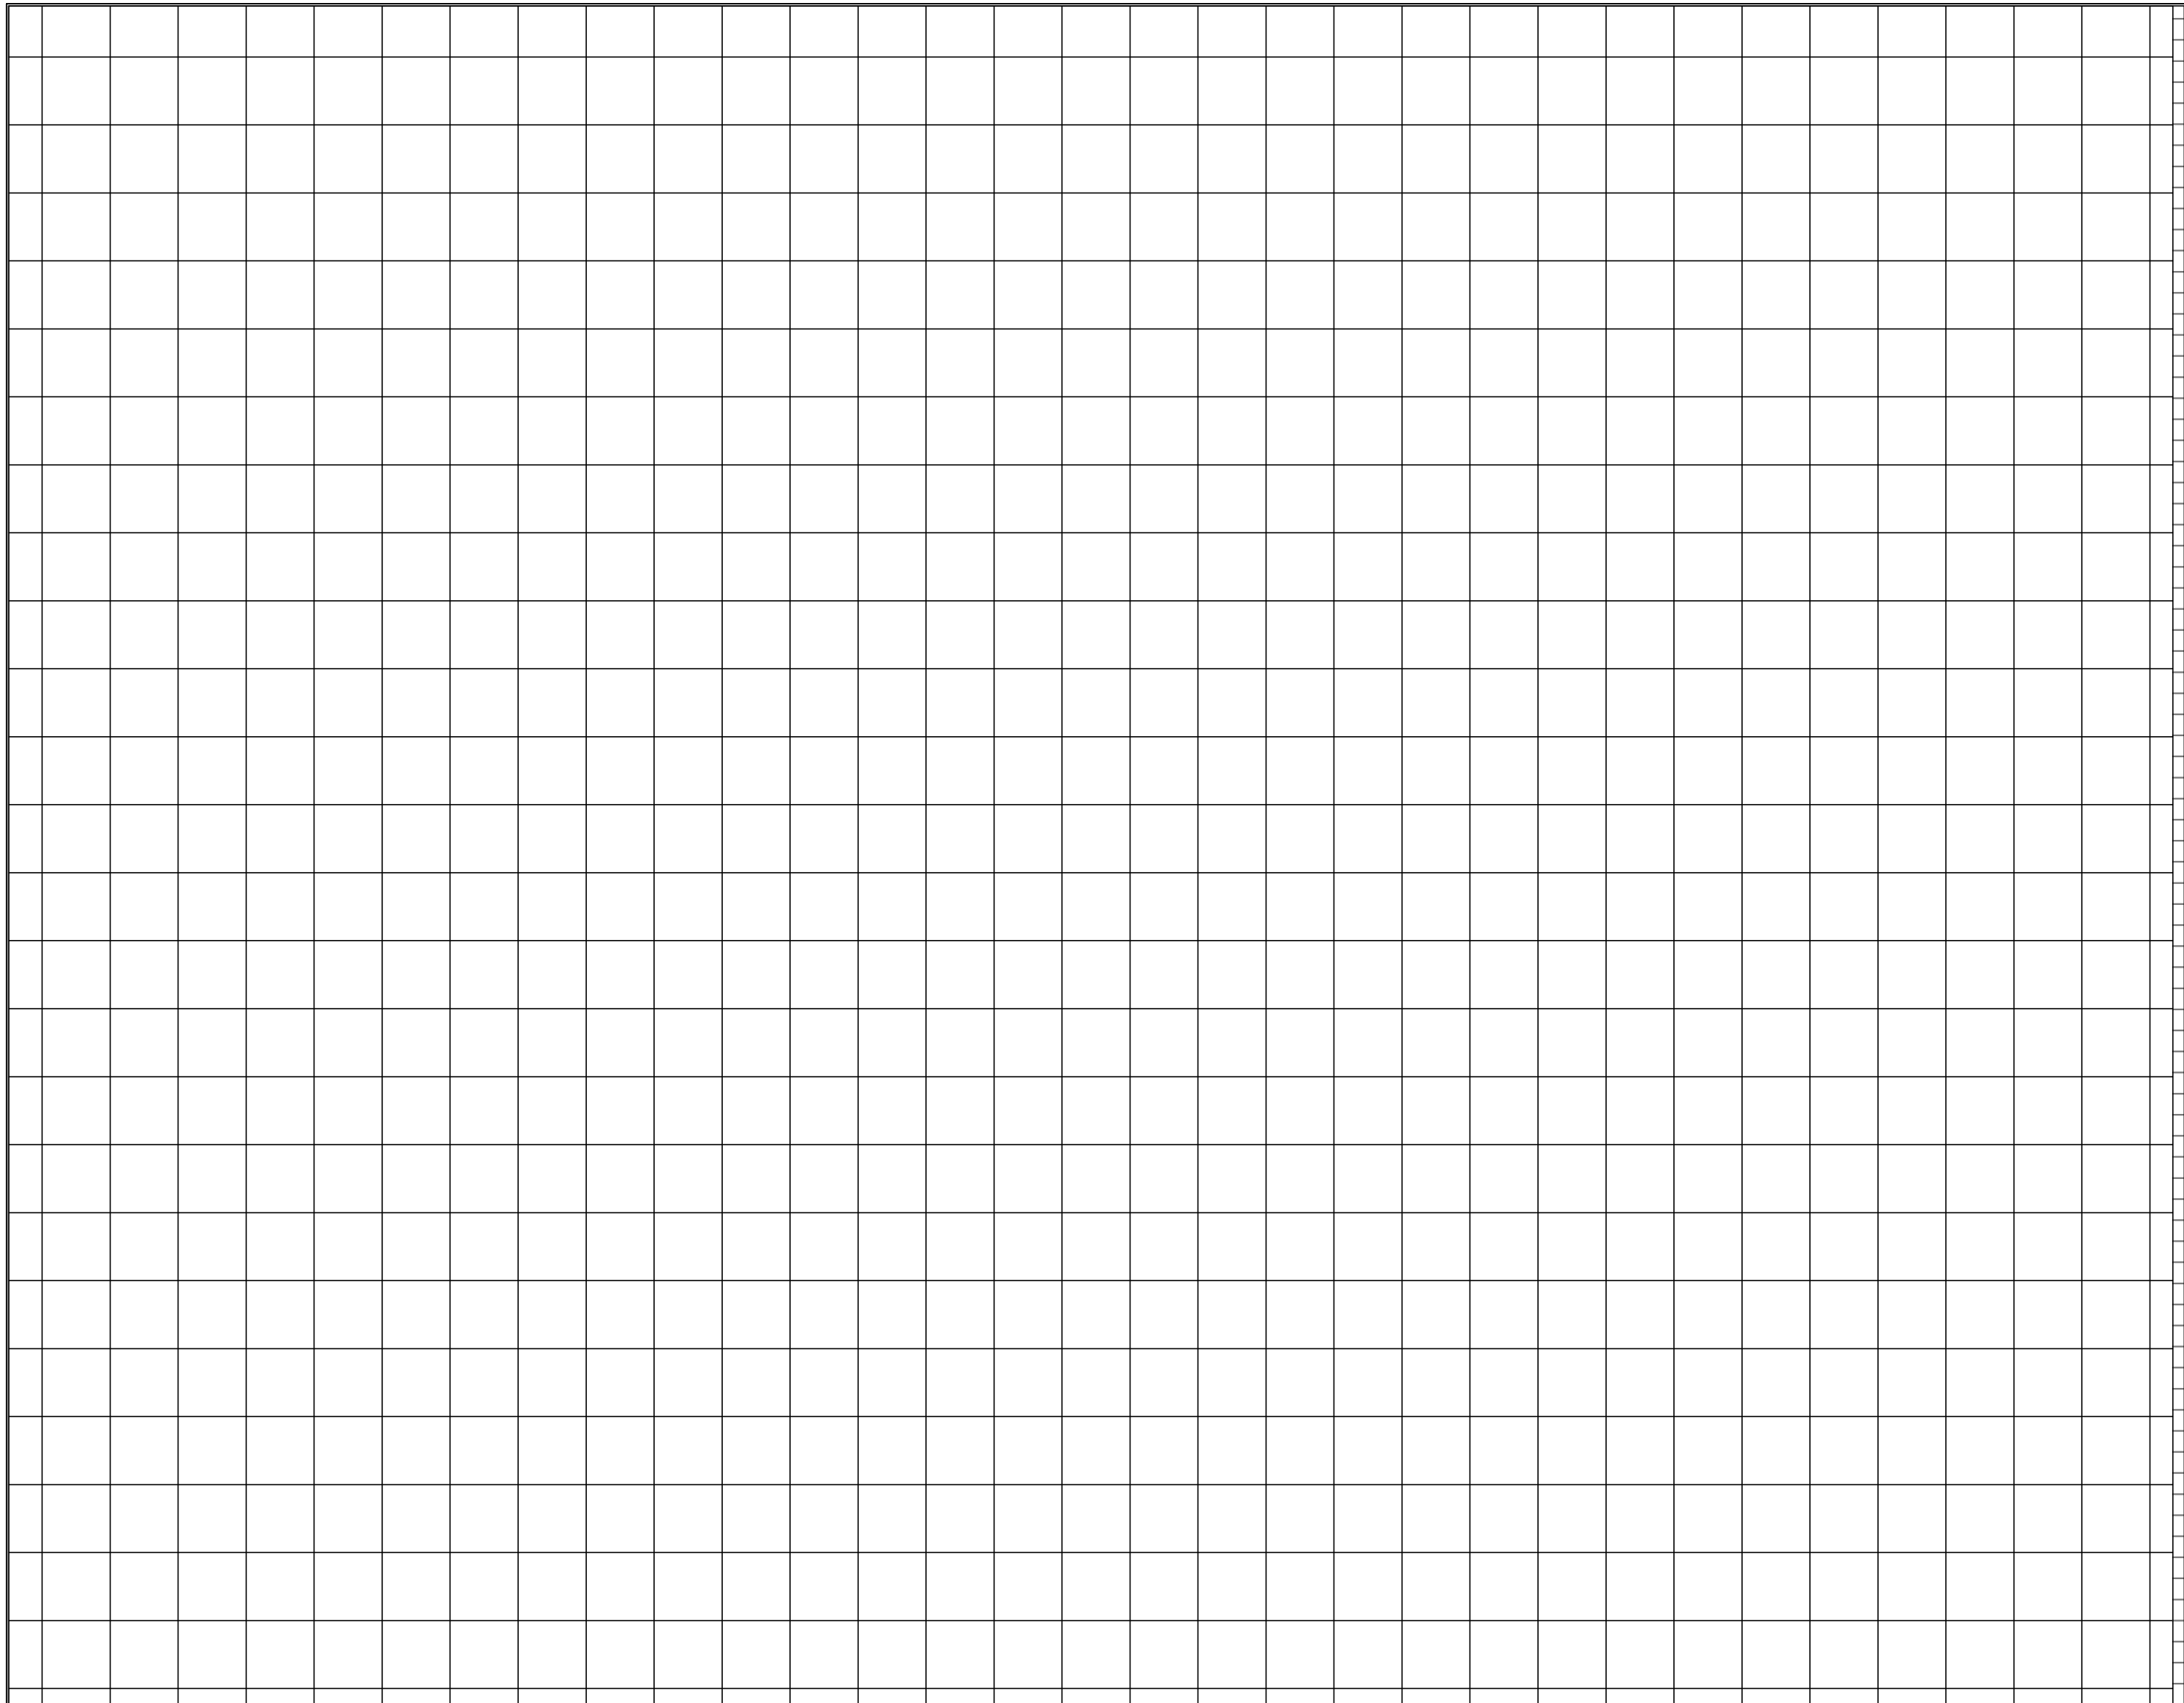

1 : 62
1
Ceiling Plan


IFC DRAWING

Owner:
Ministry of Mines
and Energy

Project:
County Office


CEILING PLAN

Project Number:	002
Date	JULY 2026
Drawn By	MME Engineers
Checked By	
A105	
Scale	

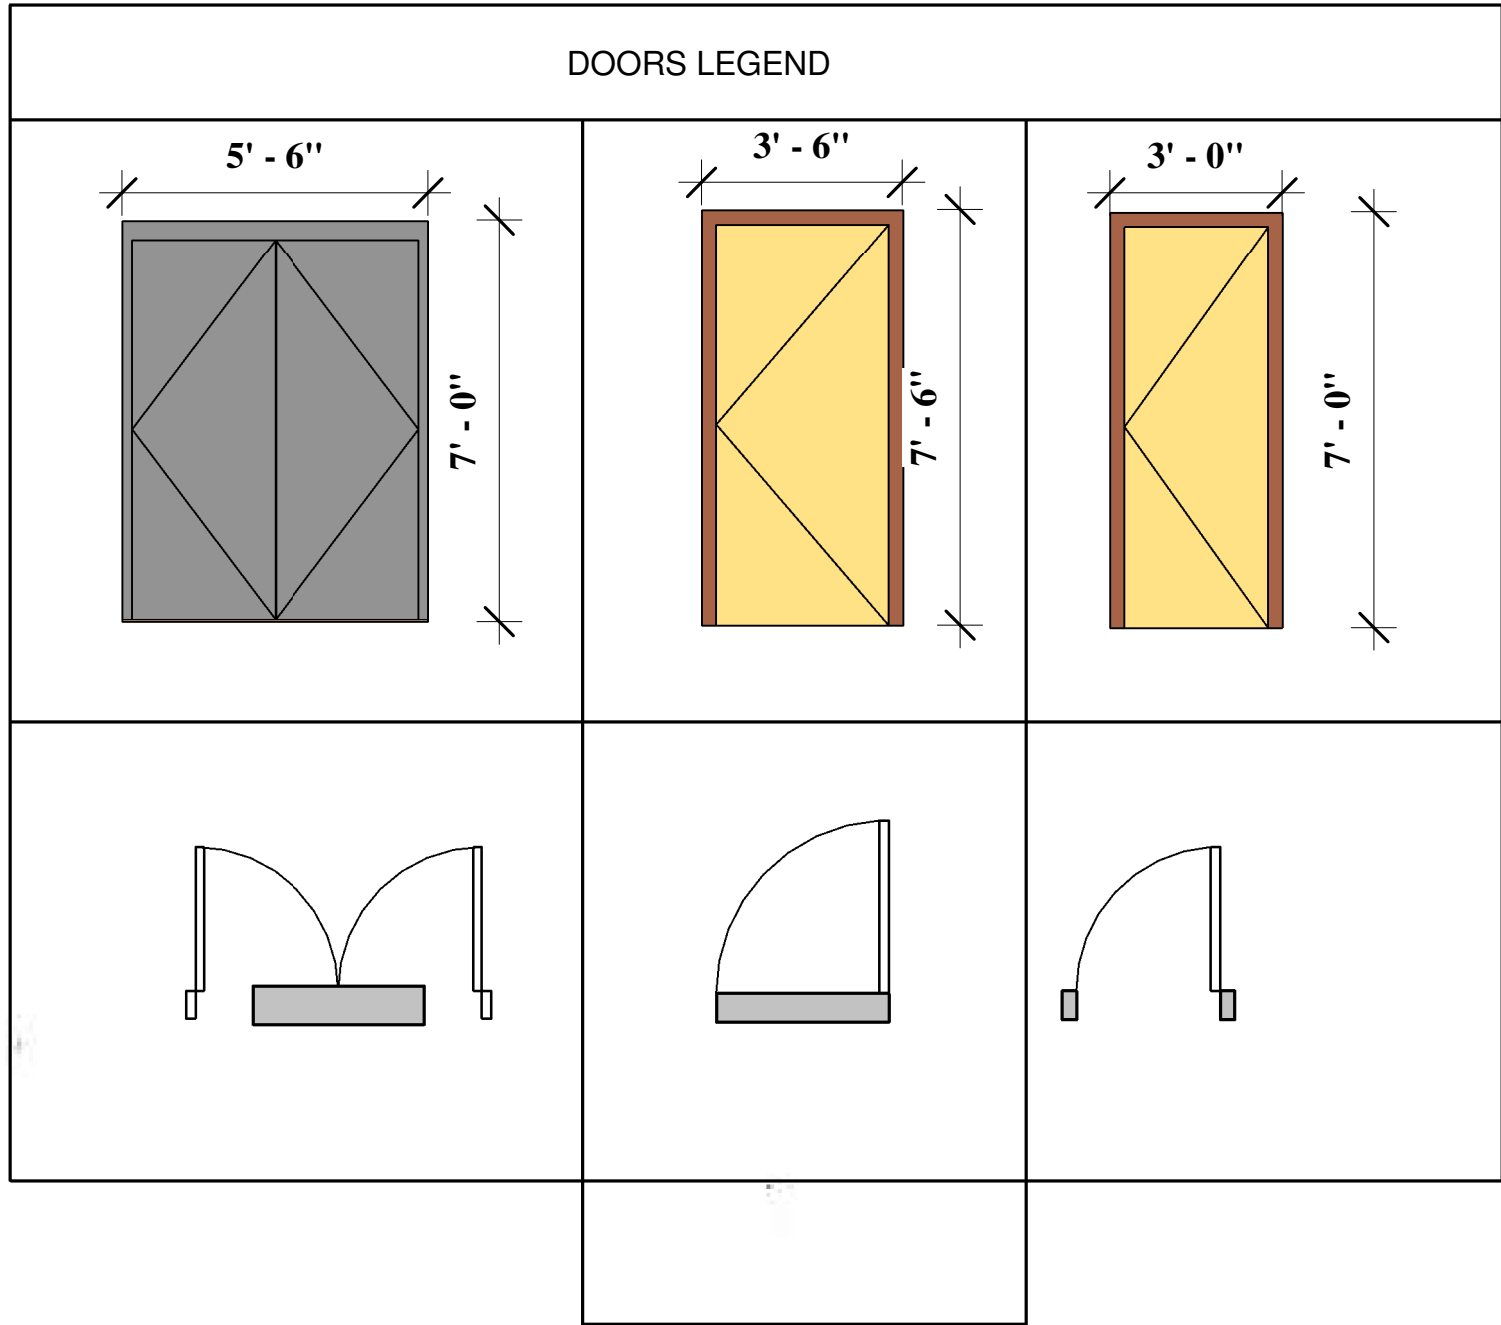

Doors Legend
1 : 50

Door Schedule					
Count	Height	Level	Thickness	Width	Type Mark
1	7' - 0"	First Floor	0' - 0"	5' - 0"	D2
1	6' - 6"	First Floor	0' - 0"	5' - 0"	D1
1	7' - 0"	First Floor	0' - 0"	3' - 0"	D2
1	6' - 6"	First Floor	0' - 0"	5' - 0"	D1
1	6' - 6"	First Floor	0' - 0"	5' - 0"	D1
1	7' - 0"	First Floor	0' - 0"	2' - 6"	D3
1	7' - 0"	First Floor	0' - 0"	2' - 6"	D3
1	7' - 0"	First Floor	0' - 0"	3' - 0"	D2

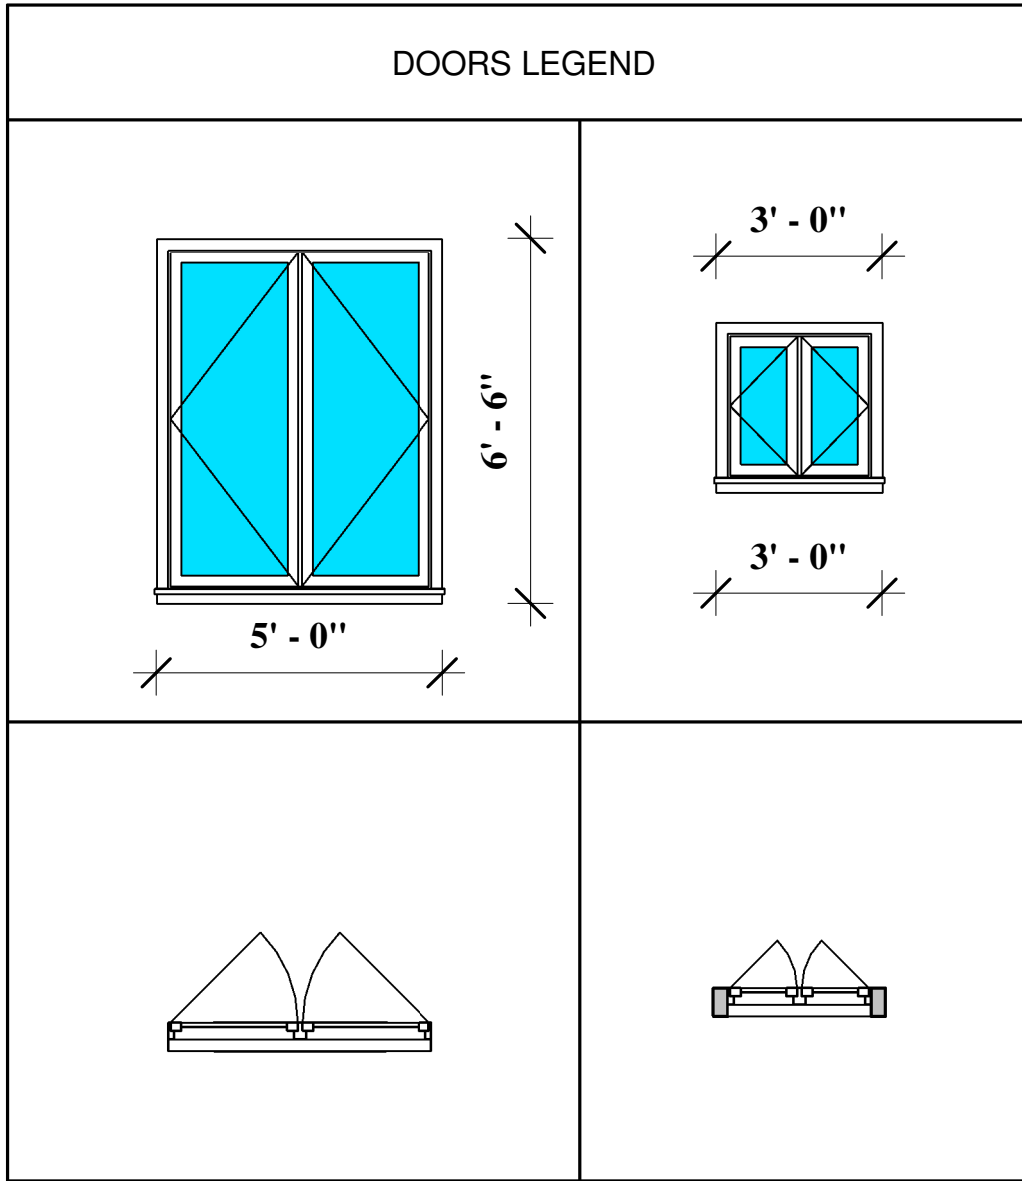

Window Schedule					
Count	Height	Level	Mark	Width	
1	2' - 6"	First Floor	W2	2' - 6"	
1	2' - 6"	First Floor	W2	2' - 6"	
1	6' - 0"	First Floor	W1	4' - 6"	
1	6' - 0"	First Floor	W1	4' - 6"	
1	6' - 0"	First Floor	W3	2' - 6"	


IFC DRAWING

Owner:
Ministry of Mines
and Energy


Project:
County Office

DOORS & WINDOWS


Project Number	002
Date	JULY 2026
Drawn By	MME Engineers
Checked By	
A106	
Scale	

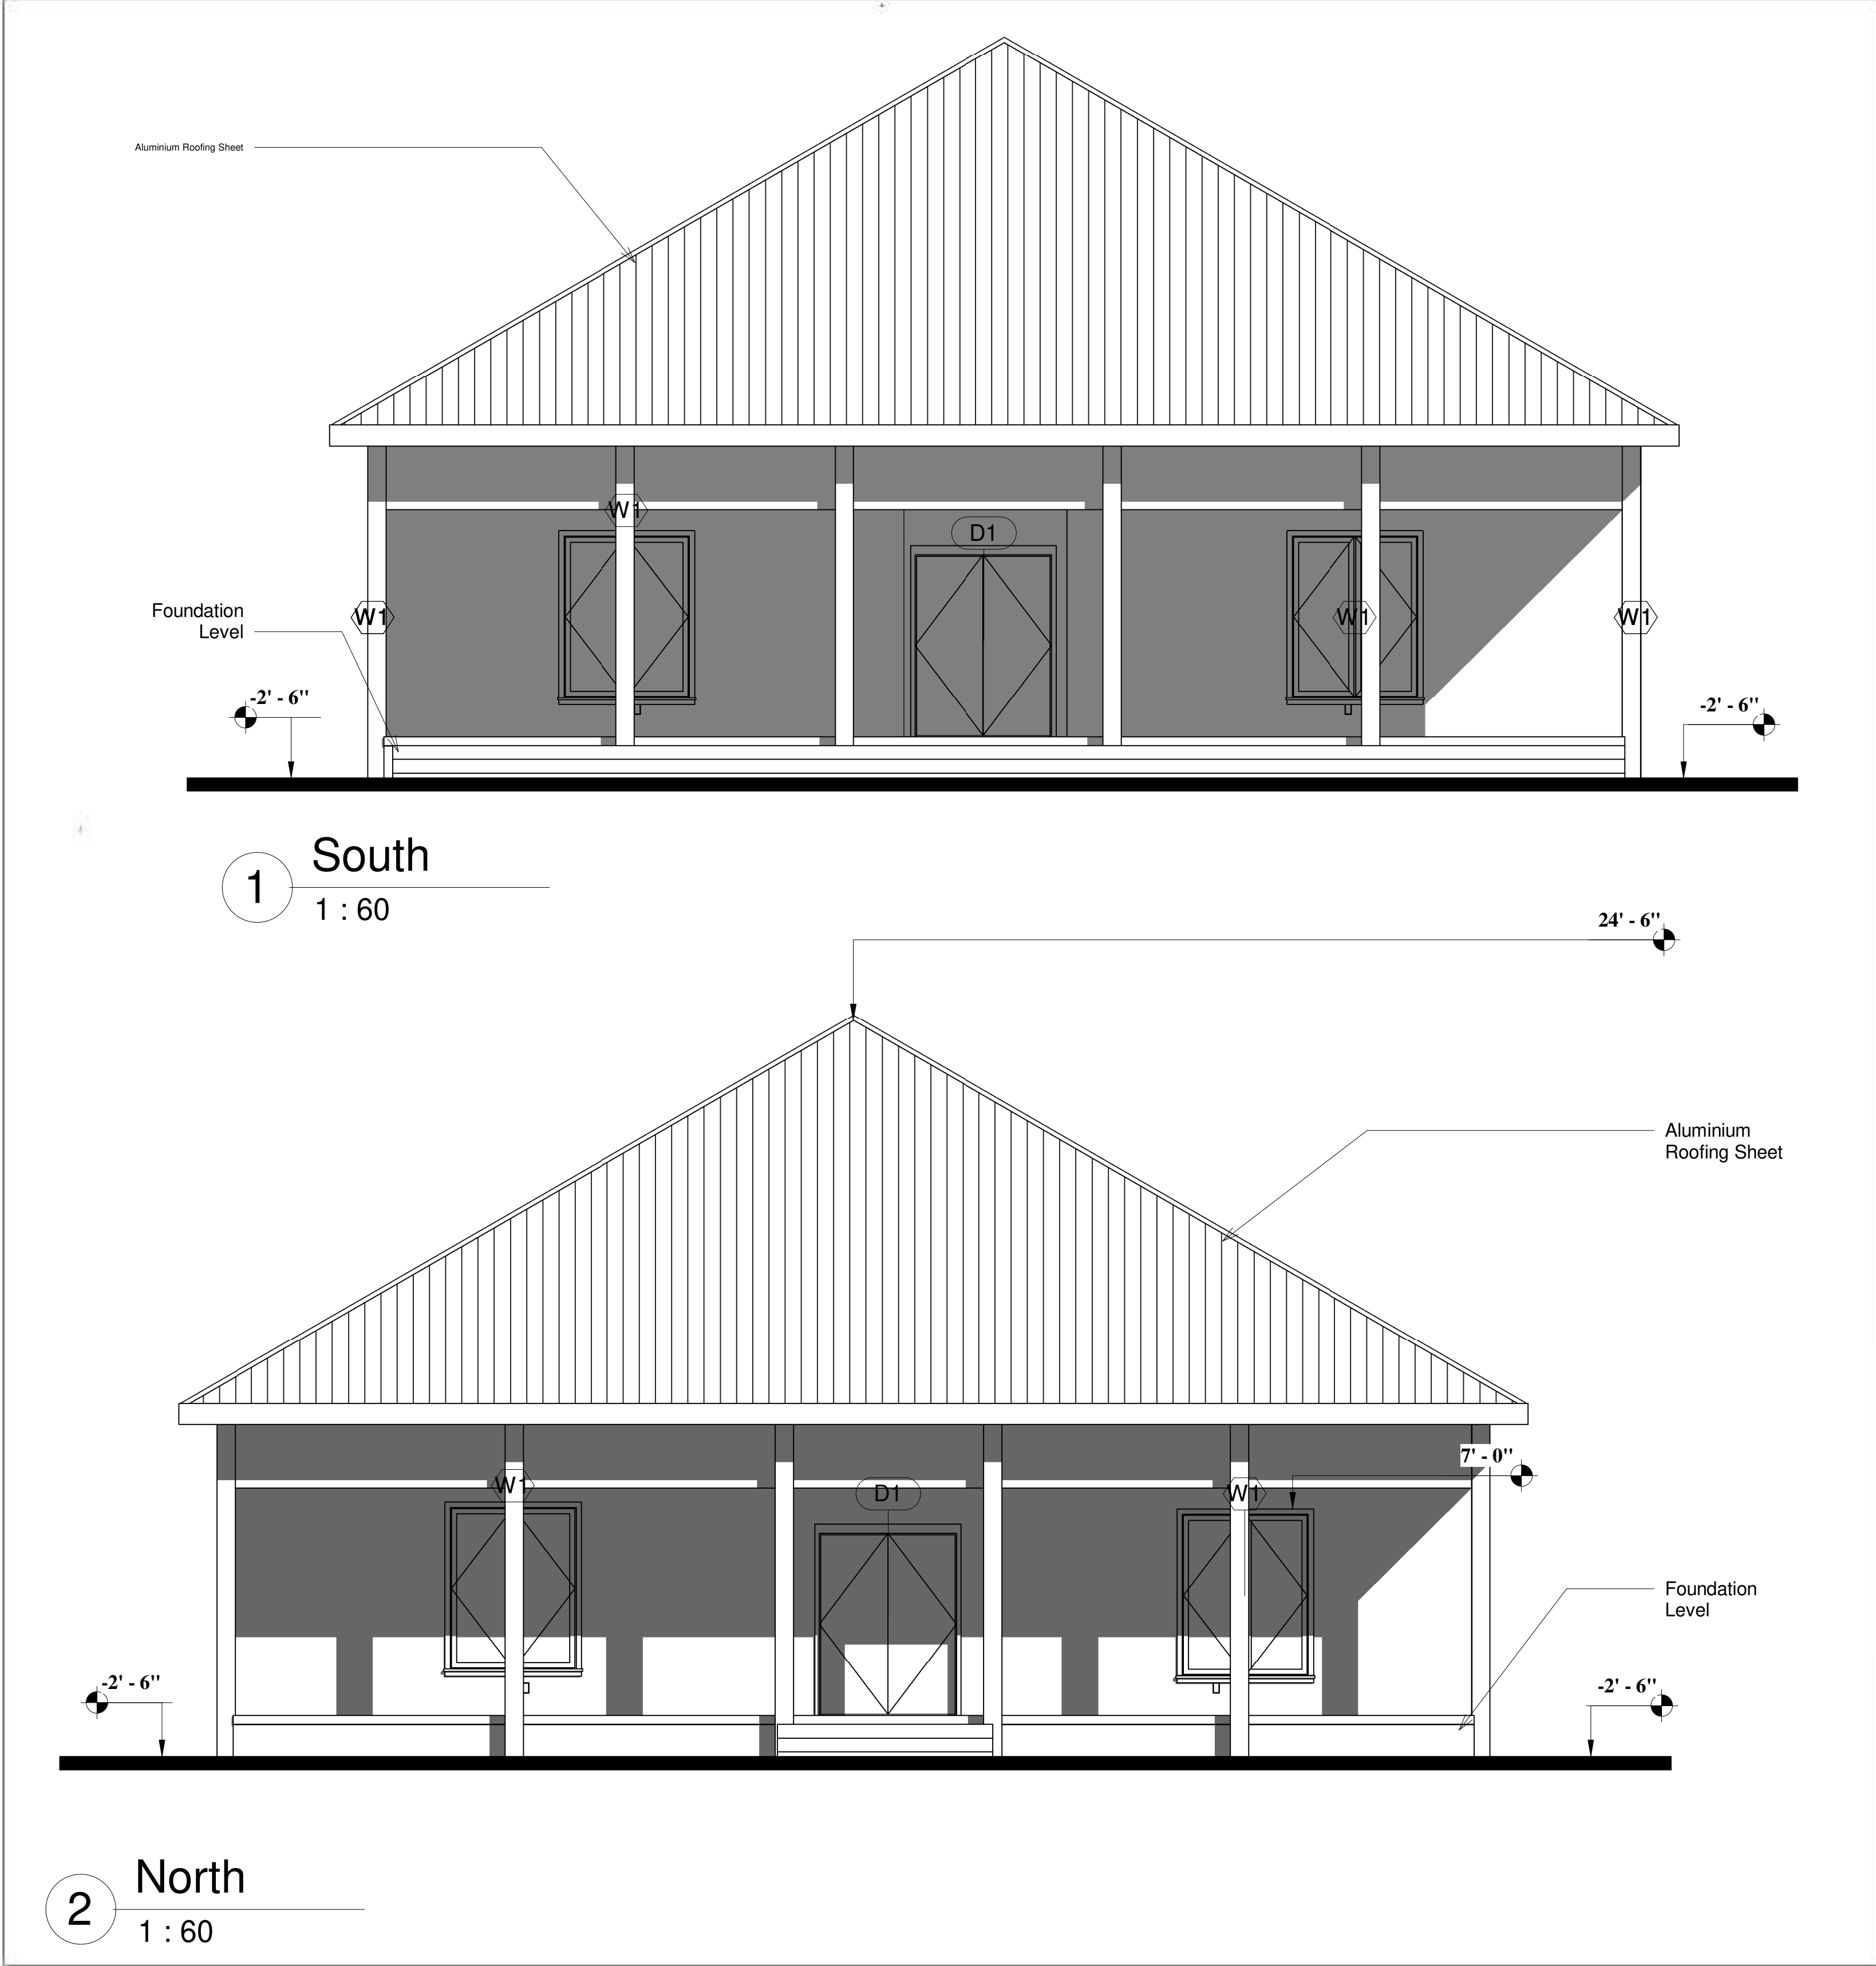

IFC DRAWING	
Owner: Ministry of Mines and Energy	
Project: County Office	
ELEVATIONS	
Project Number	002
Date	JULY 2026
Drawn By	MME Engineers
Checked By	
A107	
Scale	

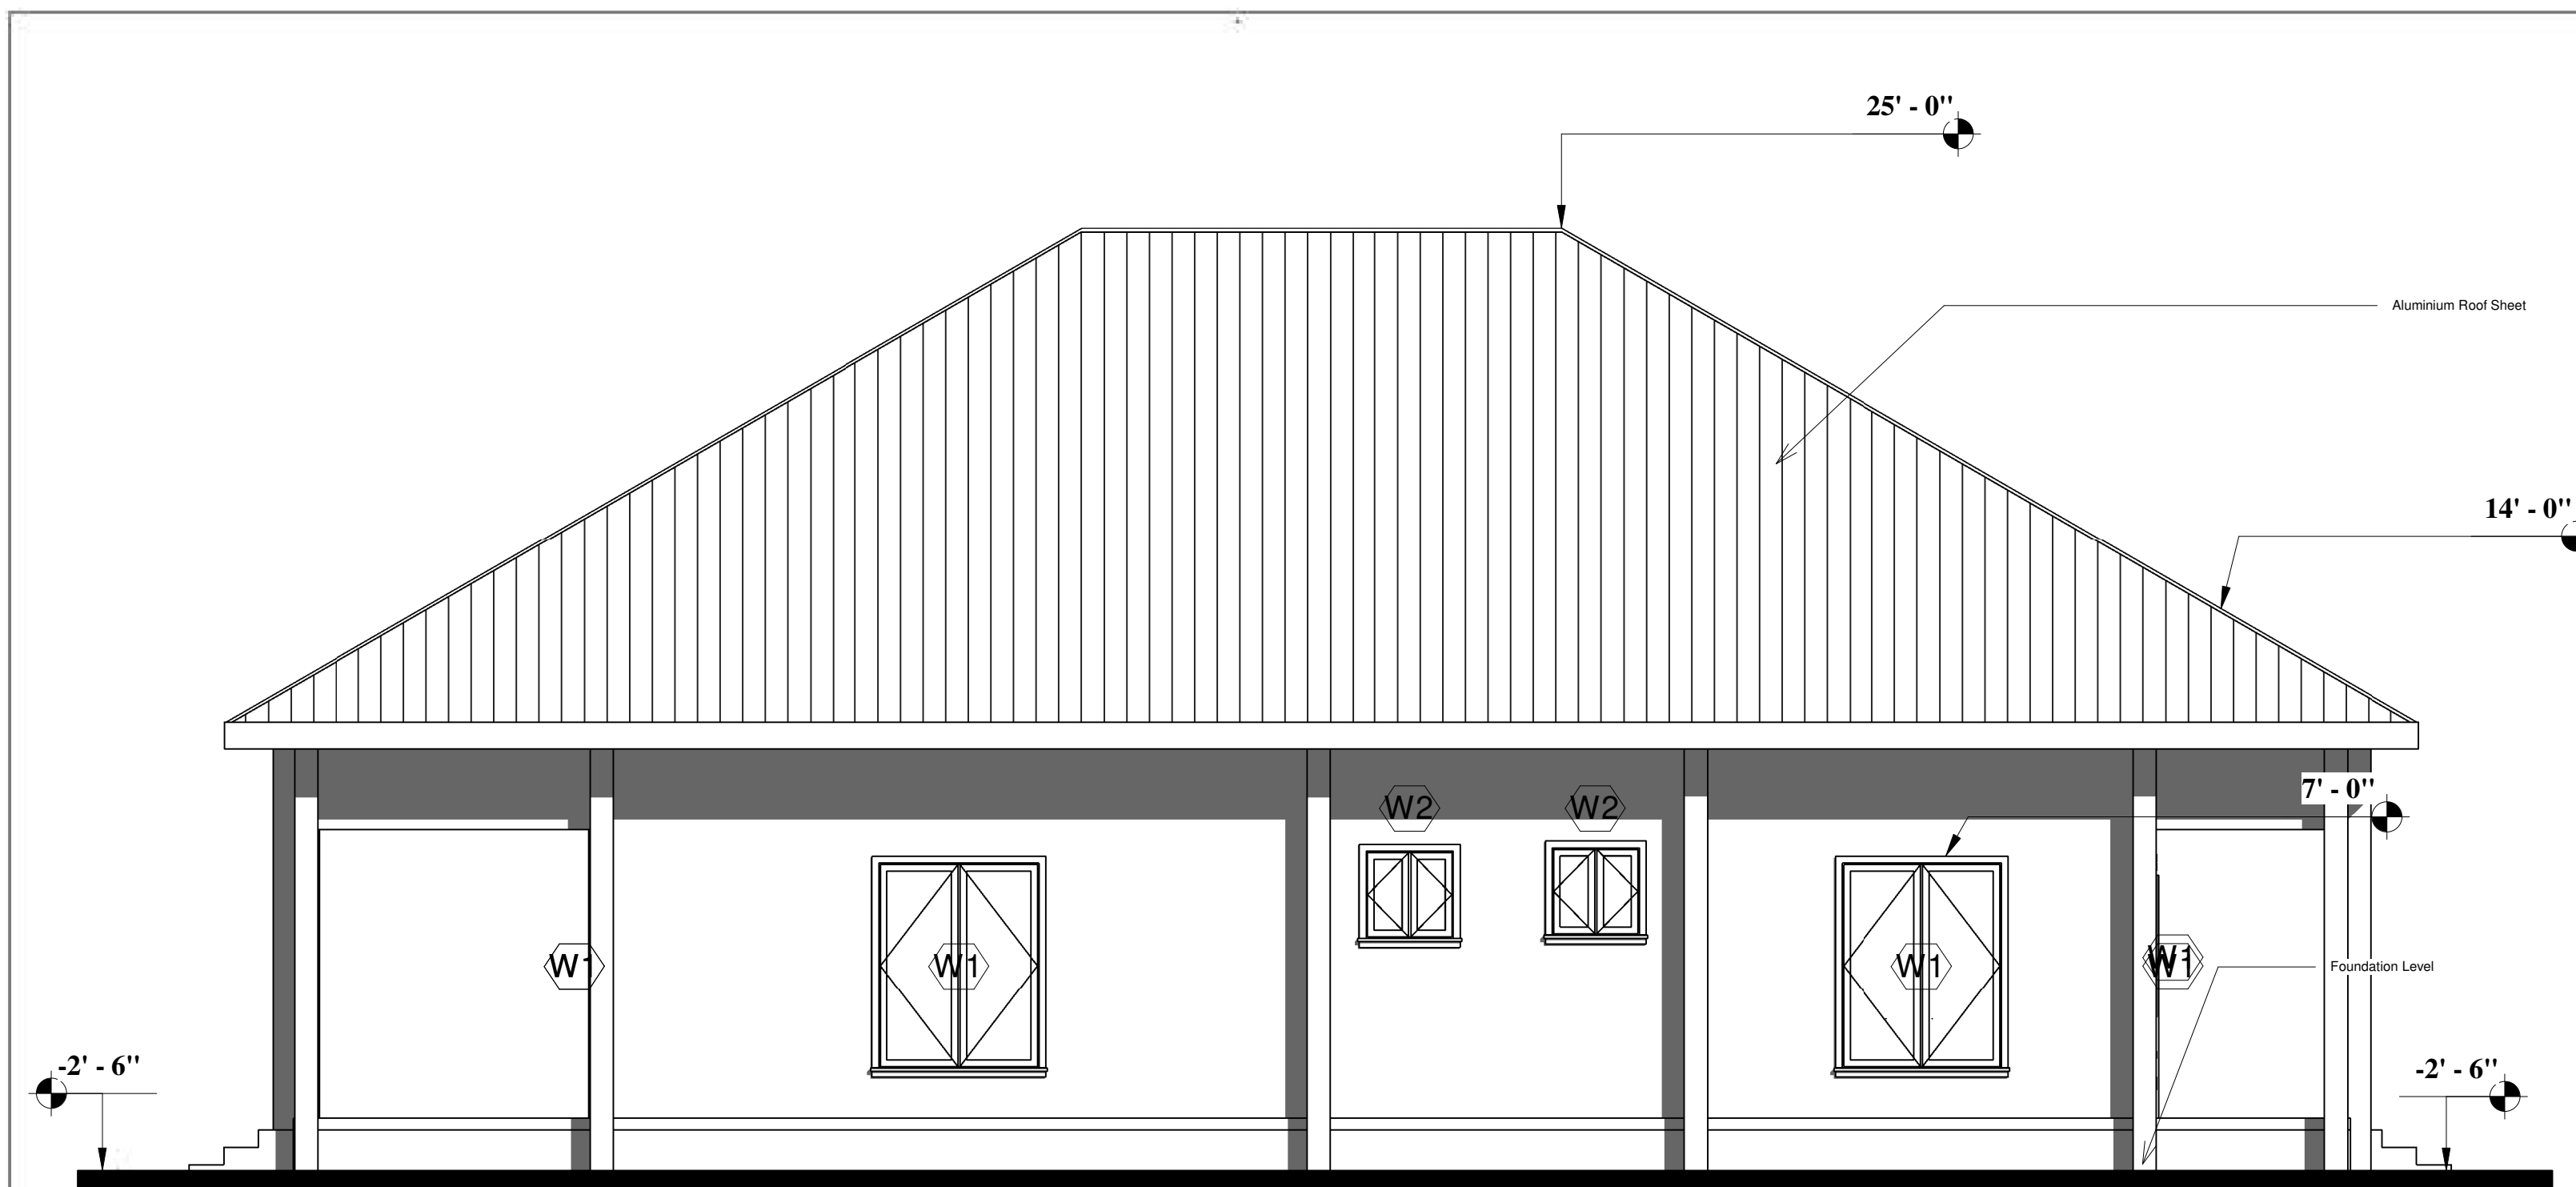

1 East
1 : 66

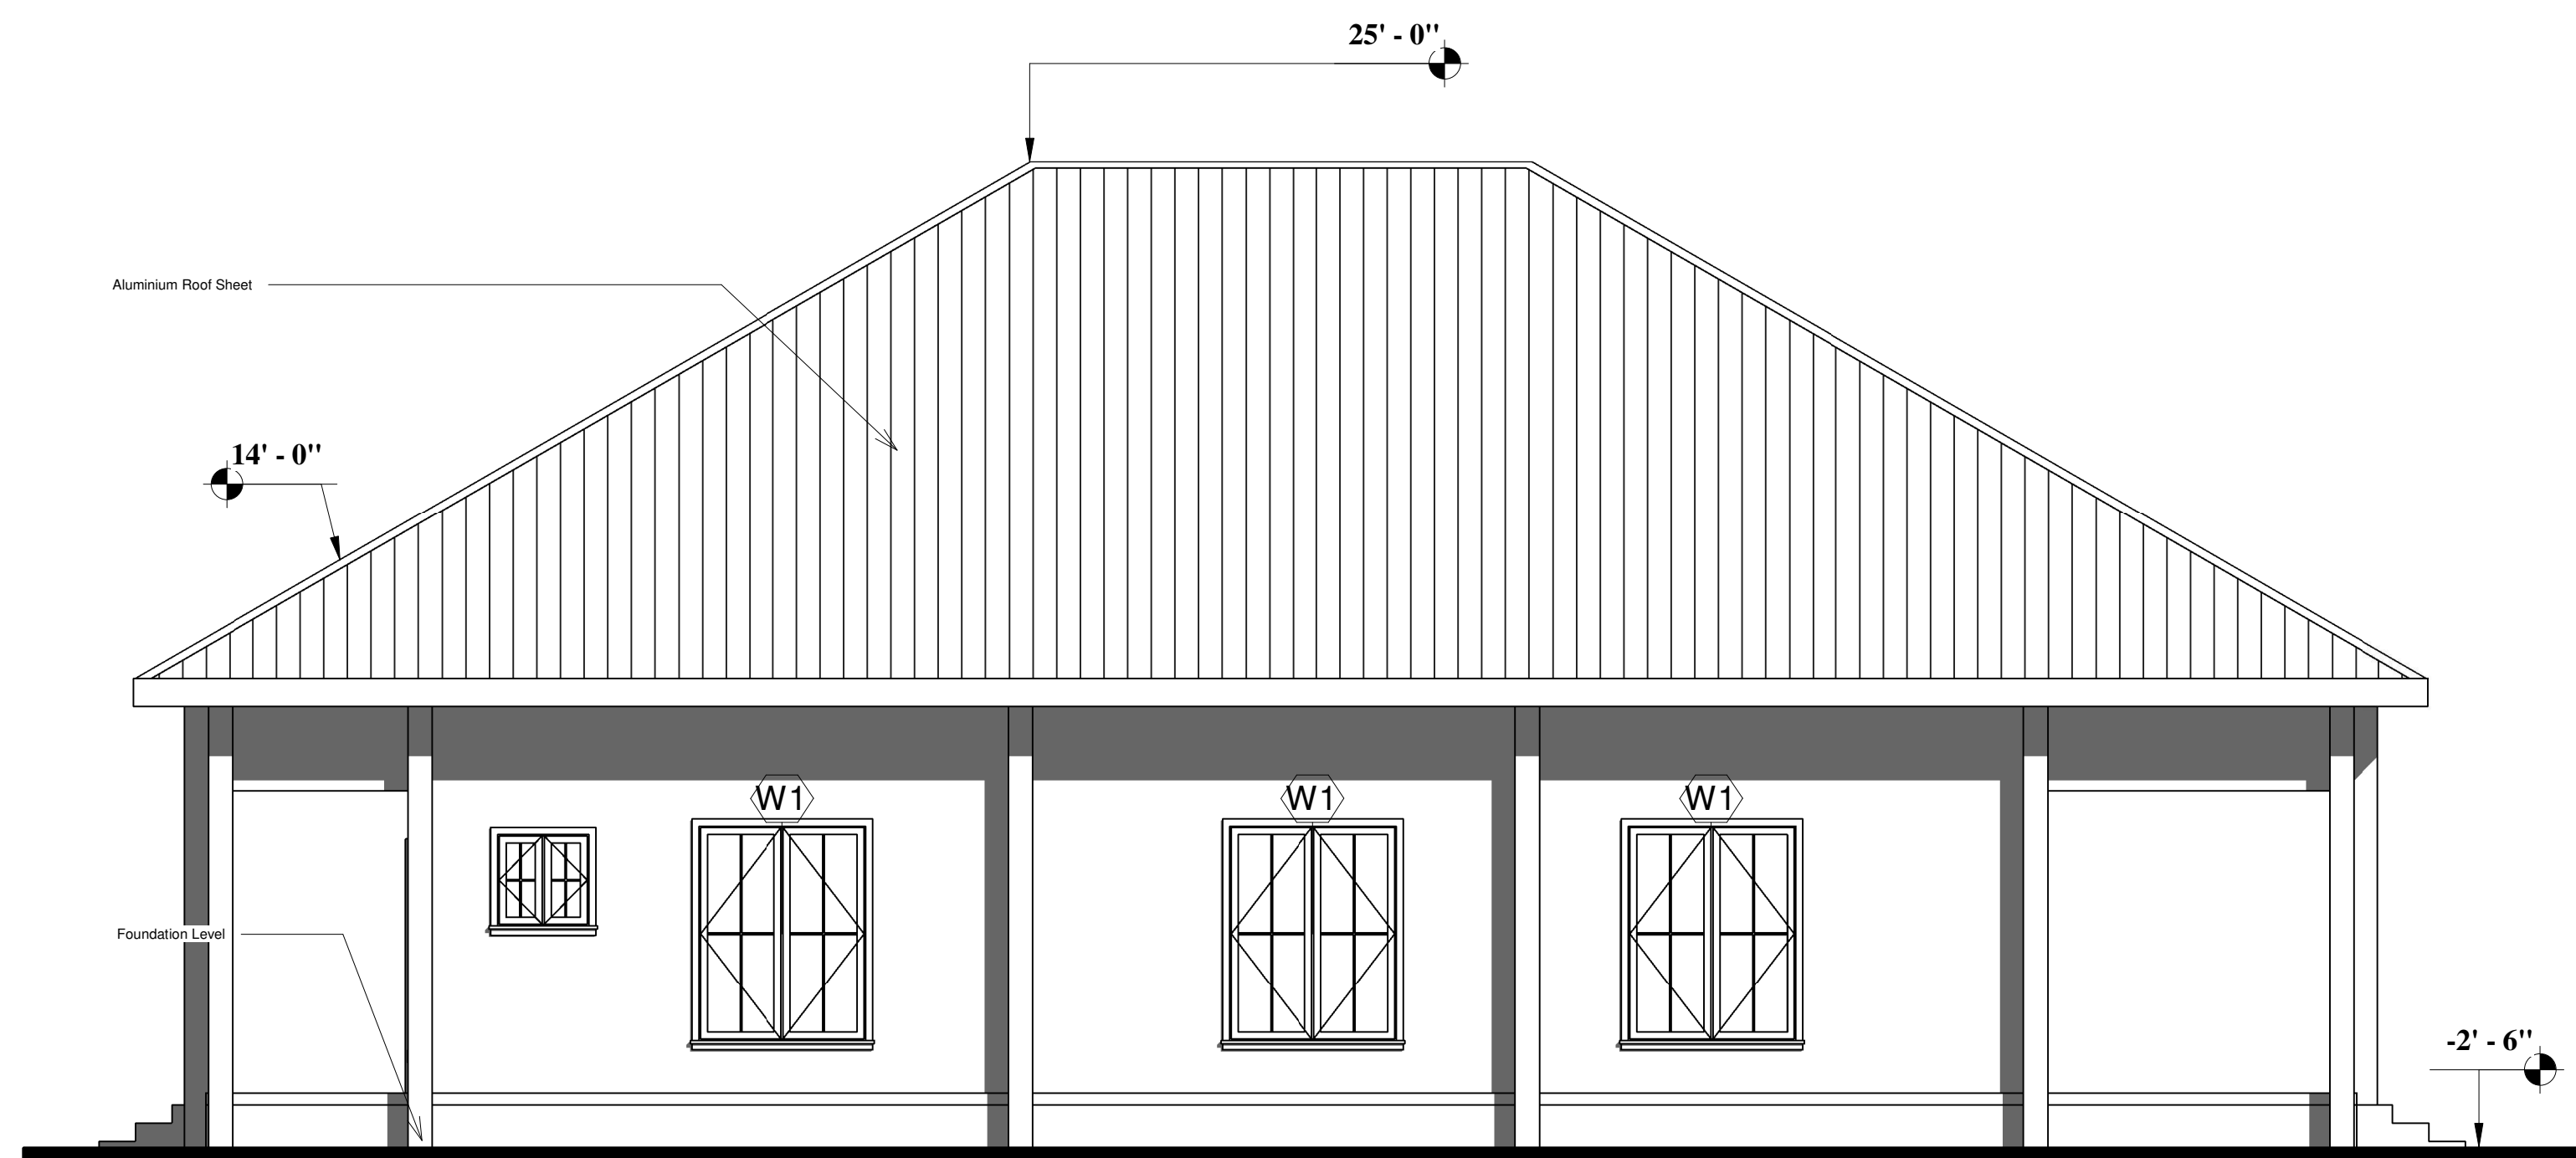

2 West
1 : 66

IFC DRAWING

Owner:
Ministry of Mines
and Energy


Project:
County Office

ELEVATIONS 1

Project Number	002
Date	JULY 2026
Drawn By	MME Engineers
Checked By	


A108

Scale

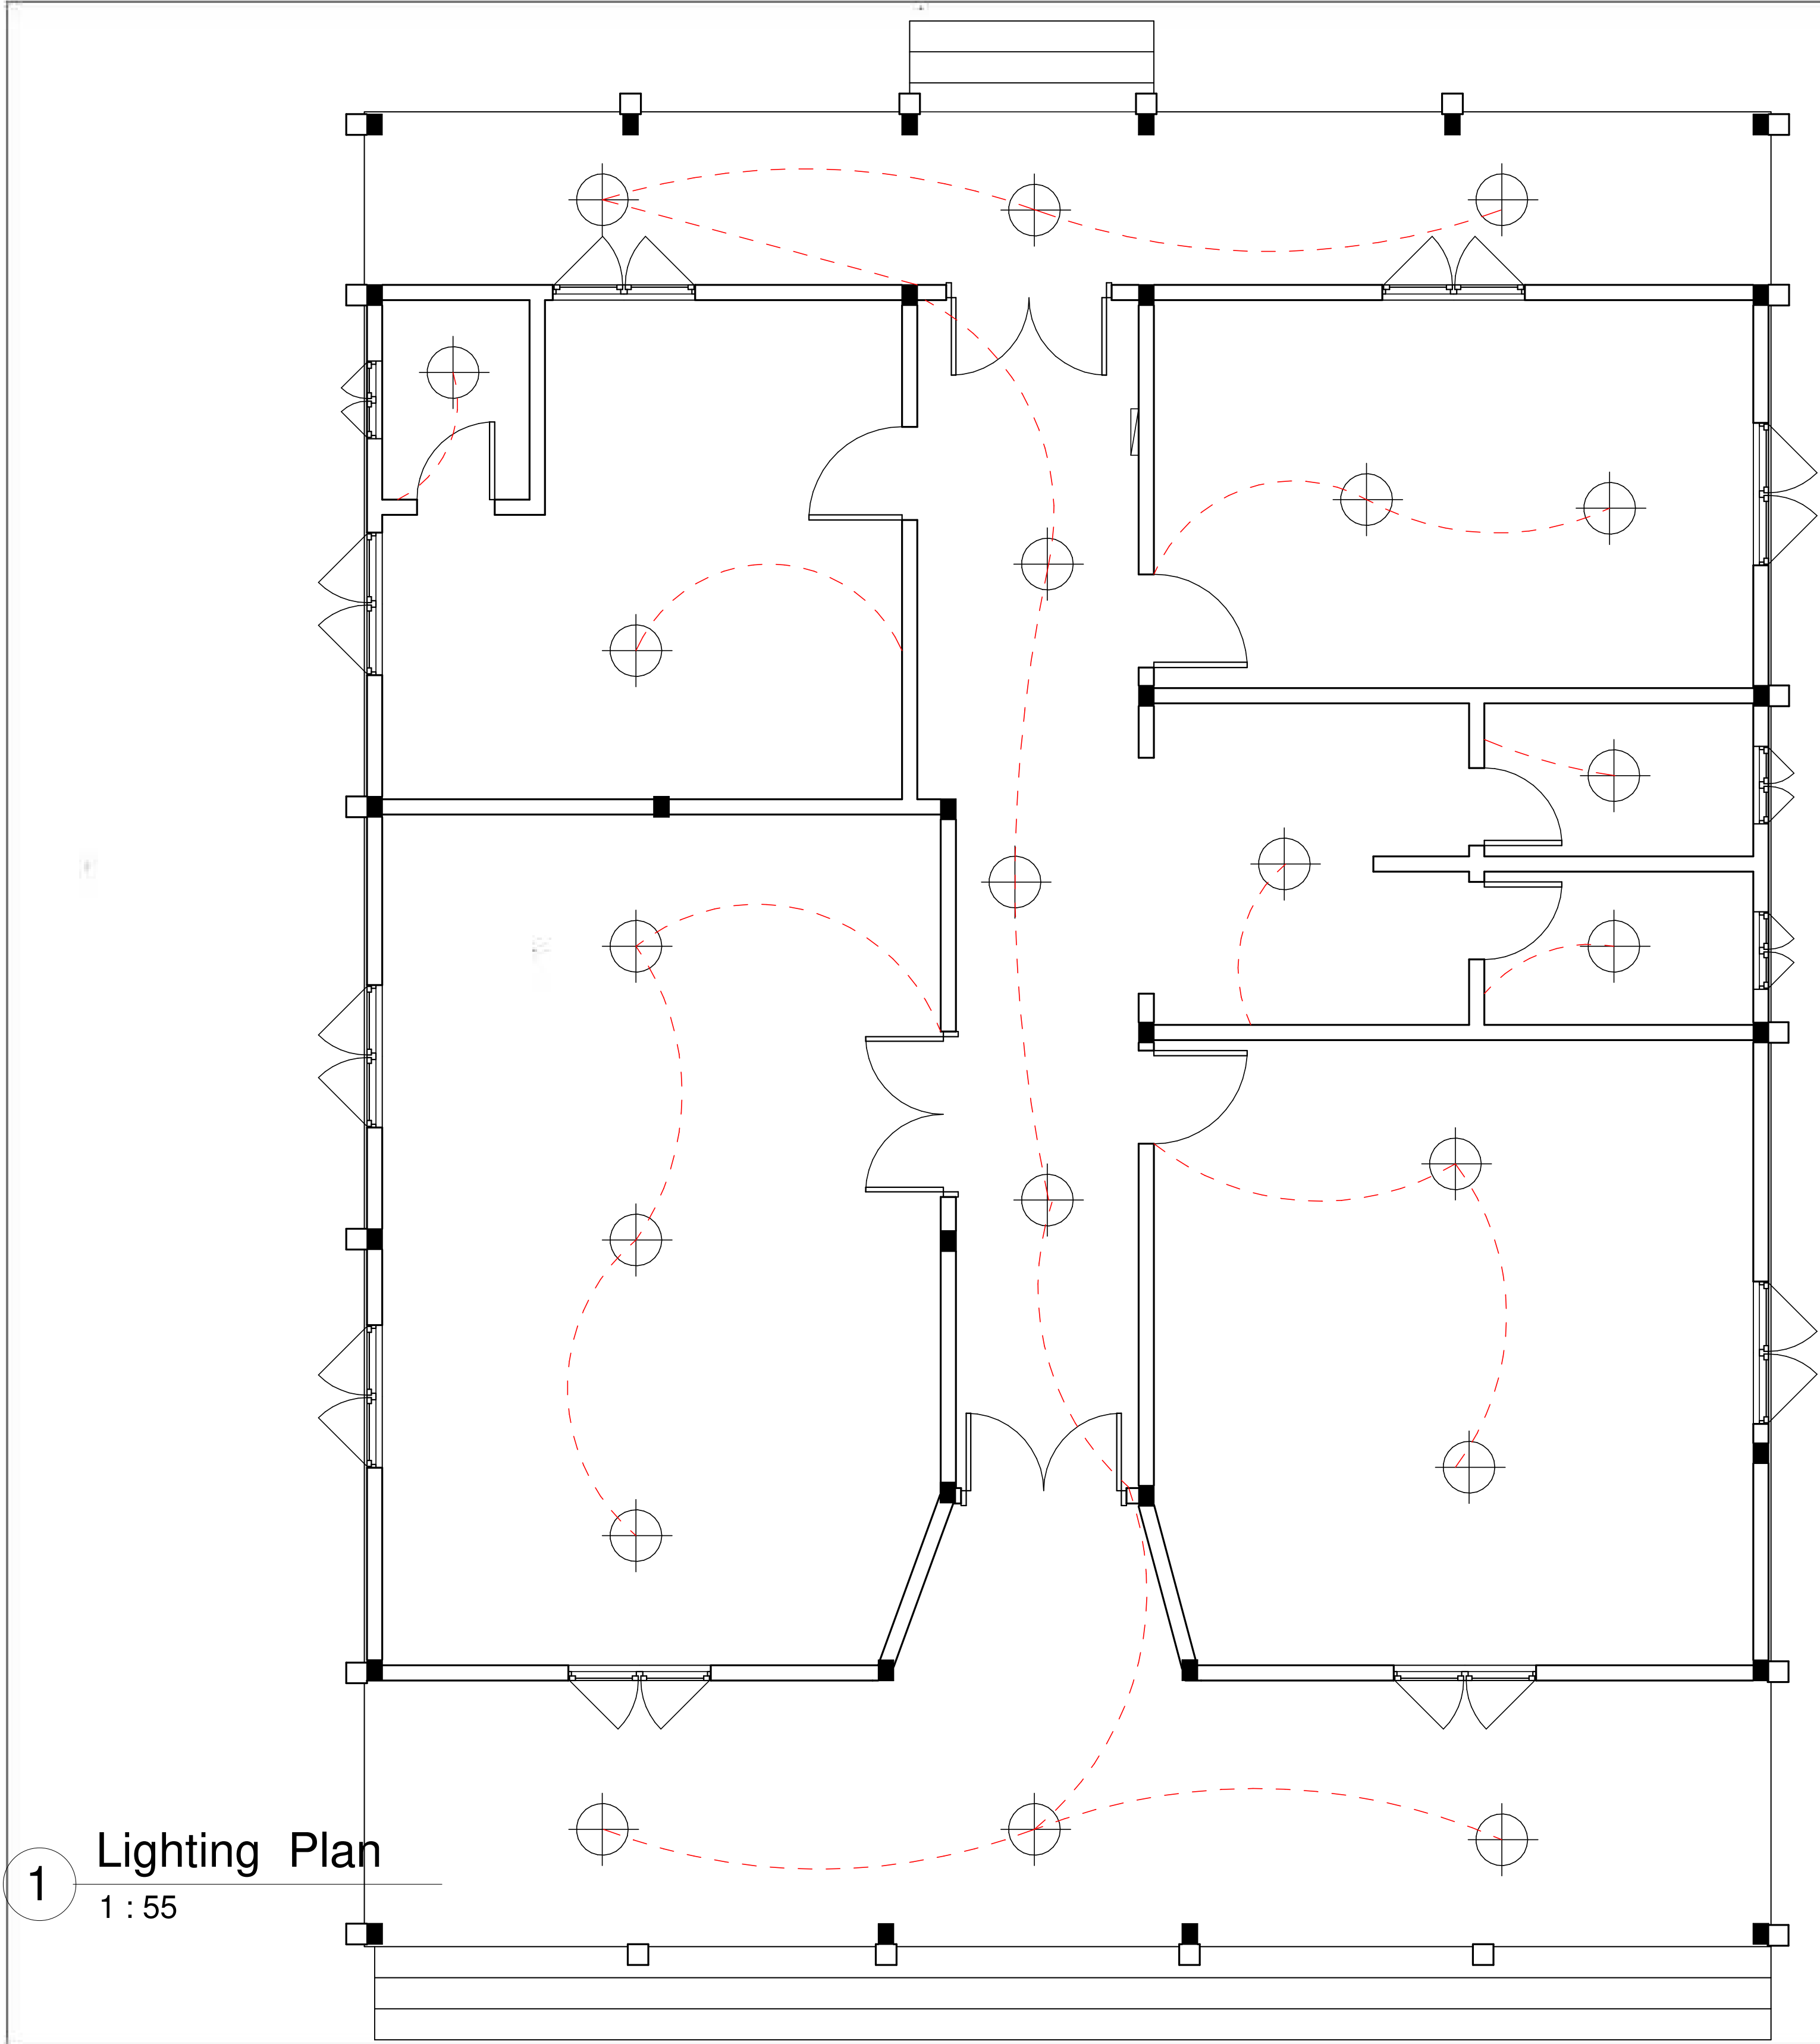


1 Lighting Plan
1 : 55

IFC DRAWING	
Owner: Ministry of Mines and Energy	
Project: County Office	
LIGHTING PLAN	
Project Number	002
Date	JULY 2026
Drawn By	MME Engineers
Checked By	
E101	
Scale	

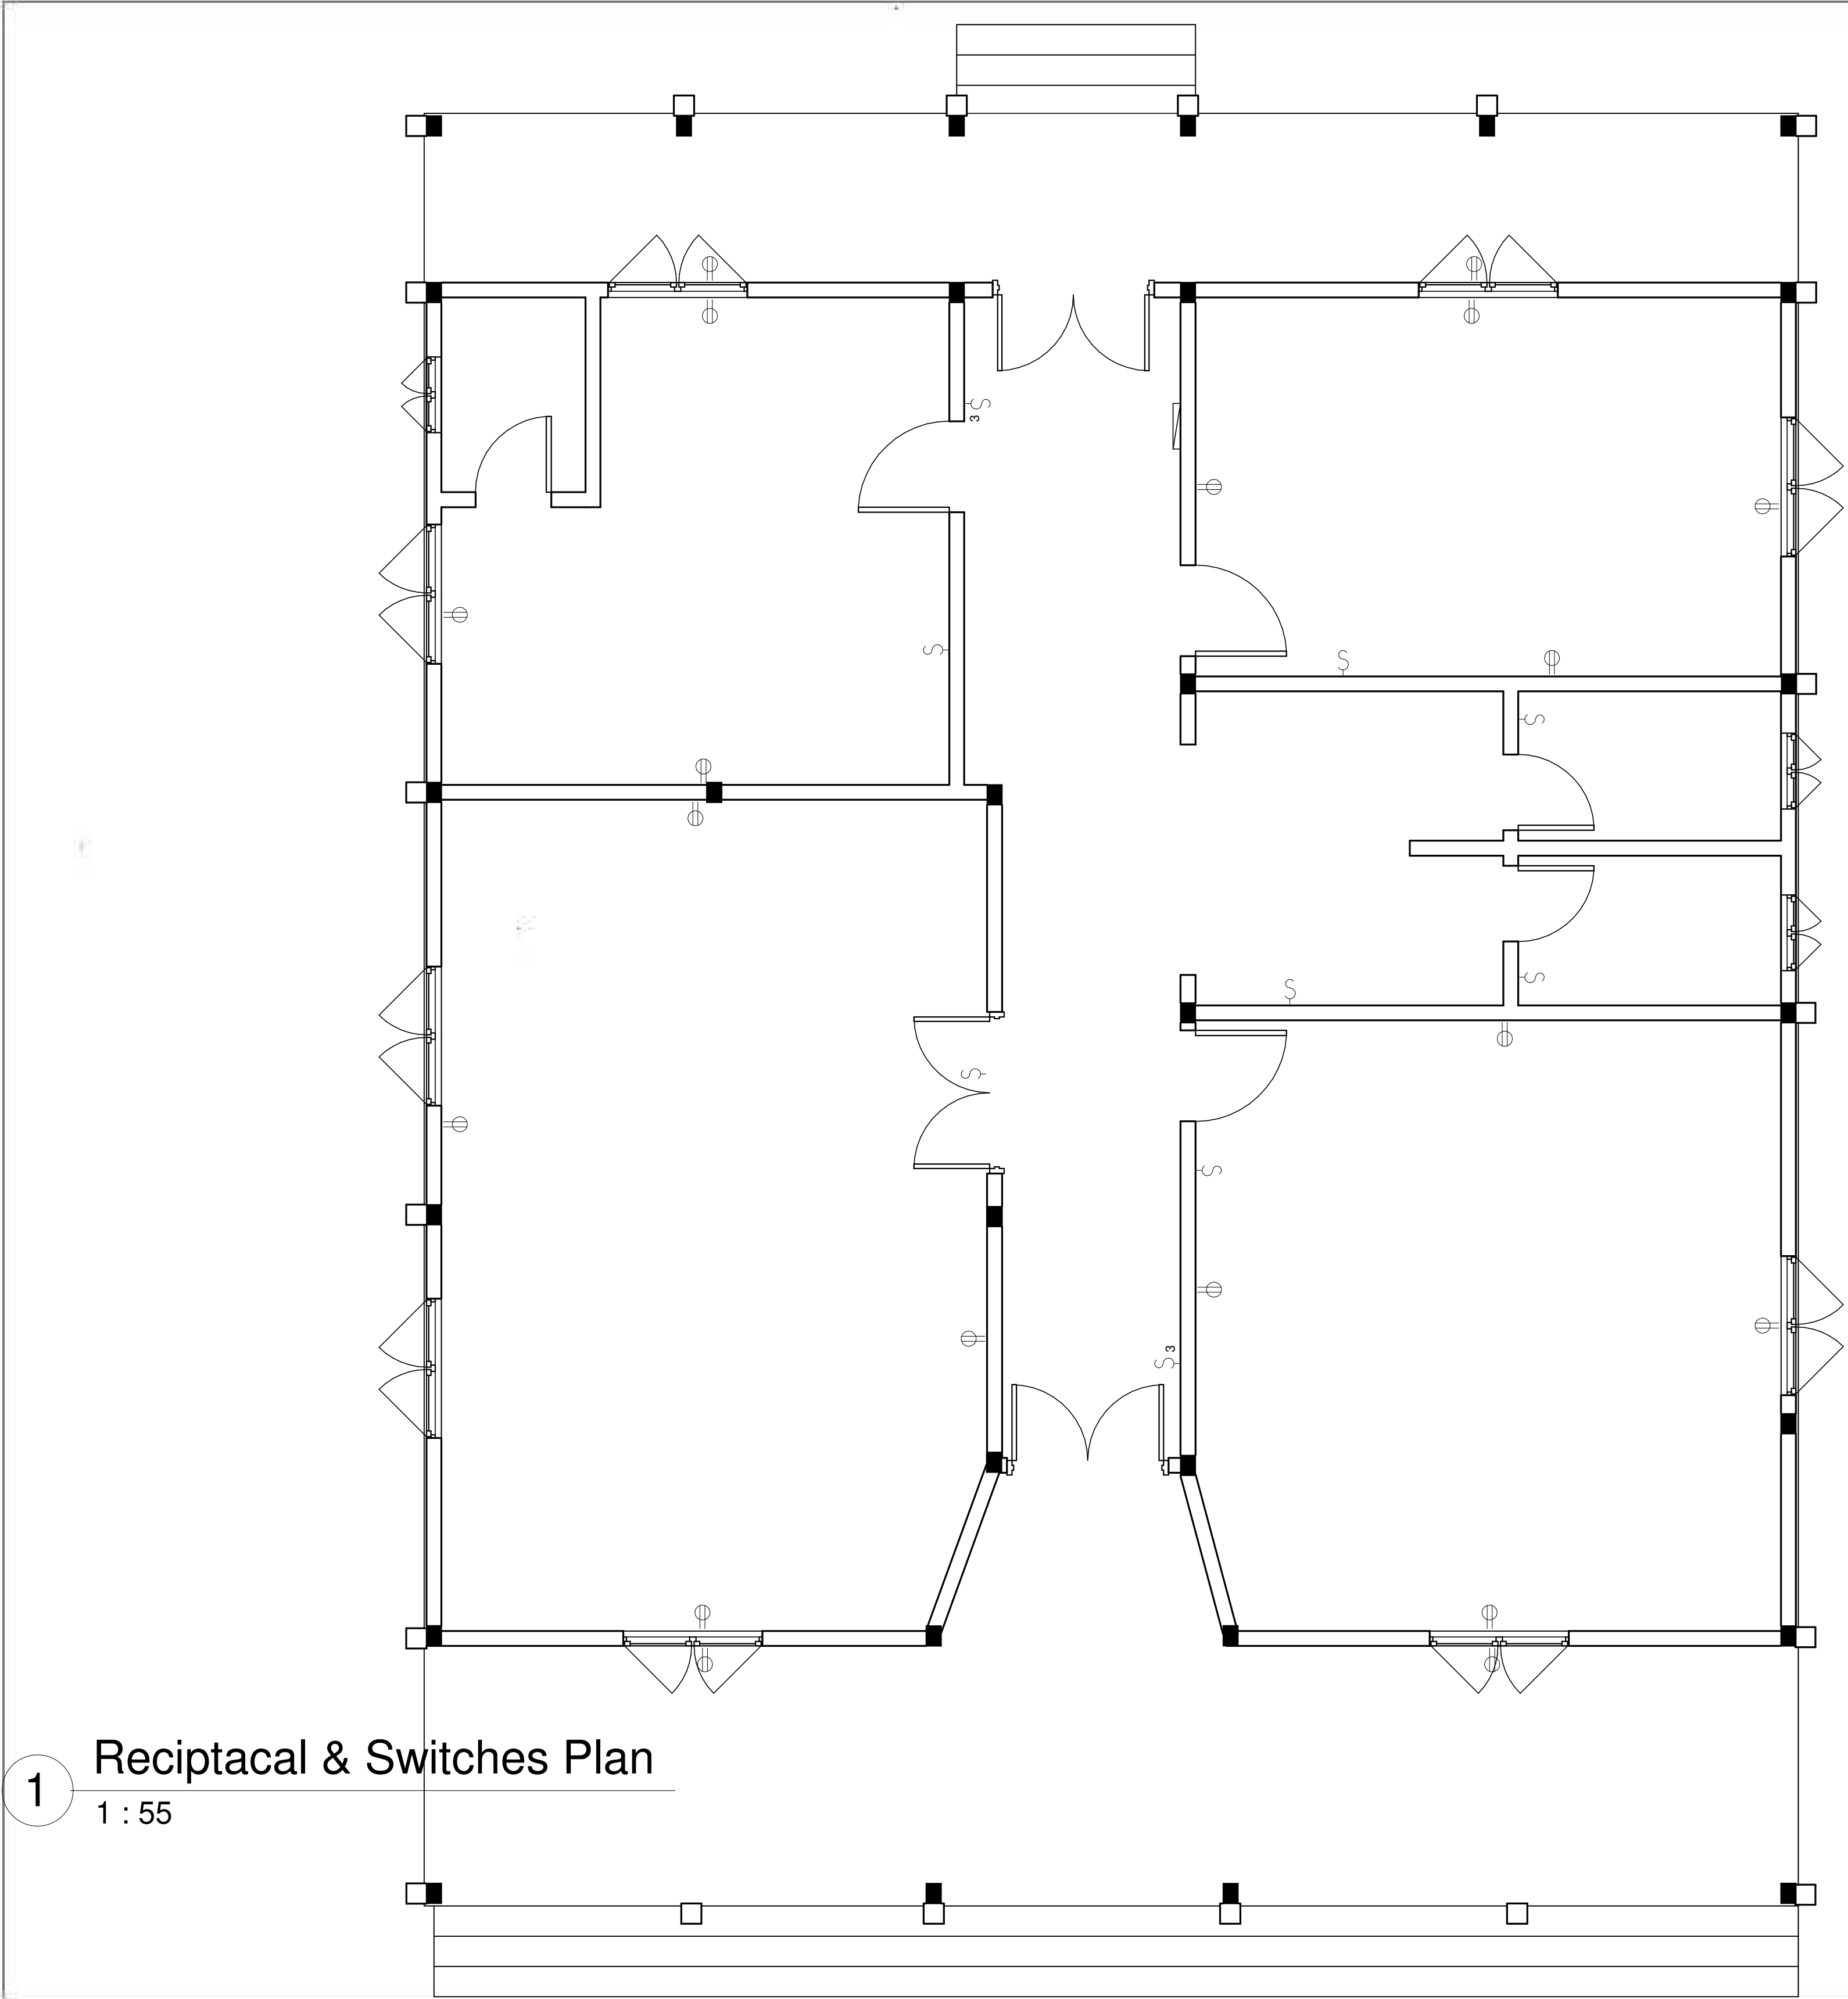


Reciptacal & Switches Plan
1 : 55






IFC DRAWING	
Owner: Ministry of Mines and Energy	
Project: County Office	
RECEPTICLE&SWITCHS	
Project Number	002
Date	JULY 2026
Drawn By	MME Engineers
Checked By	
E102	
Scale	

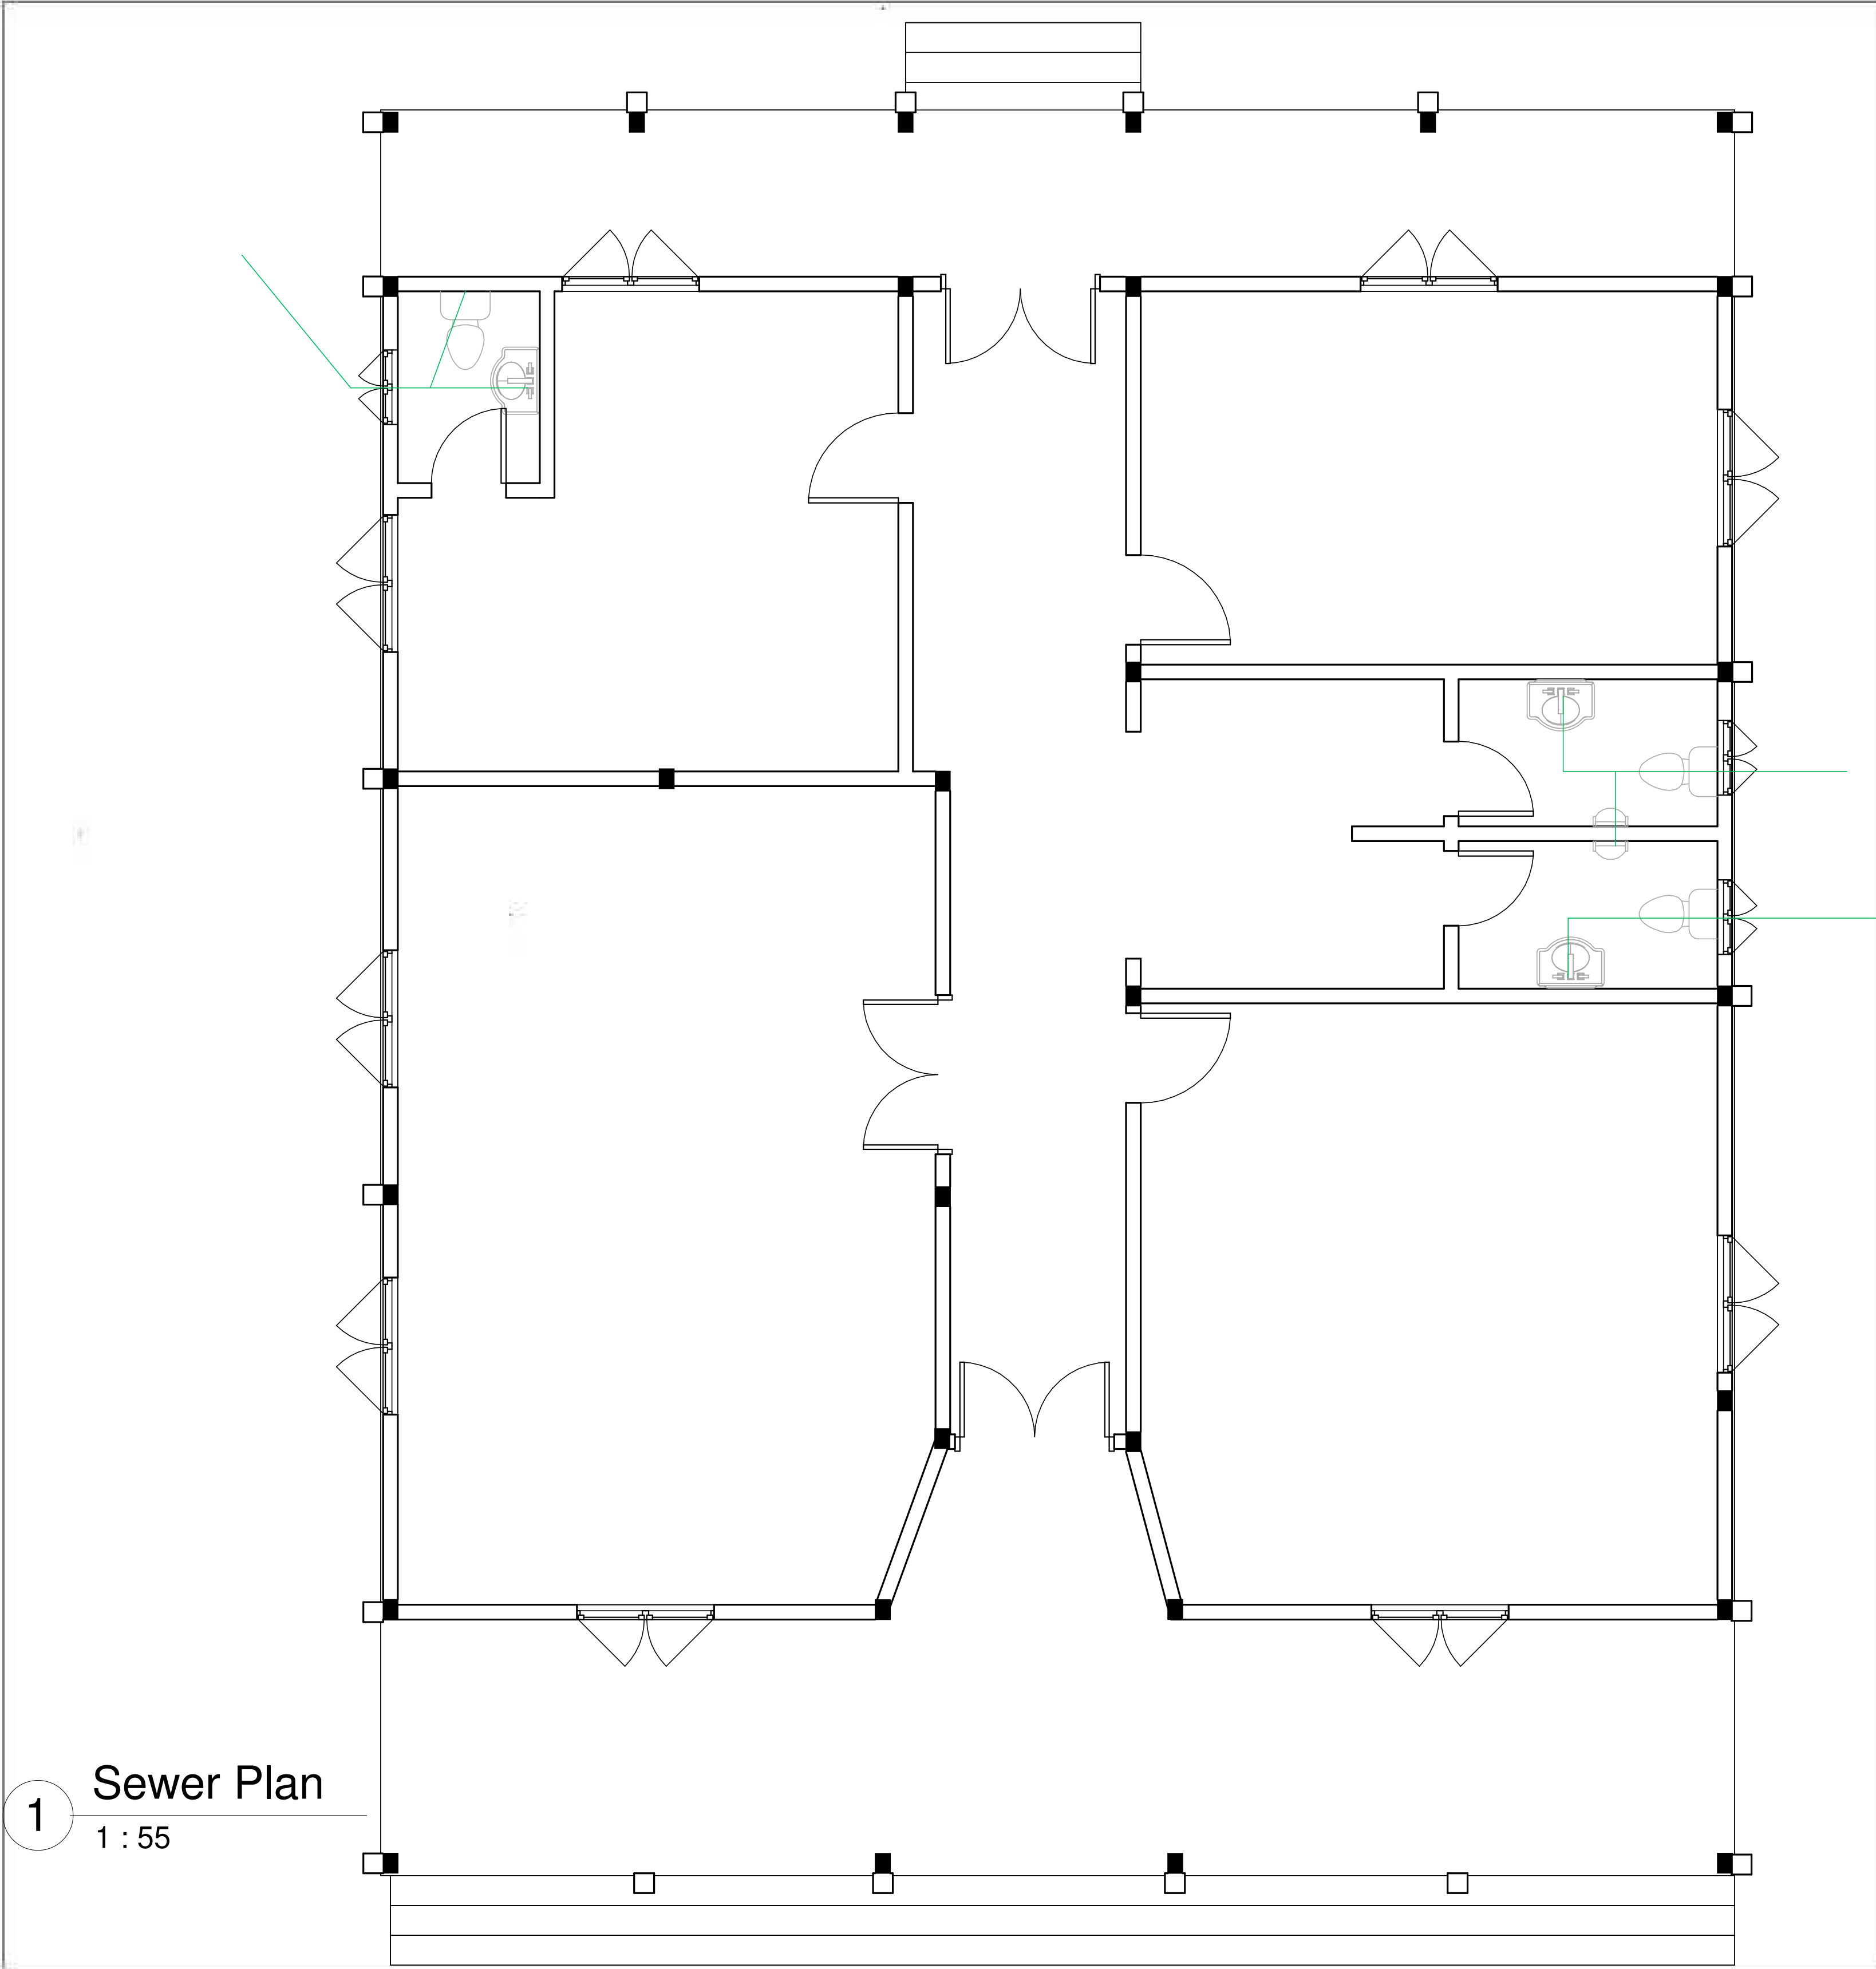

IFC DRAWING	
Owner: Ministry of Mines and Energy	
Project: County Office	
SEWER PLAN	
Project Number	002
Date	JULY 2026
Drawn By	MME Engineers
Checked By	
P101	
Scale	

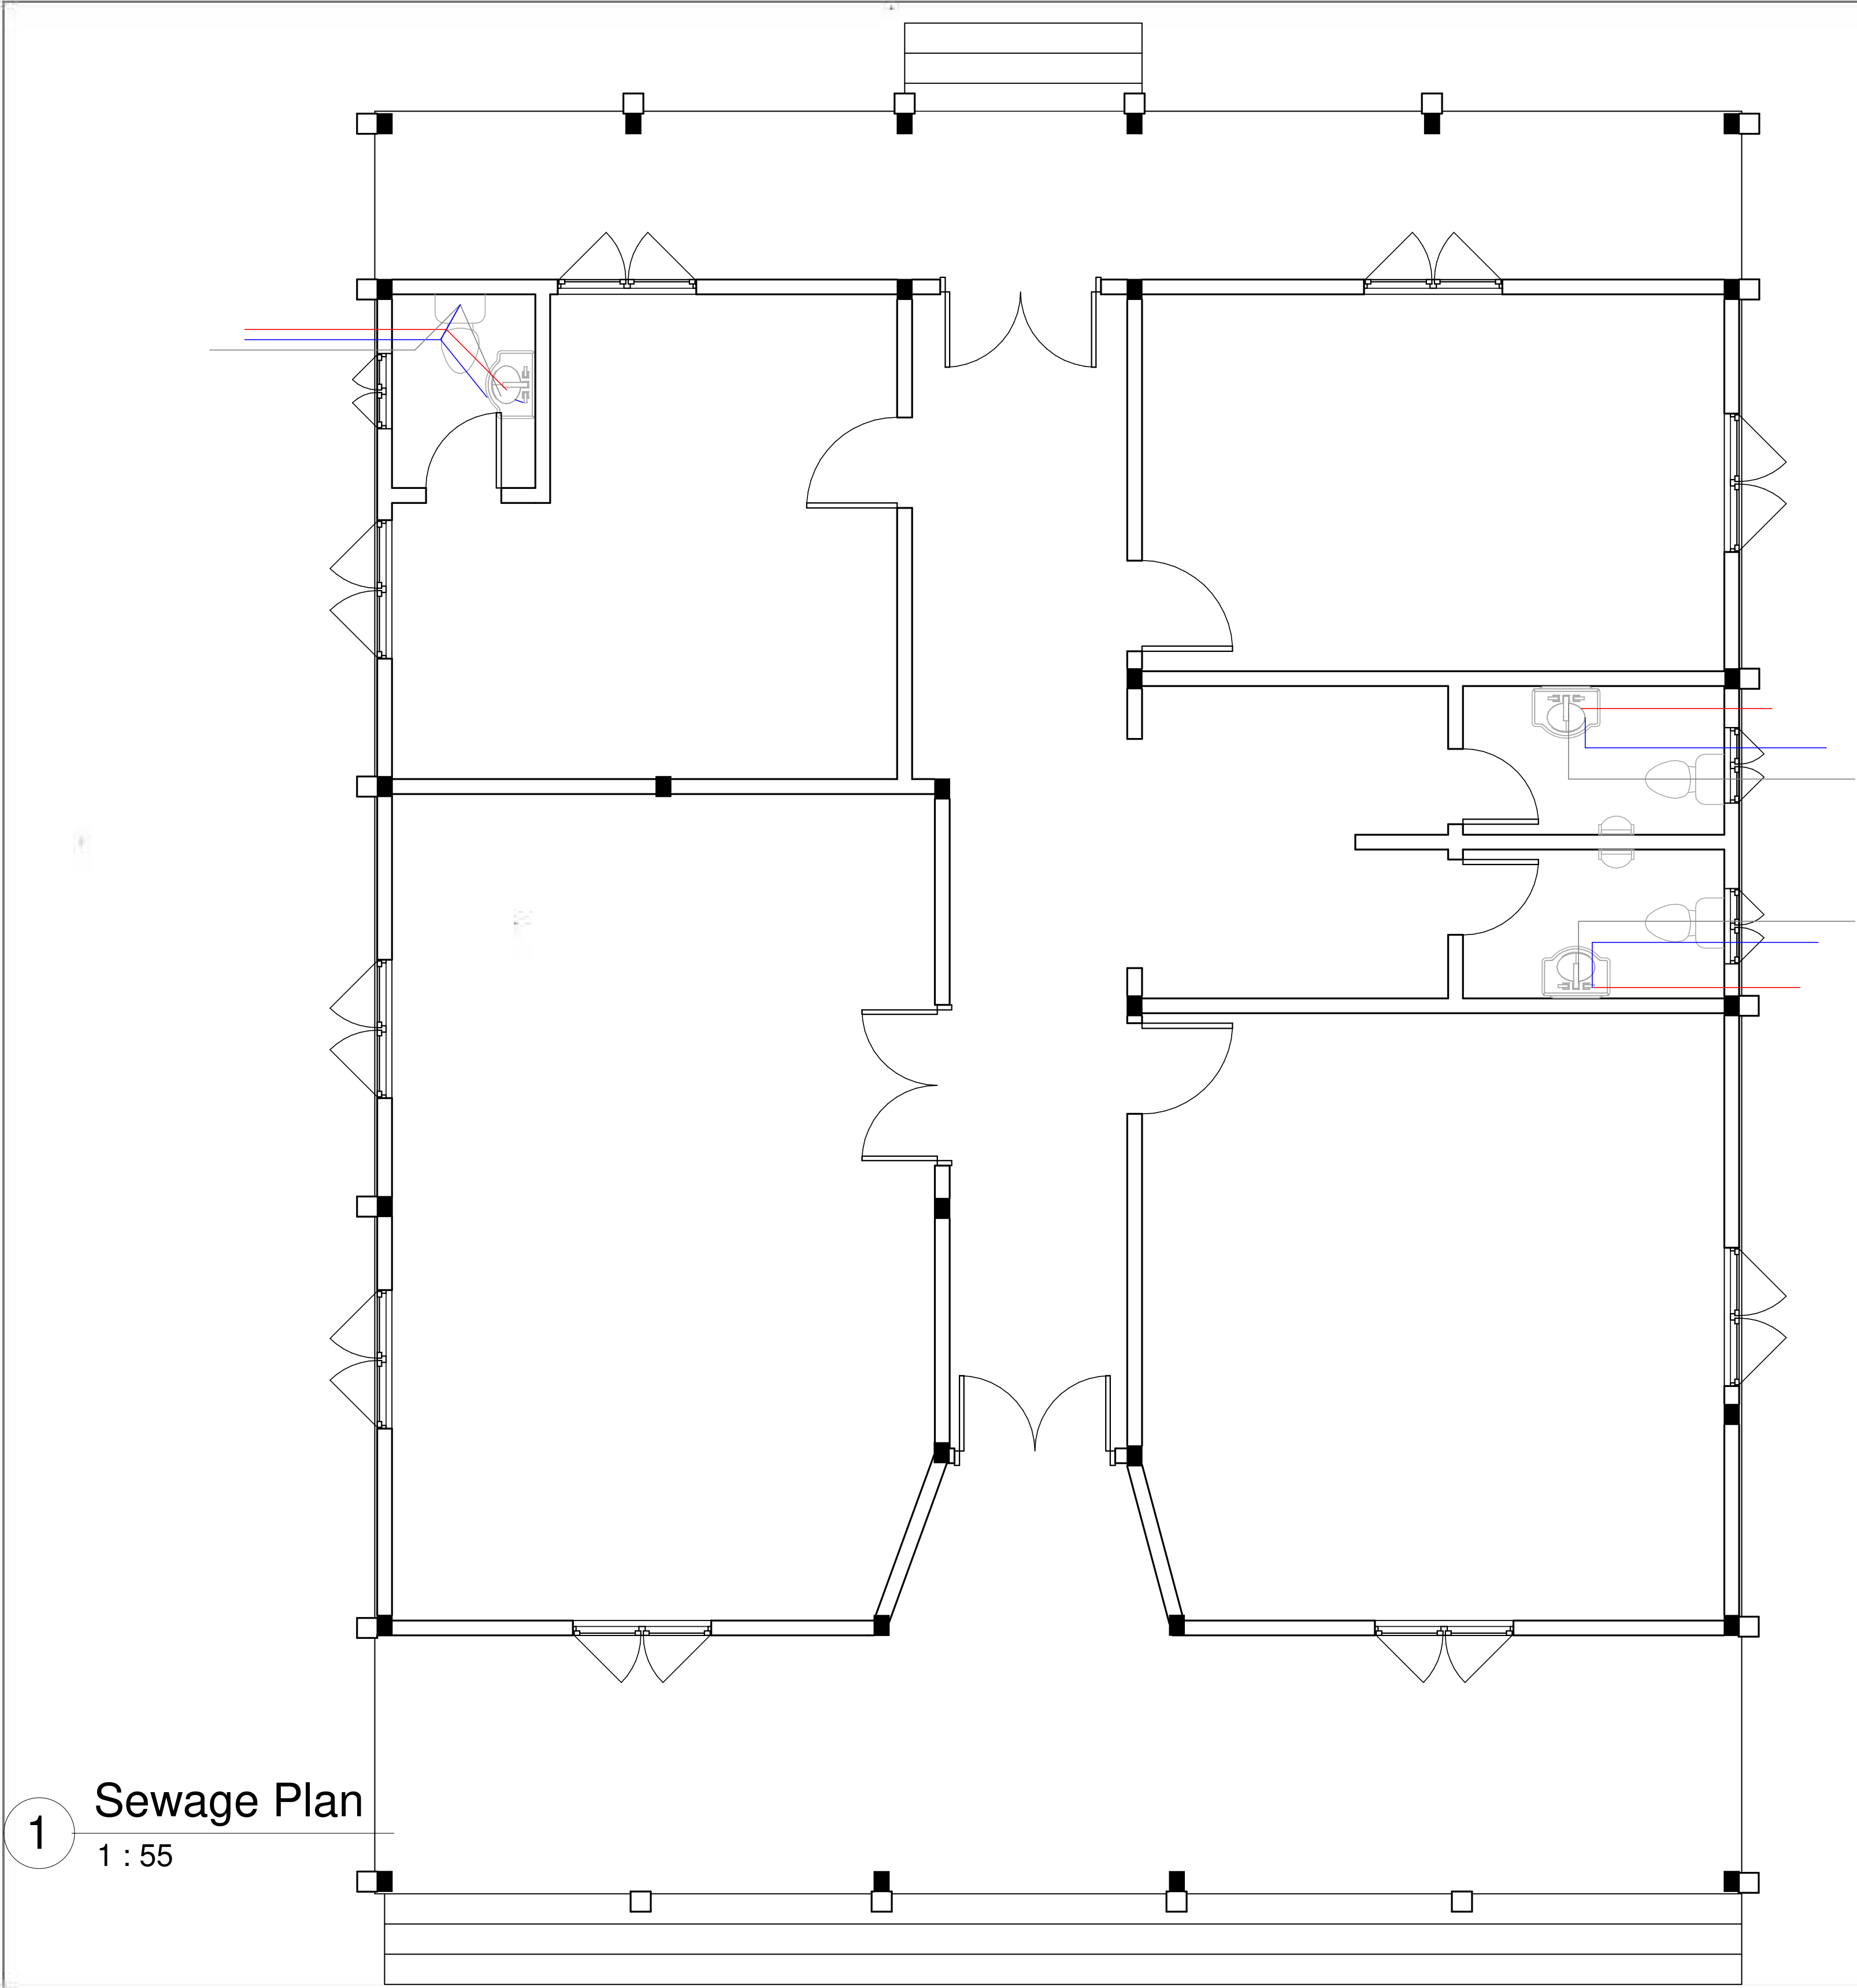

IFC DRAWING	
Owner: Ministry of Mines and Energy	
Project: County Office	
SEWAGE PLAN	
Project Number	002
Date	JULY 2026
Drawn By	MME Engineers
Checked By	
P102	
Scale	

 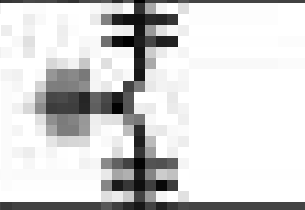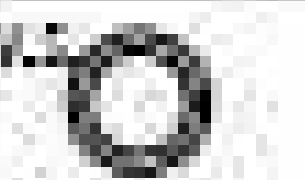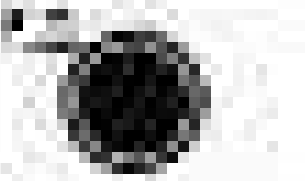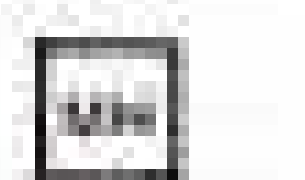SEWAGE DISPOSAL SYMBOLS	
	- 4" Ø PVC SEWAGE LINE
	- 2" Ø PVC SEWAGE LINE
	- 2" / 4" Ø PVC BENT
	- 2" / 4" Ø PVC TEE
	- DIRECTION OF FLOW
	- 2" Ø PVC CLEAN OUT PIPE
	- 2" Ø PVC VENT PIPE
	- 2" Ø PVC FLOOR DRAIN
	- MAN HOLE
	- GREASE TRAP
	- P - TRAP
	- 45° ELBOW JOINT
	SEPTIC TANK
	SOAK-AWAY PIT

IFC DRAWING	
Owner: Ministry of Mines and Energy	
Project: County Office	
PLUMBING DETAILS	
Project Number	002
Date	JULY 2026
Drawn By	MME Engineers
Checked By	
P103	
Scale	