



Project: COUNTY OFFICE COMPLEX
(Approx. 2,664 SF)
For: MINISTRY OF MINES AND ENERGY
Location: CESTOS CITY, RIVER CESS, LIBERIA
Date: AUGUST 15, 2026

TABLE OF CONTENT:

- 1. Foundation Plan
 - 1.1 Foundation Details
 - 1.2 Foundation Tie Beam
- 2. Floor Plan
- 3. Elevations
- 4. Roof Plan
- 5. Ceiling Plan
- 6. Lighting Plan
- 7. Sewer Plumbing Plan



Autodesk Revit

OWNER:

**MINISTRY OF
MINES AND
ENERGY**

PROJECT:

**COUNTY
OFFICE
COMPLEX**

Cover sheet

IFB #:
MME/SBA/NCB/006/26


Date: July 2025

Drawn By: MME ENGR.




Table of Contents

A102 - Floor Plan	2
1.1 A102 - Floor Plan	
A104 - Roof Plan	3
1.1 A104 - Roof Plan	
A105 - Ceiling Plan	4
1.1 A105 - Ceiling Plan	
A106 - Door & Window Schedule	5
1.1 A106 - Door & Window Schedule	
A107 - Elevations	6
1.1 A107 - Elevations	
A108 - Elevations 1	7
1.1 A108 - Elevations 1	
E101 - Lighting Plan	8
1.1 E101 - Lighting Plan	
E102 - Receptacle & Switches Plan	9
1.1 E102 - Receptacle & Switches Plan	
E103 - Electrical Details	10
1.1 E103 - Electrical Details	
P101 - Sewer Plumbing Plan	11
1.1 P101 - Sewer Plumbing Plan	
P102 - Sewage Plumbing Plan	12
1.1 P102 - Sewage Plumbing Plan	
P103 - Plumbing Details	13
1.1 P103 - Plumbing Details	
S101 - Foundation Plan	14
1.1 S101 - Foundation Plan	
S102 - Foundation Tie Beam	15
1.1 S102 - Foundation Tie Beam	
S103 - Foundation Details	16
1.1 S103 - Foundation Details	
S104 - Roof Framing Plan	17
1.1 S104 - Roof Framing Plan	
S105 - Roof Details	18
1.1 S105 - Roof Details	
S106 - Sections Details	19
1.1 S106 - Sections Details	

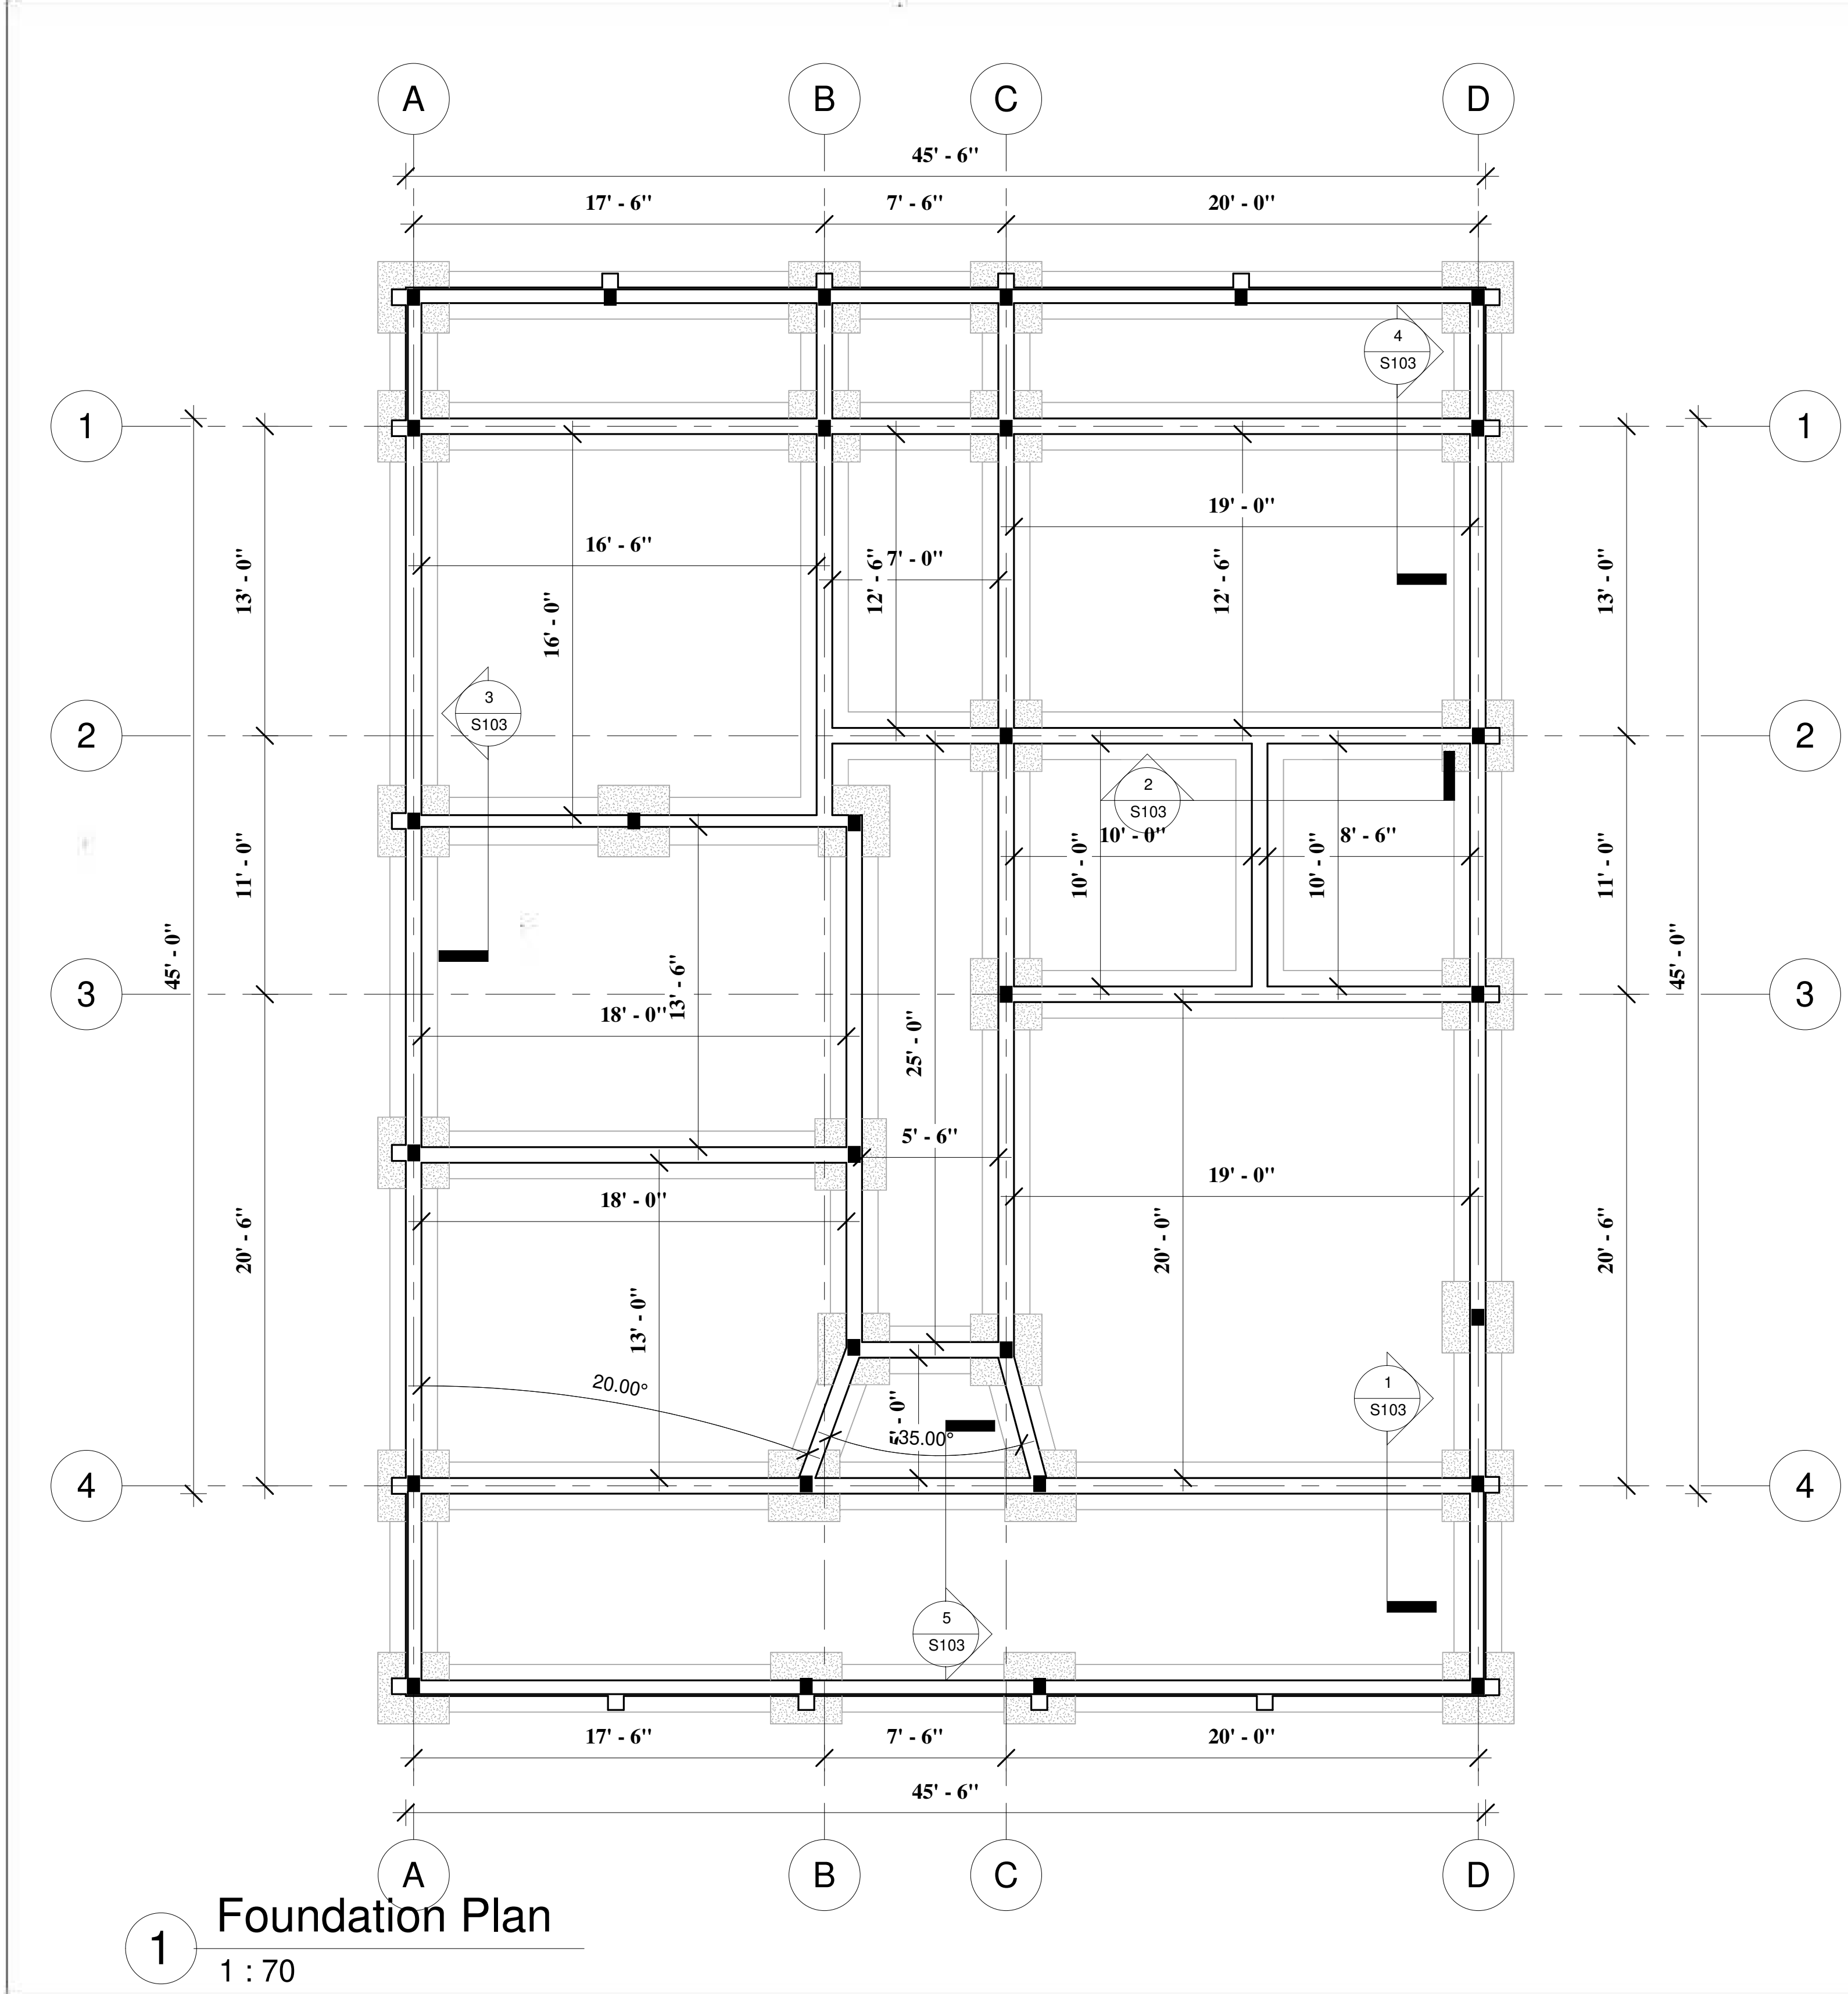

IFC DRAWING	
Owner: Ministry of Mines and Energy	
Project: County Office	
FOUNDATION PLAN	
Project Number	002
Date	JULY 2026
Drawn By	MME Engineers
Checked By	
S101	
Scale	

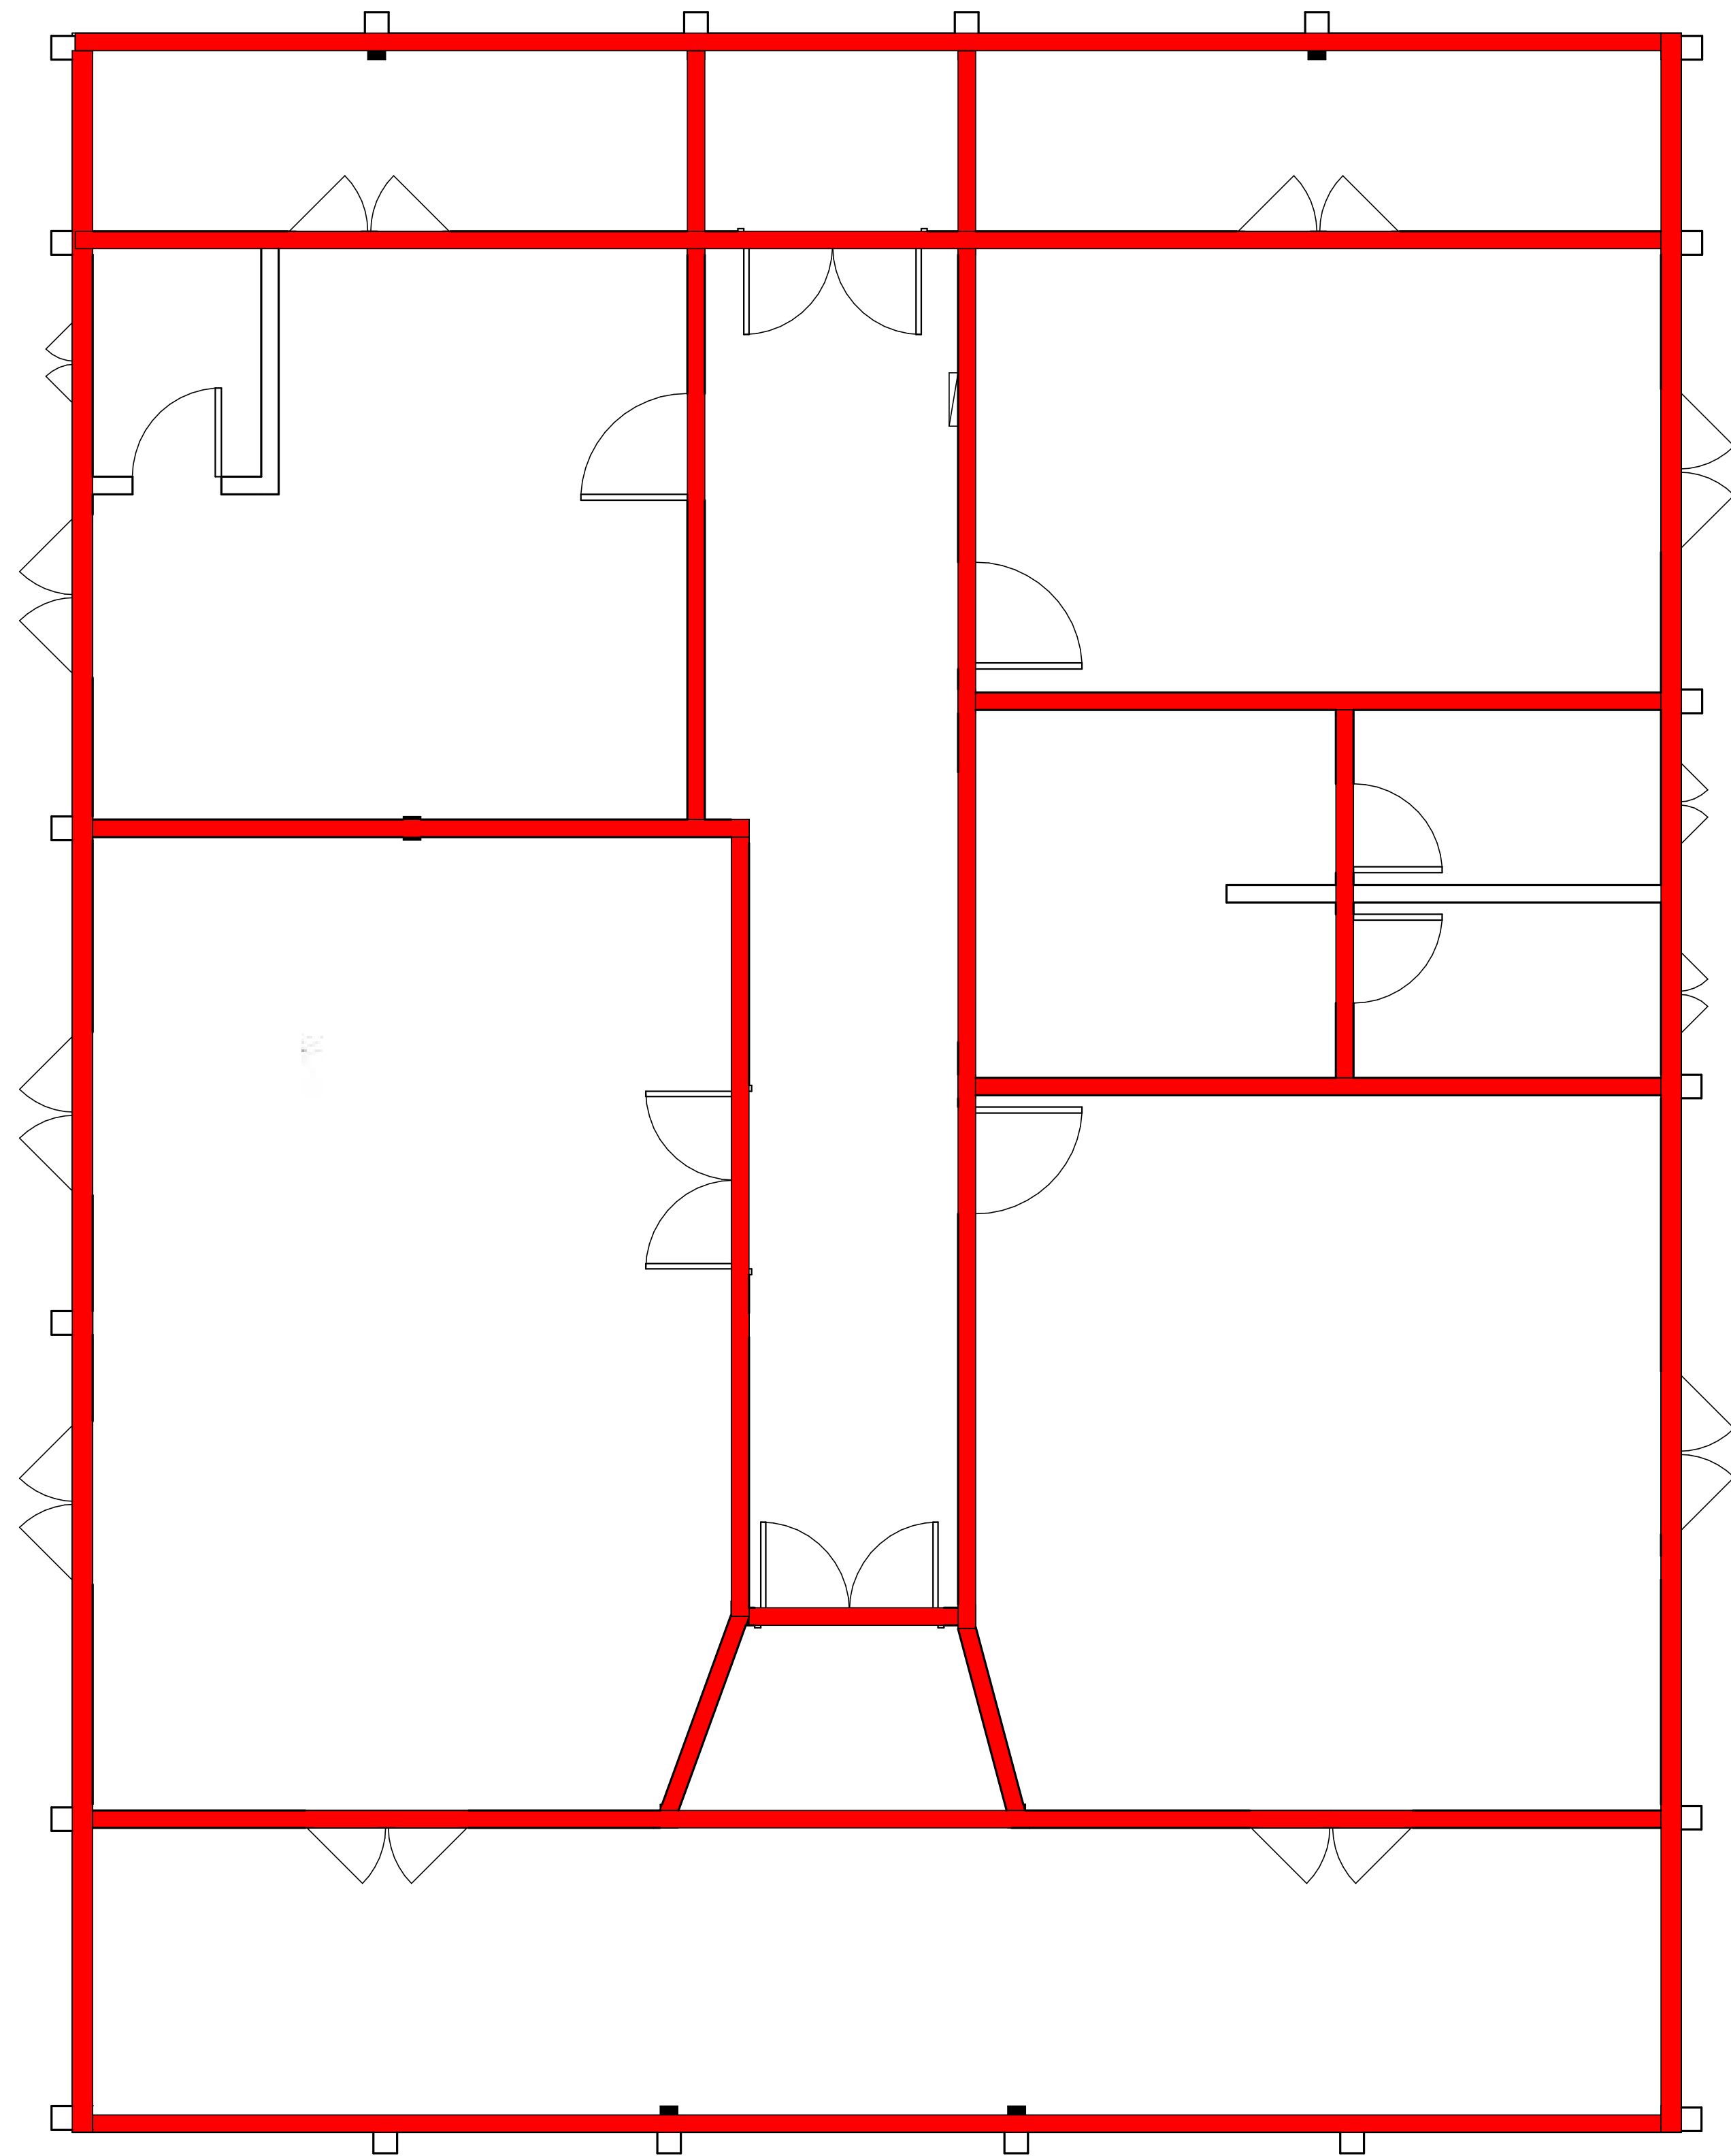

1 Tie Beam
1 : 55

IFC DRAWING

Owner:
Ministry of Mines
and Energy

Project:
County Office

TIE BEAM

Project Number: 002


Date: JULY 2026

Drawn By: MME Engineers

Checked By:

S102

Scale:

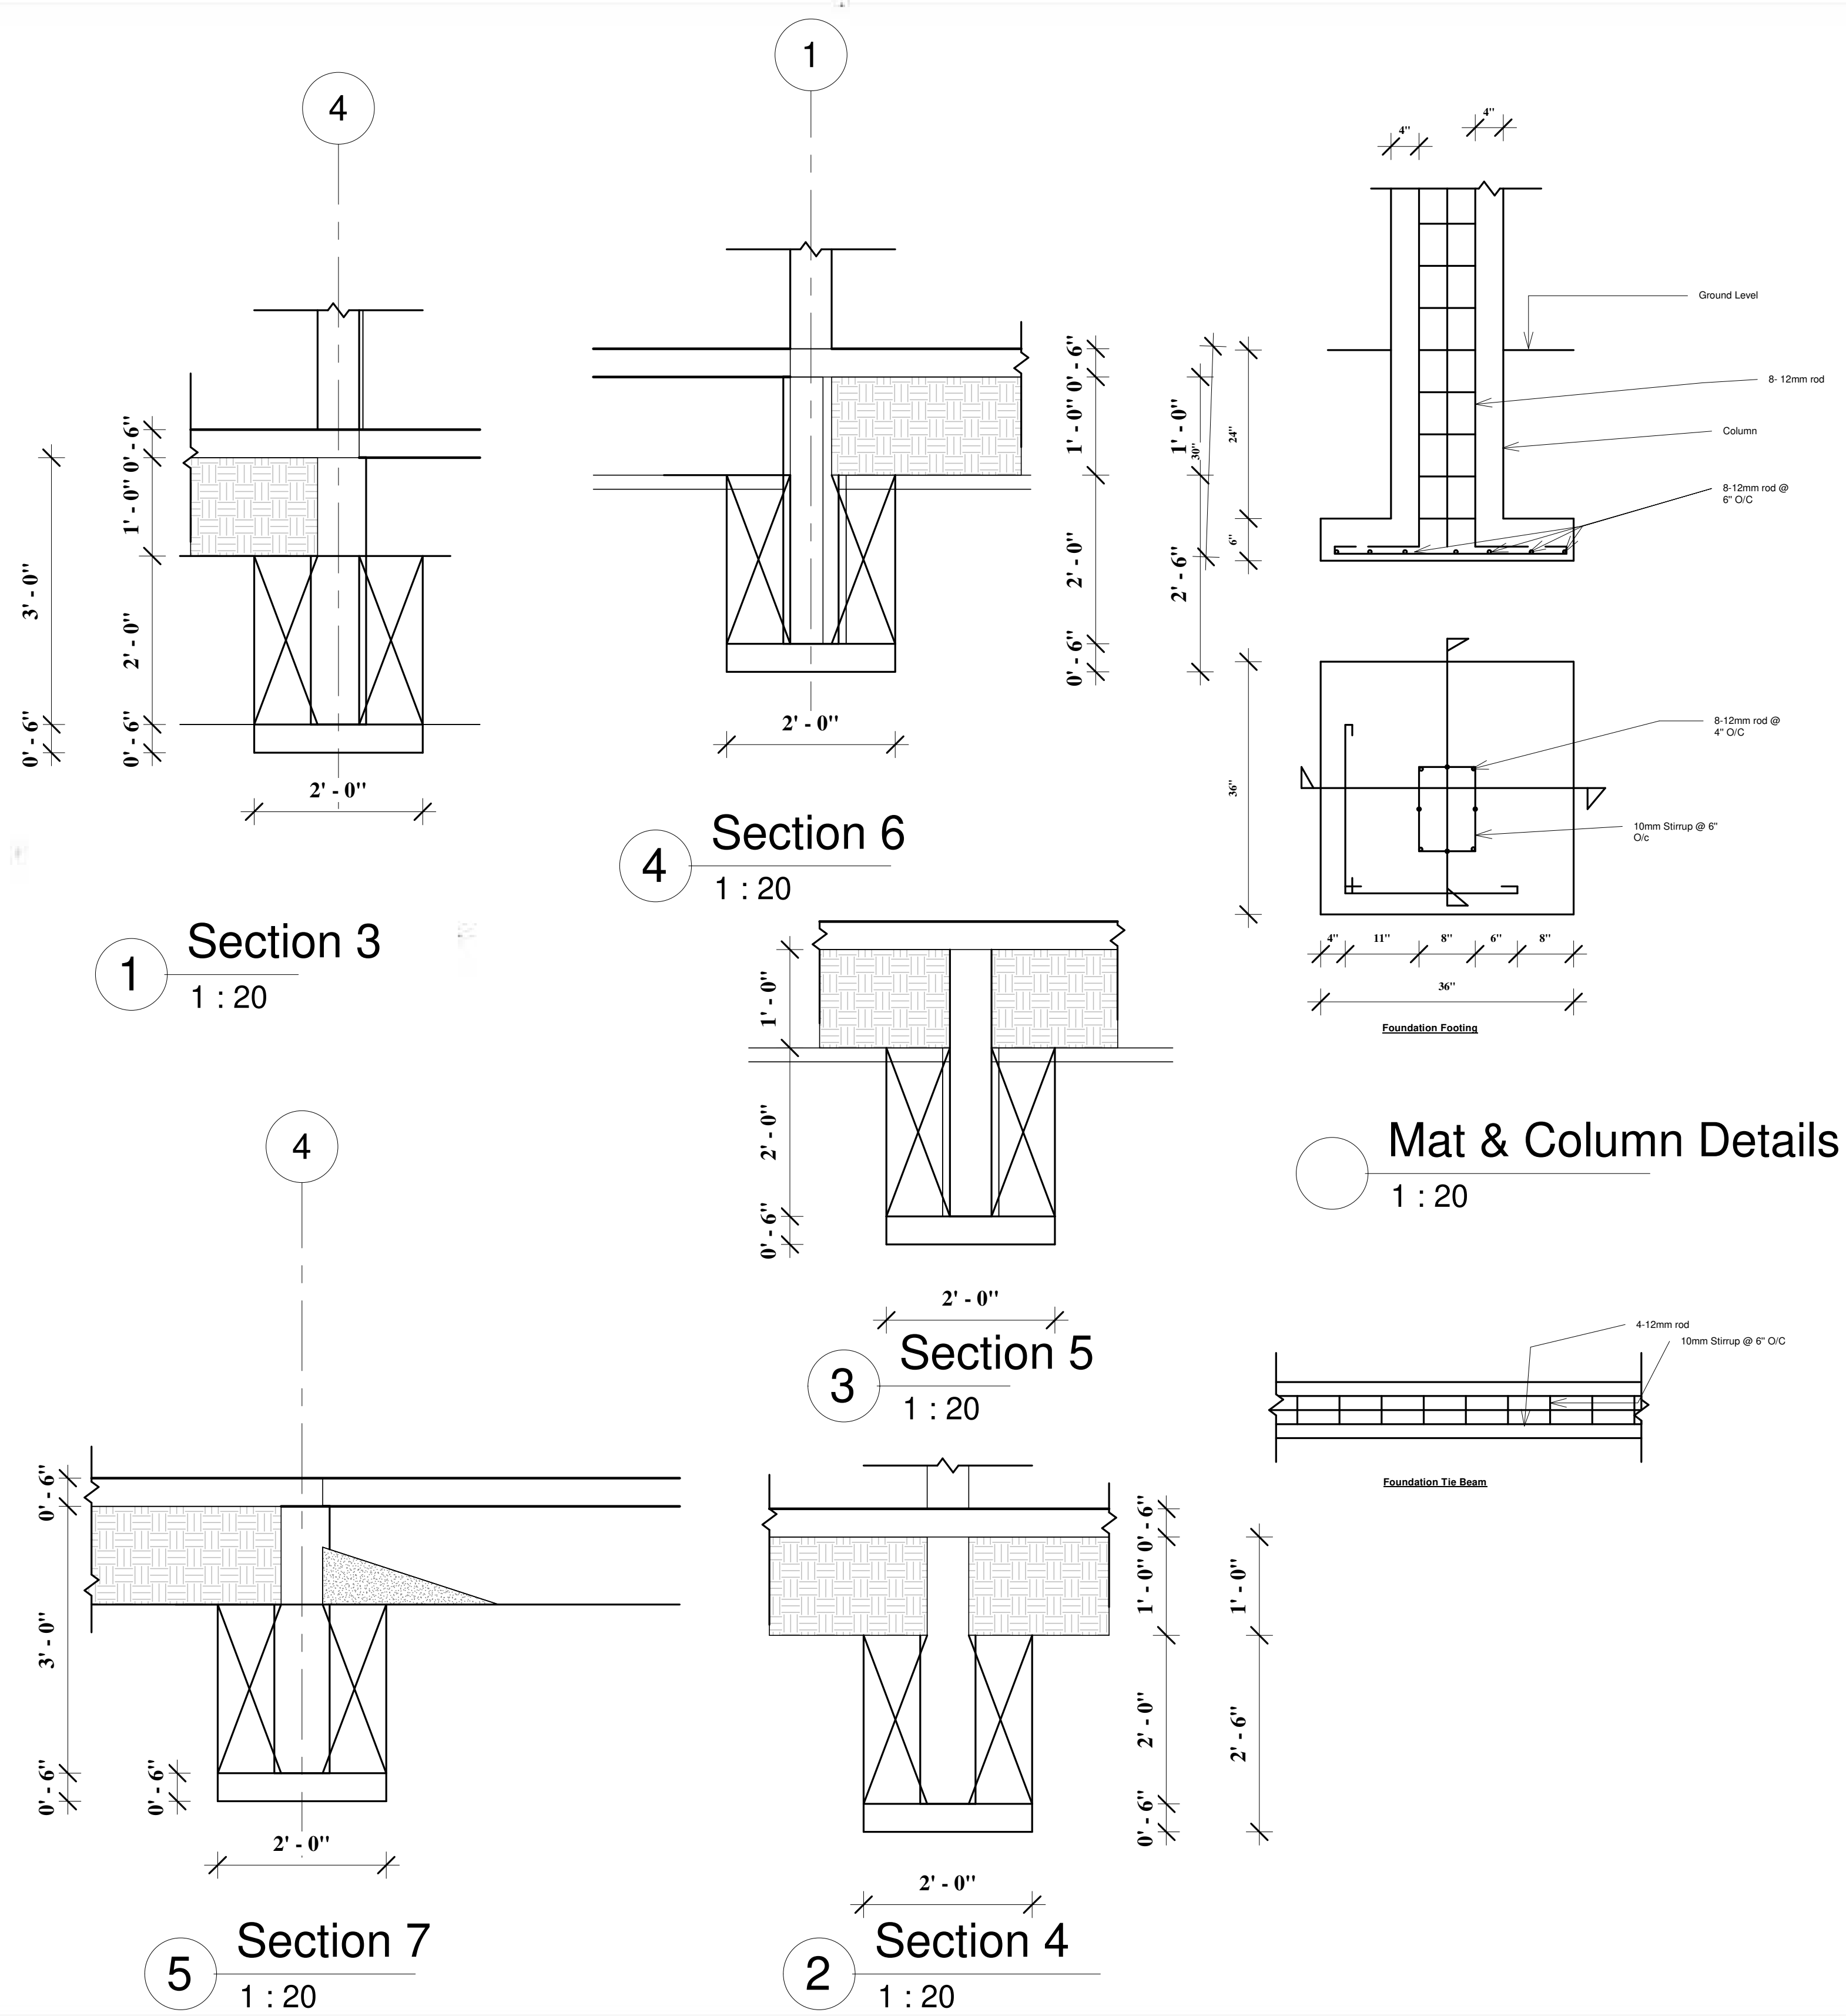


IFC DRAWING

Owner:
Ministry of Mines
and Energy

Project:
County Office

FOUNDATION DETAILS

Project Number	002
Date	JULY 2026
Drawn By	MME Engineers
Checked By	
	S103
Scale	

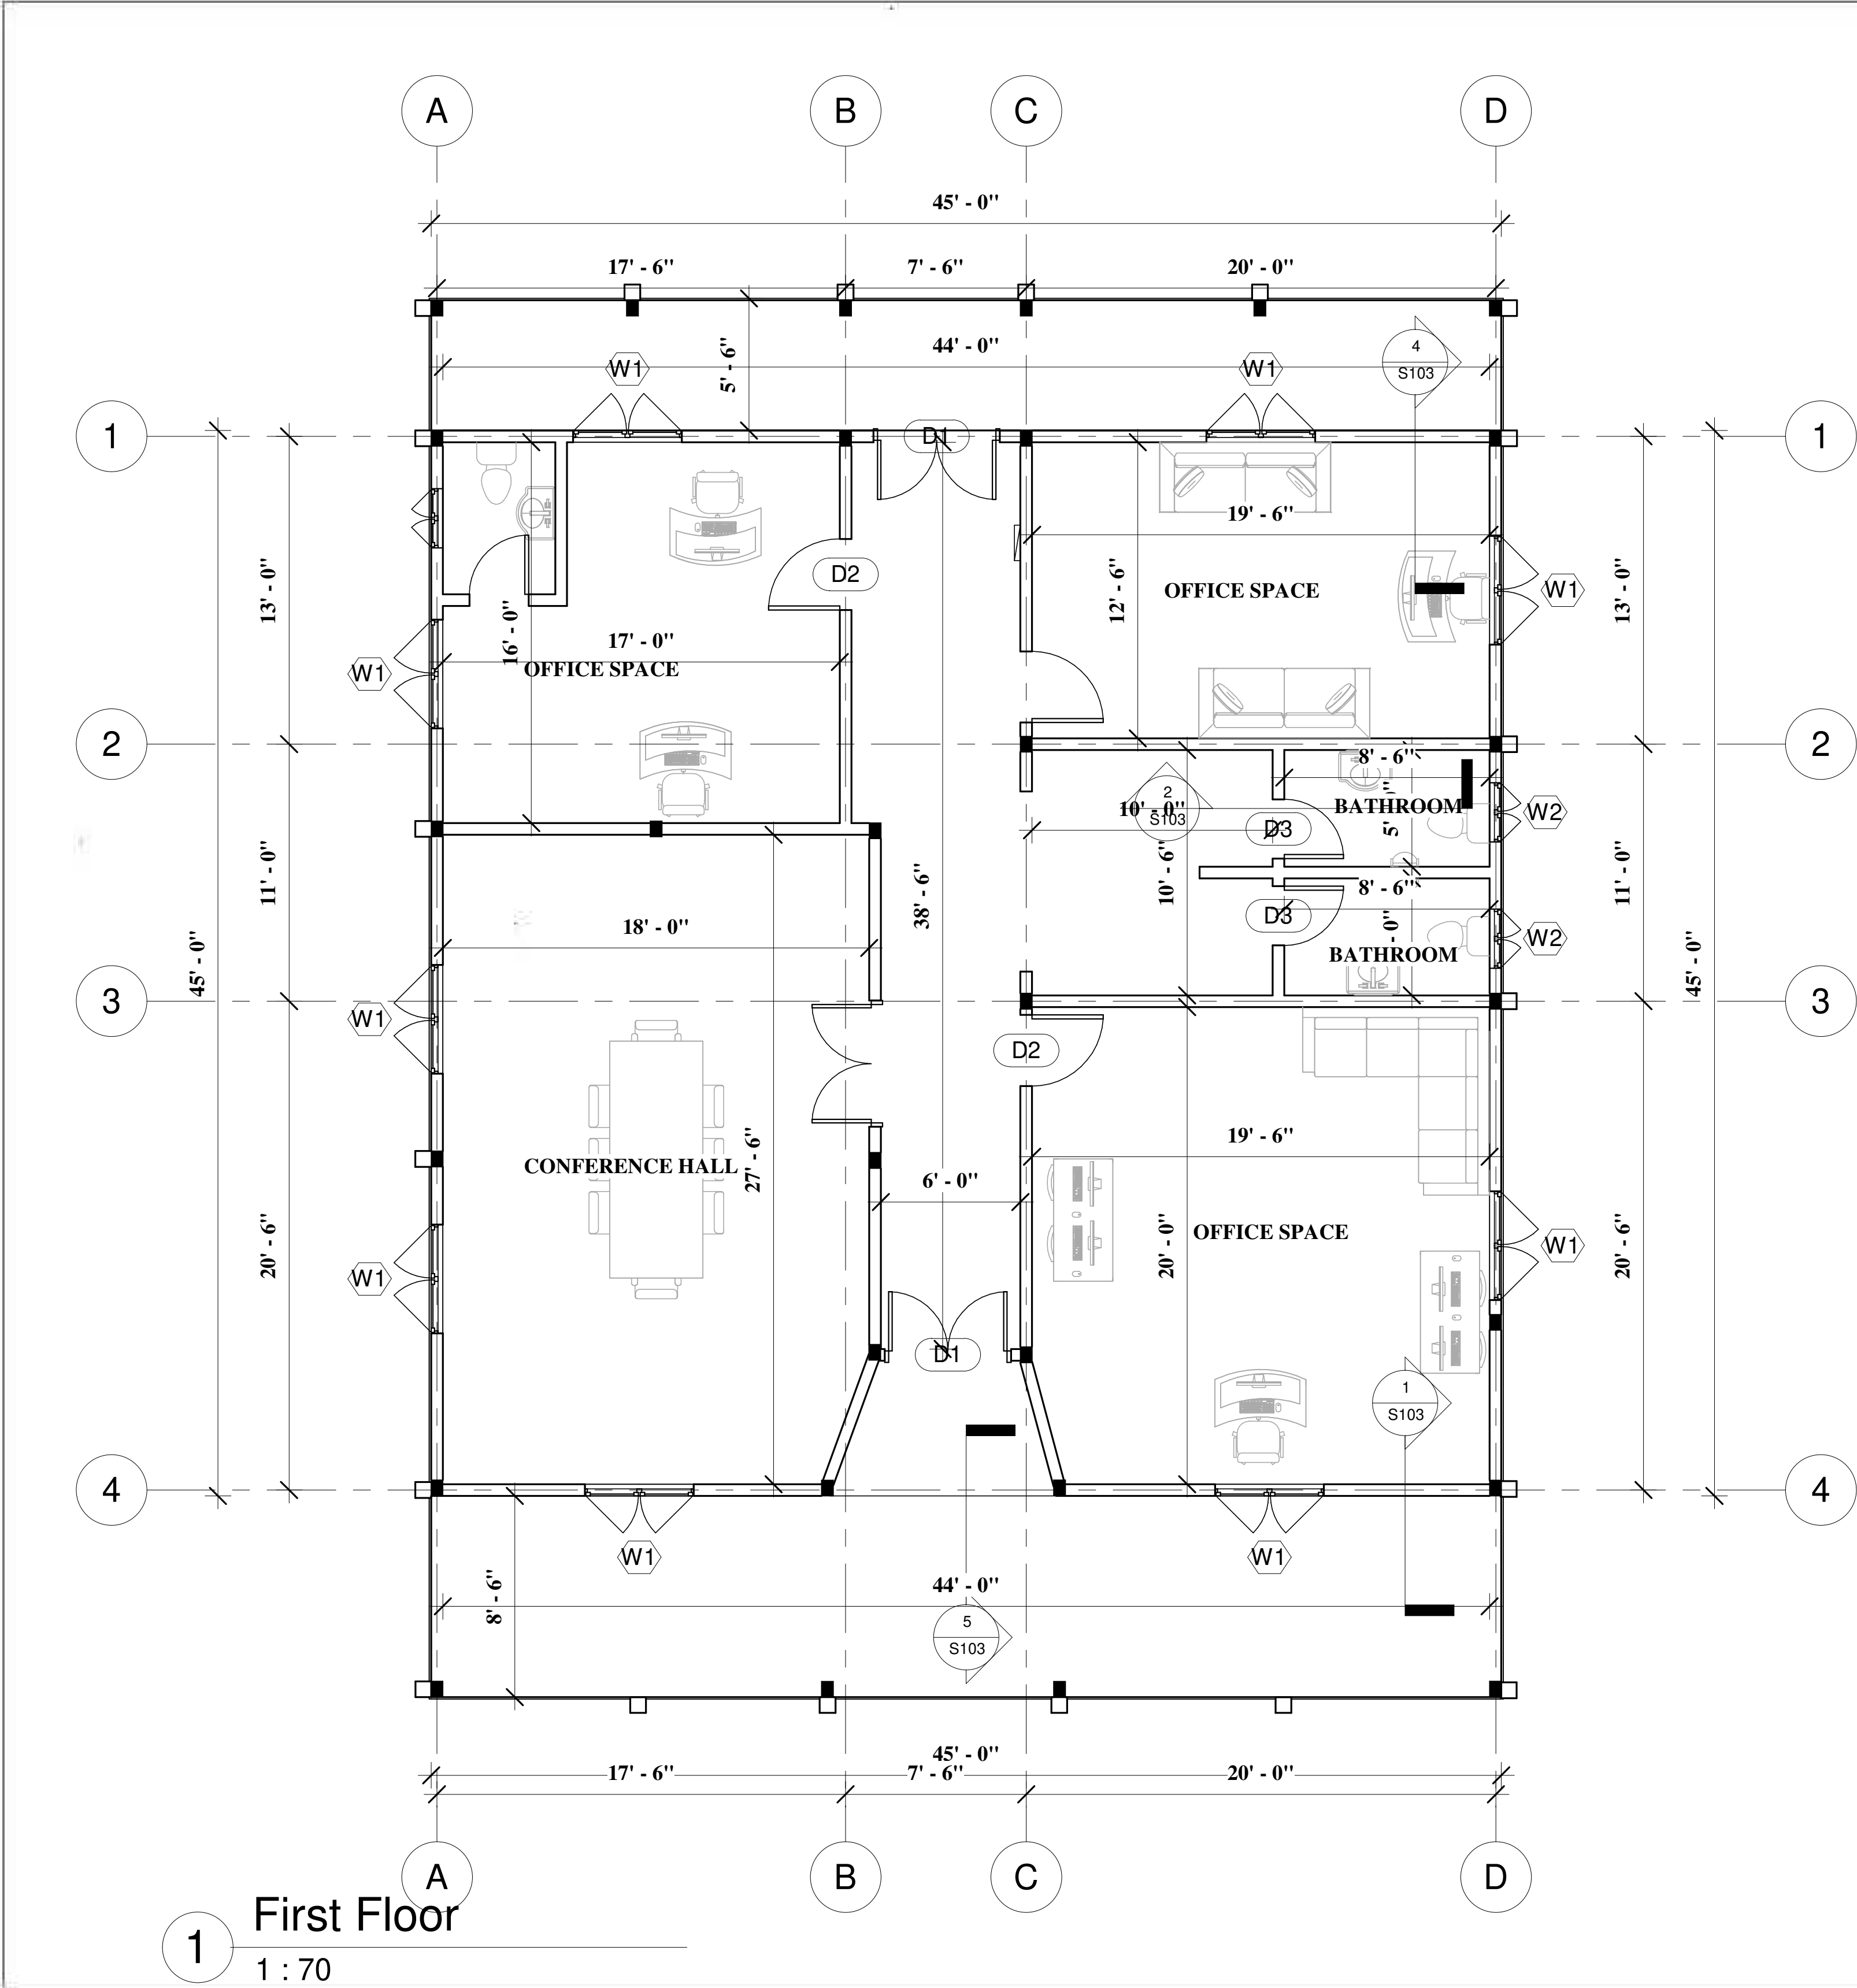

IFC DRAWING

Owner:
Ministry of Mines
and Energy


Project:
County Office

FLOOR PLAN

Project Number	002
Date	JULY 2026
Drawn By	MME Engineers
Checked By	


A102

Scale

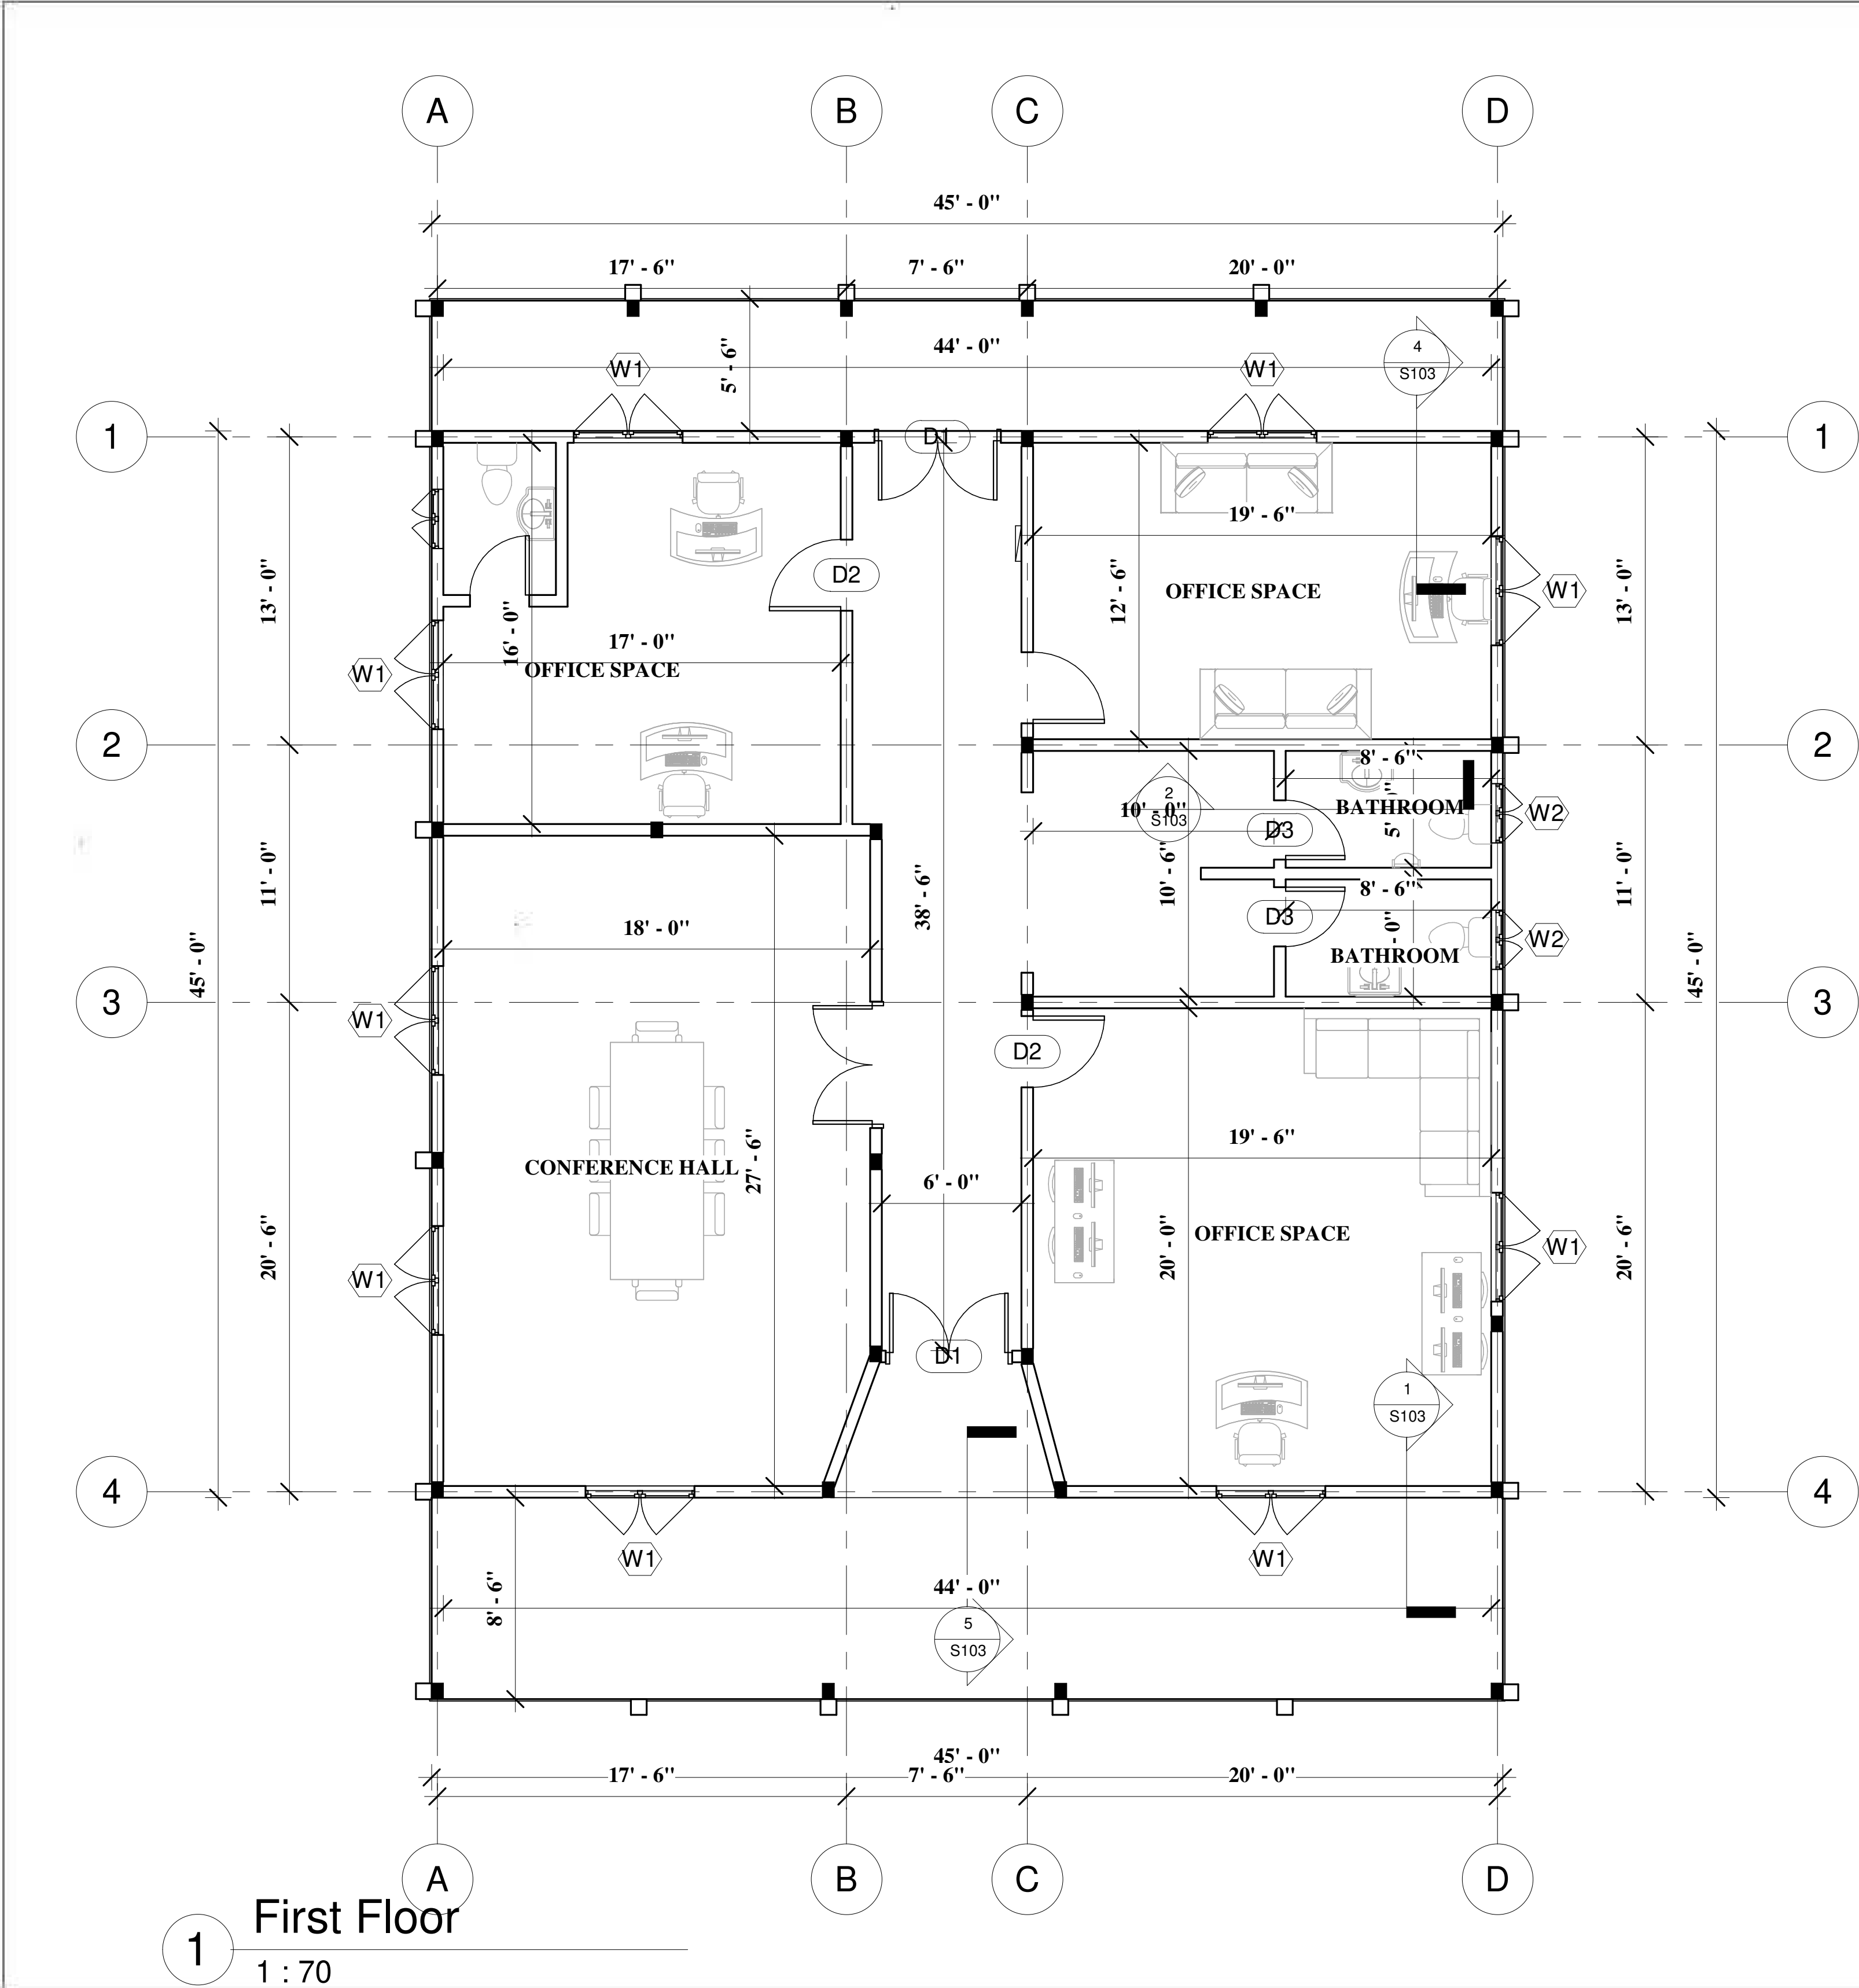

IFC DRAWING	
Owner: Ministry of Mines and Energy	
Project: County Office	
FLOOR PLAN	
Project Number	002
Date	JULY 2026
Drawn By	MME Engineers
Checked By	
A102	
Scale	

1 : 62
1
Roof Plan

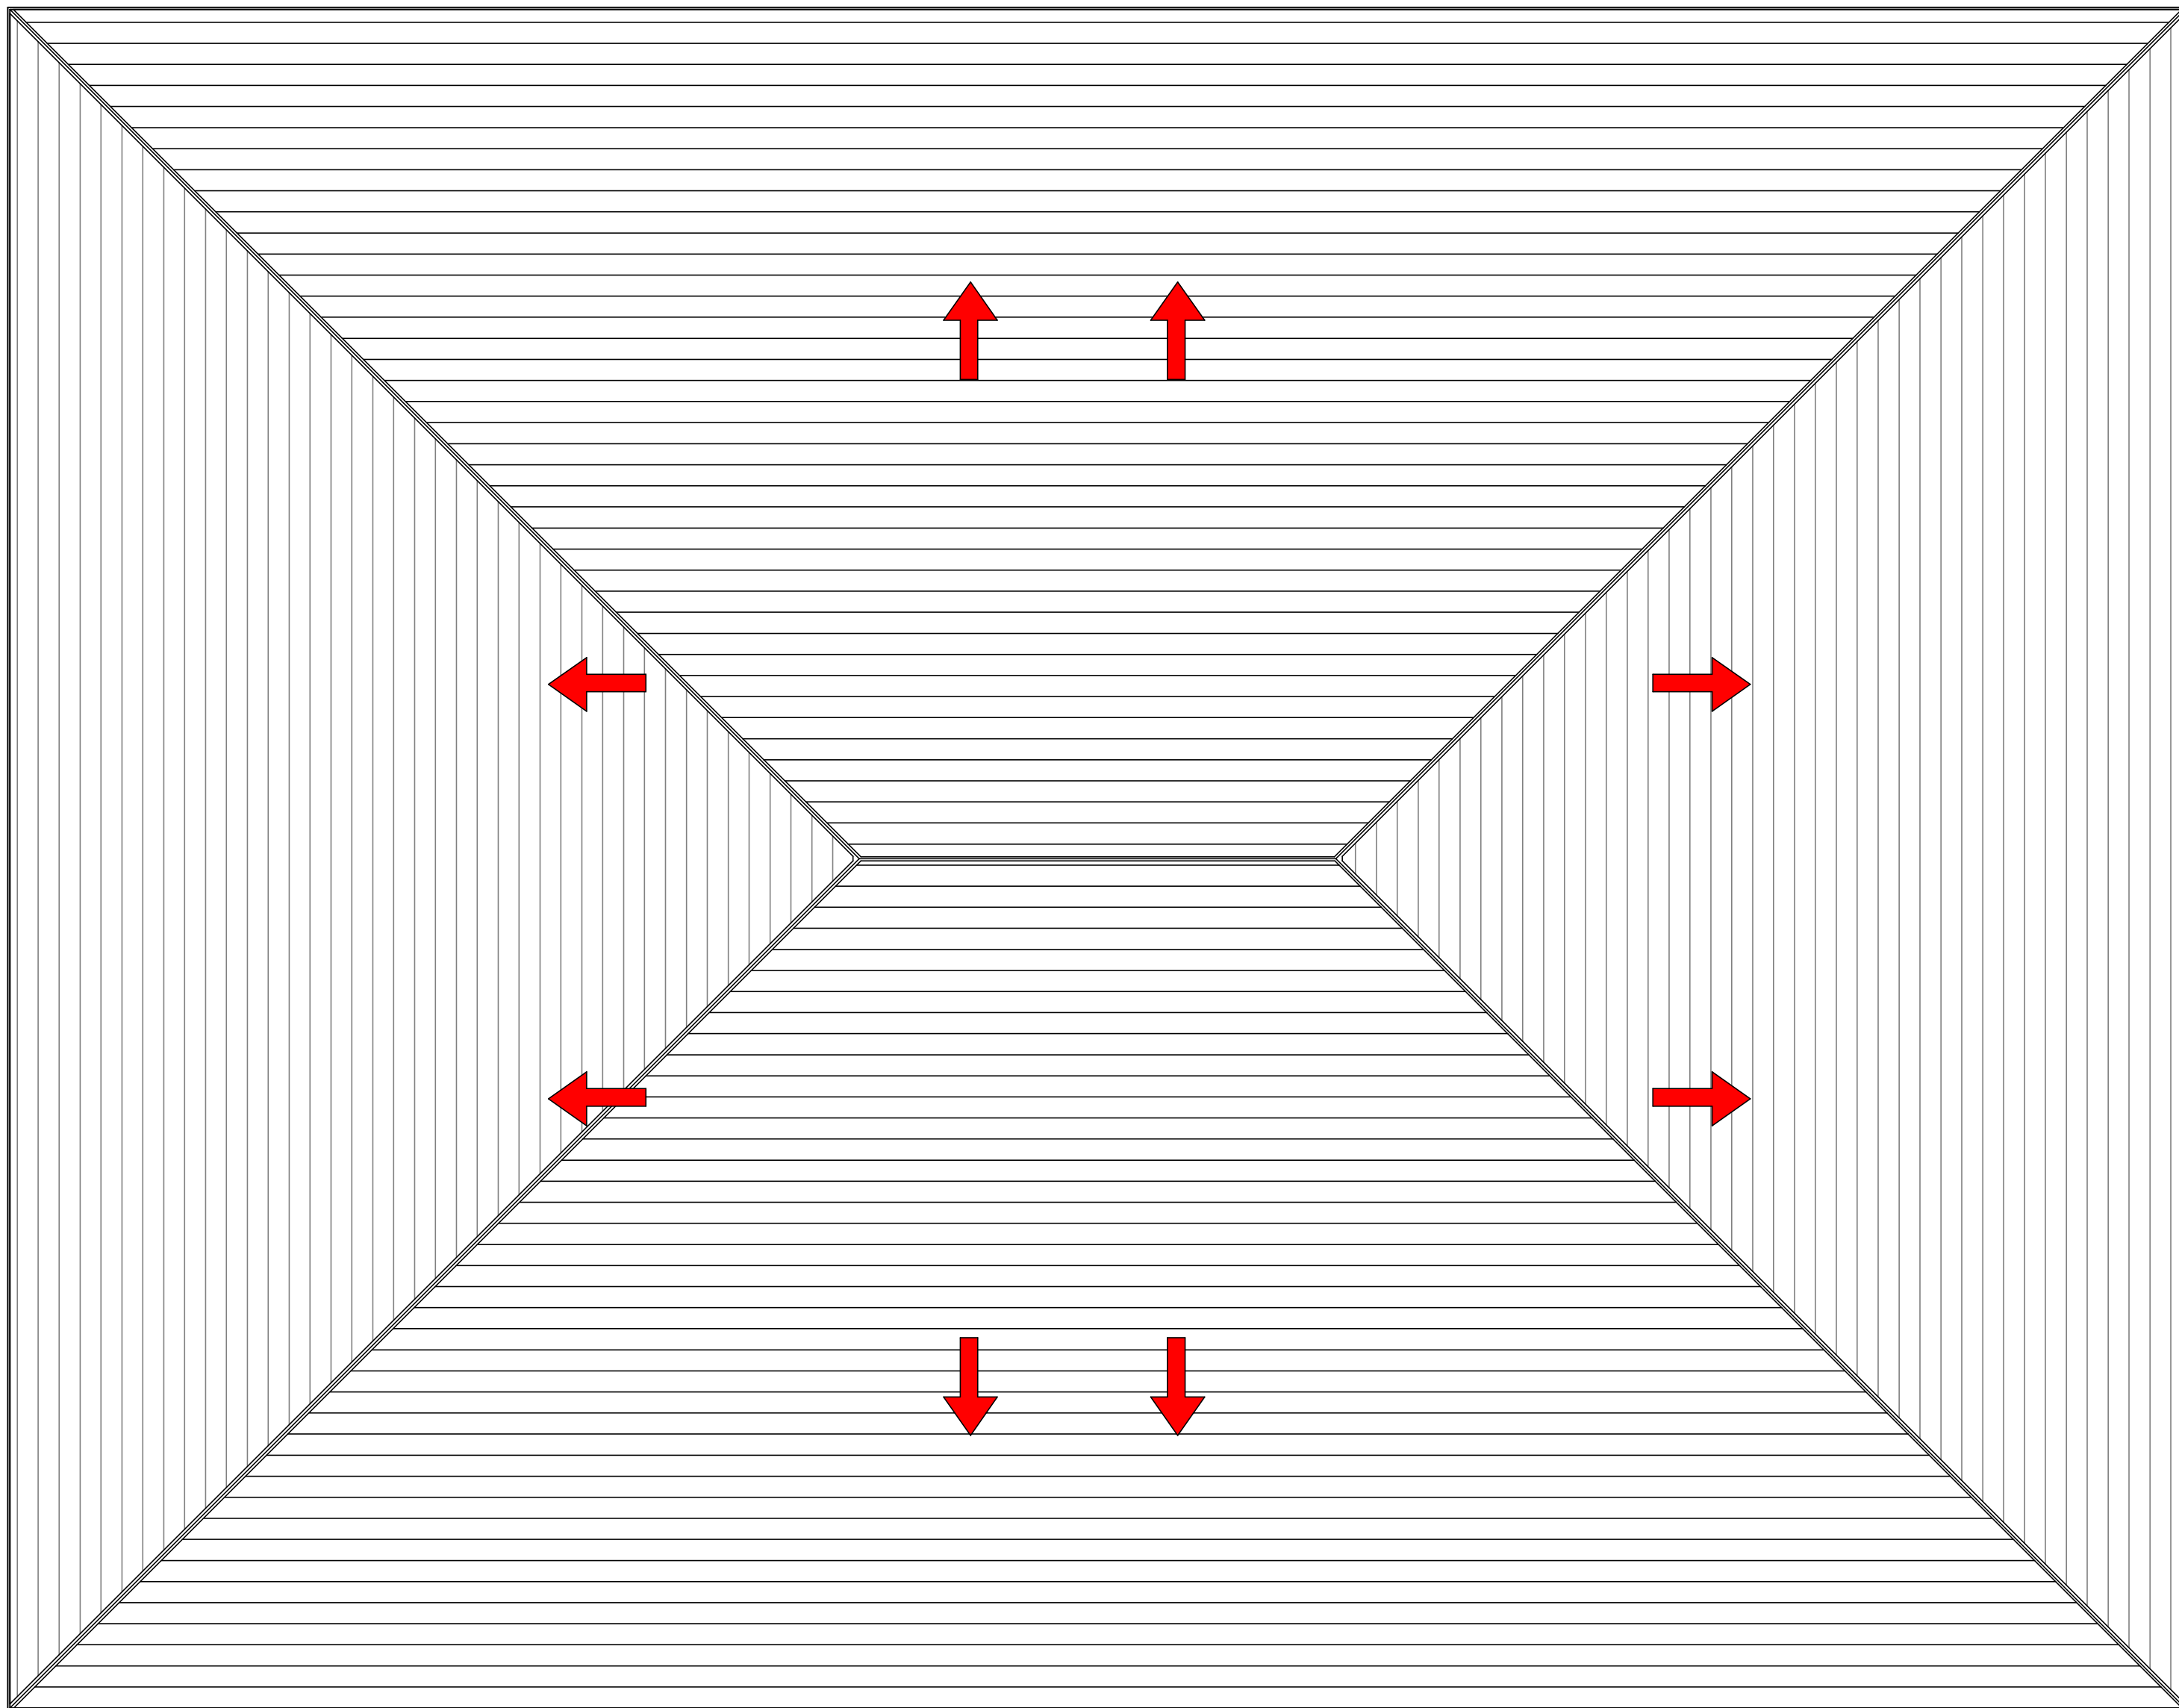

IFC DRAWING

Owner:
Ministry of Mines
and Energy

Project:
County Office

ROOF PLAN

Project Number: 002


Date: JULY 2026

Drawn By: MME Engineers

Checked By:

A104

Scale:

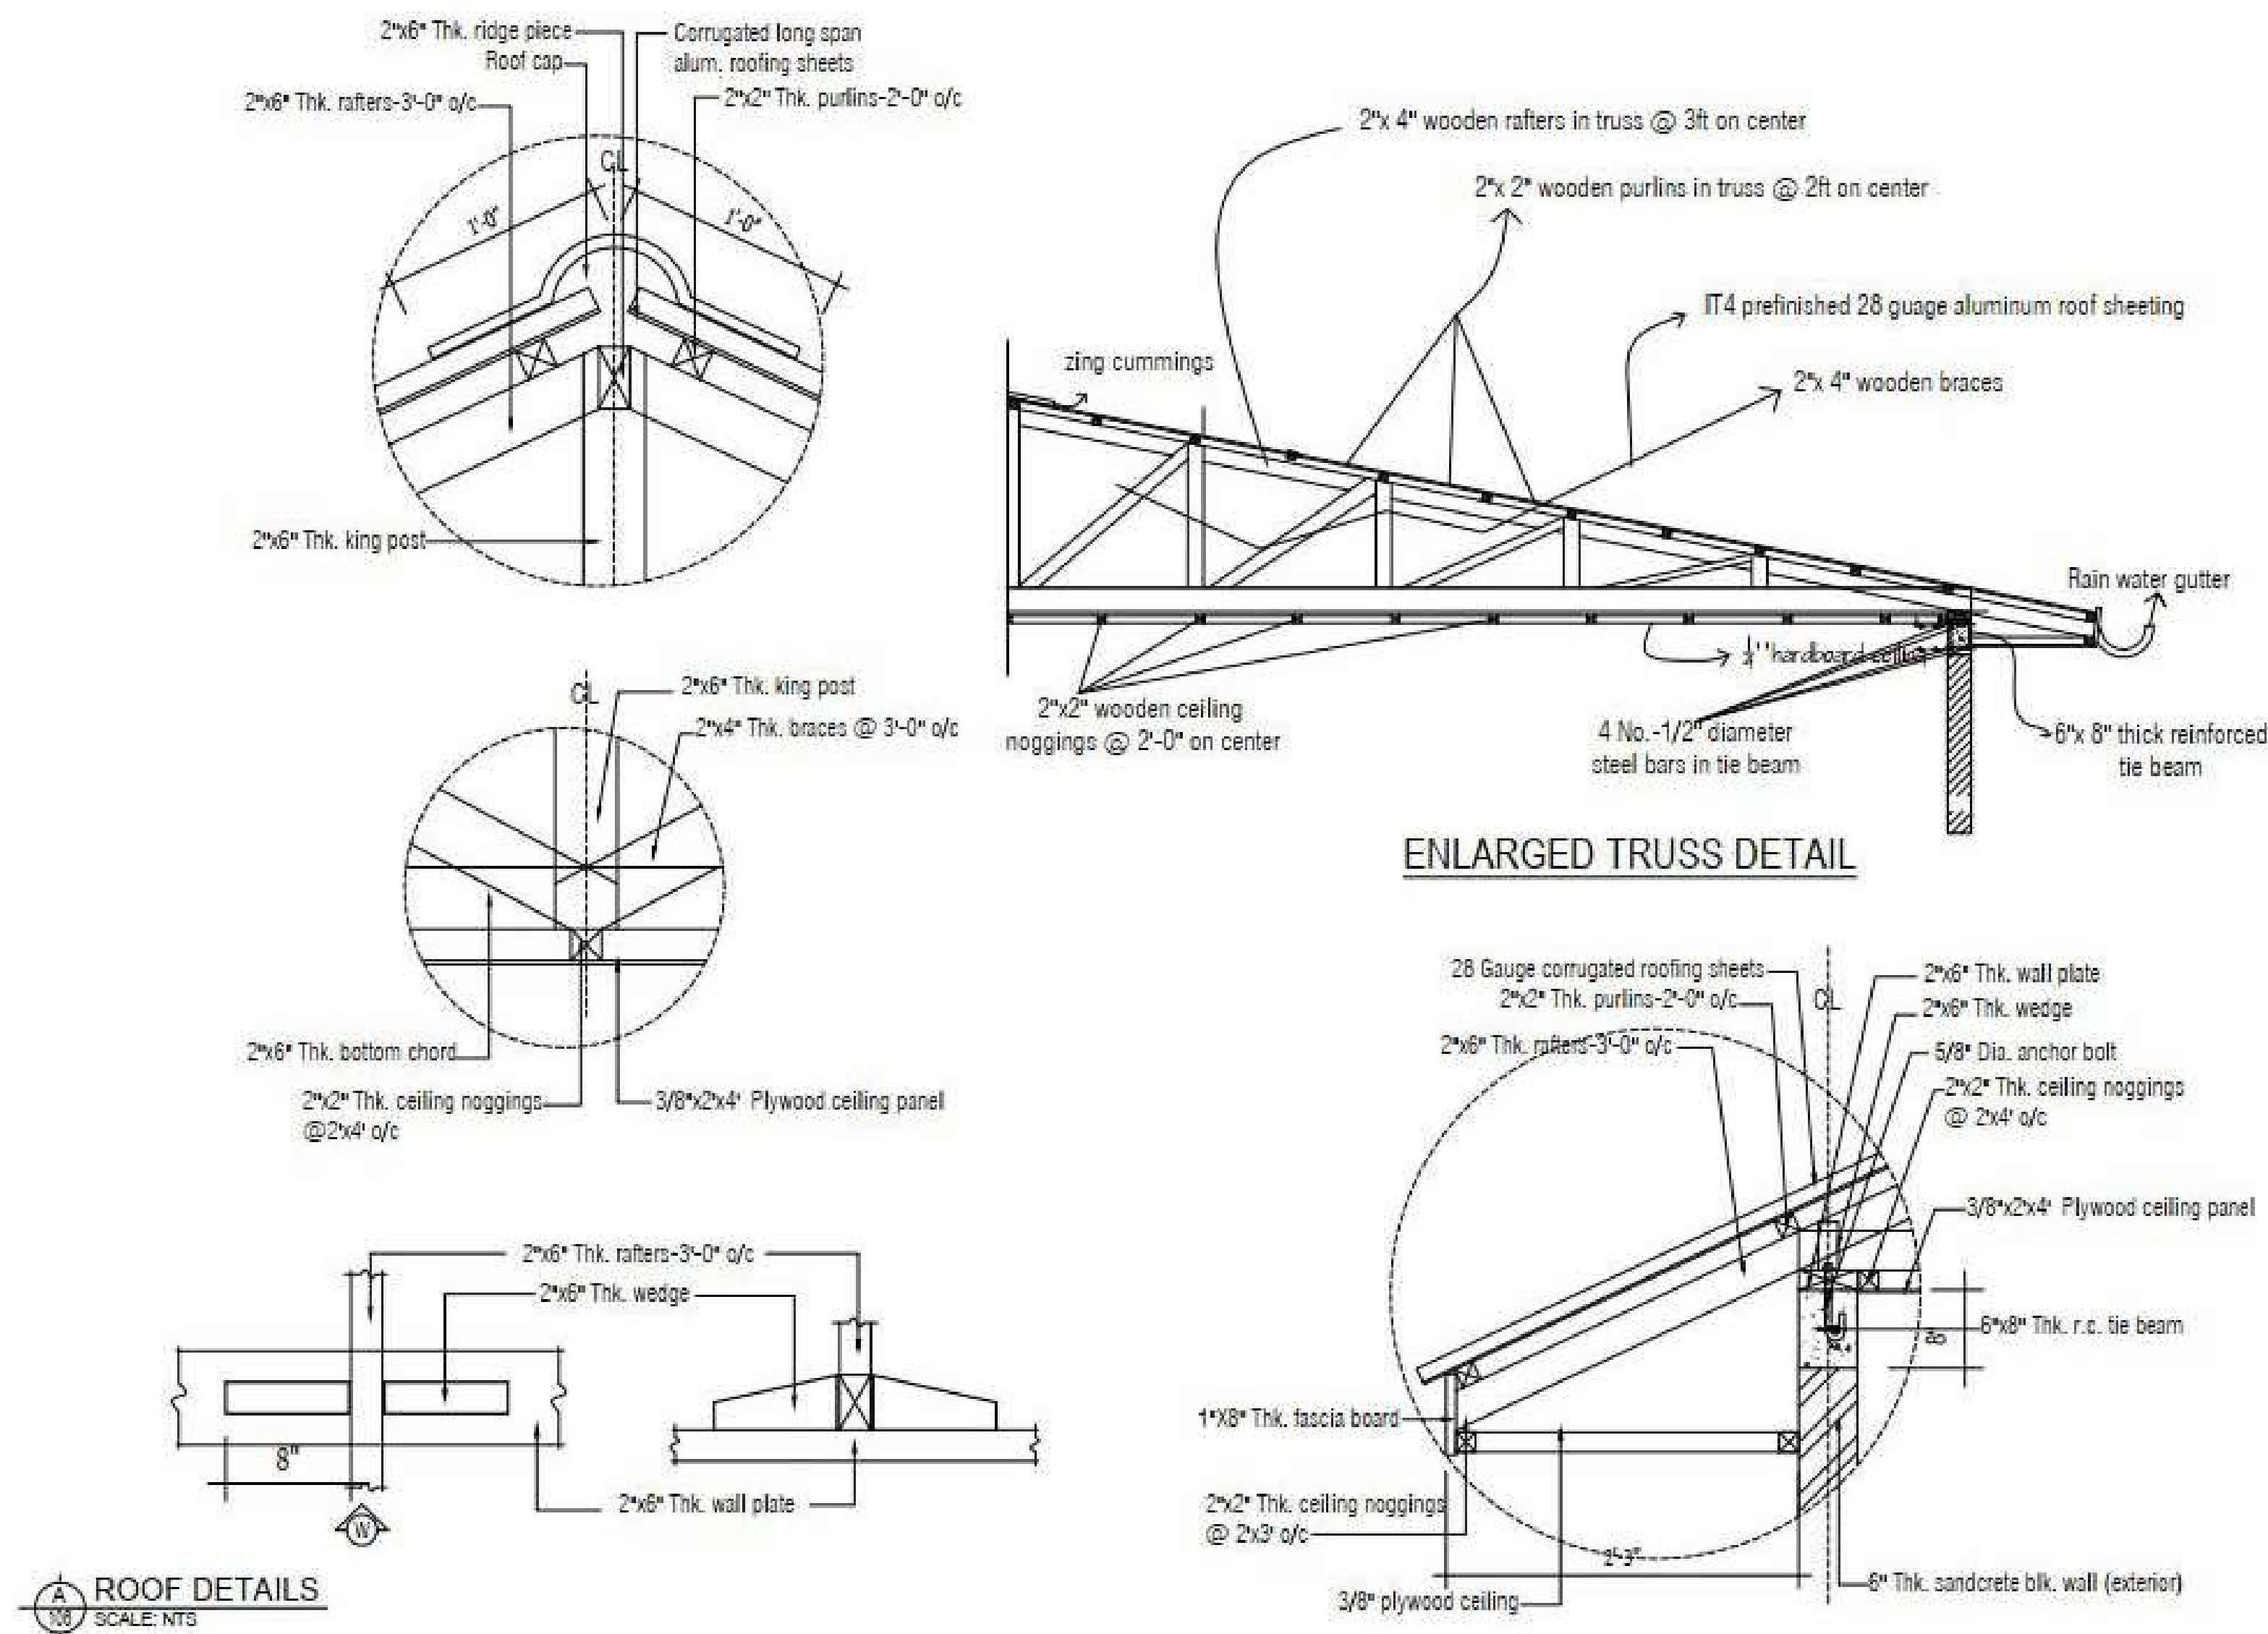


IFC DRAWING

Owner:
Ministry of Mines
and Energy

Project:
County Office

ROOF DETAILS

Project Number	002
Date	JULY 2026
Drawn By	MME Engineers
Checked By	
S105	
Scale	

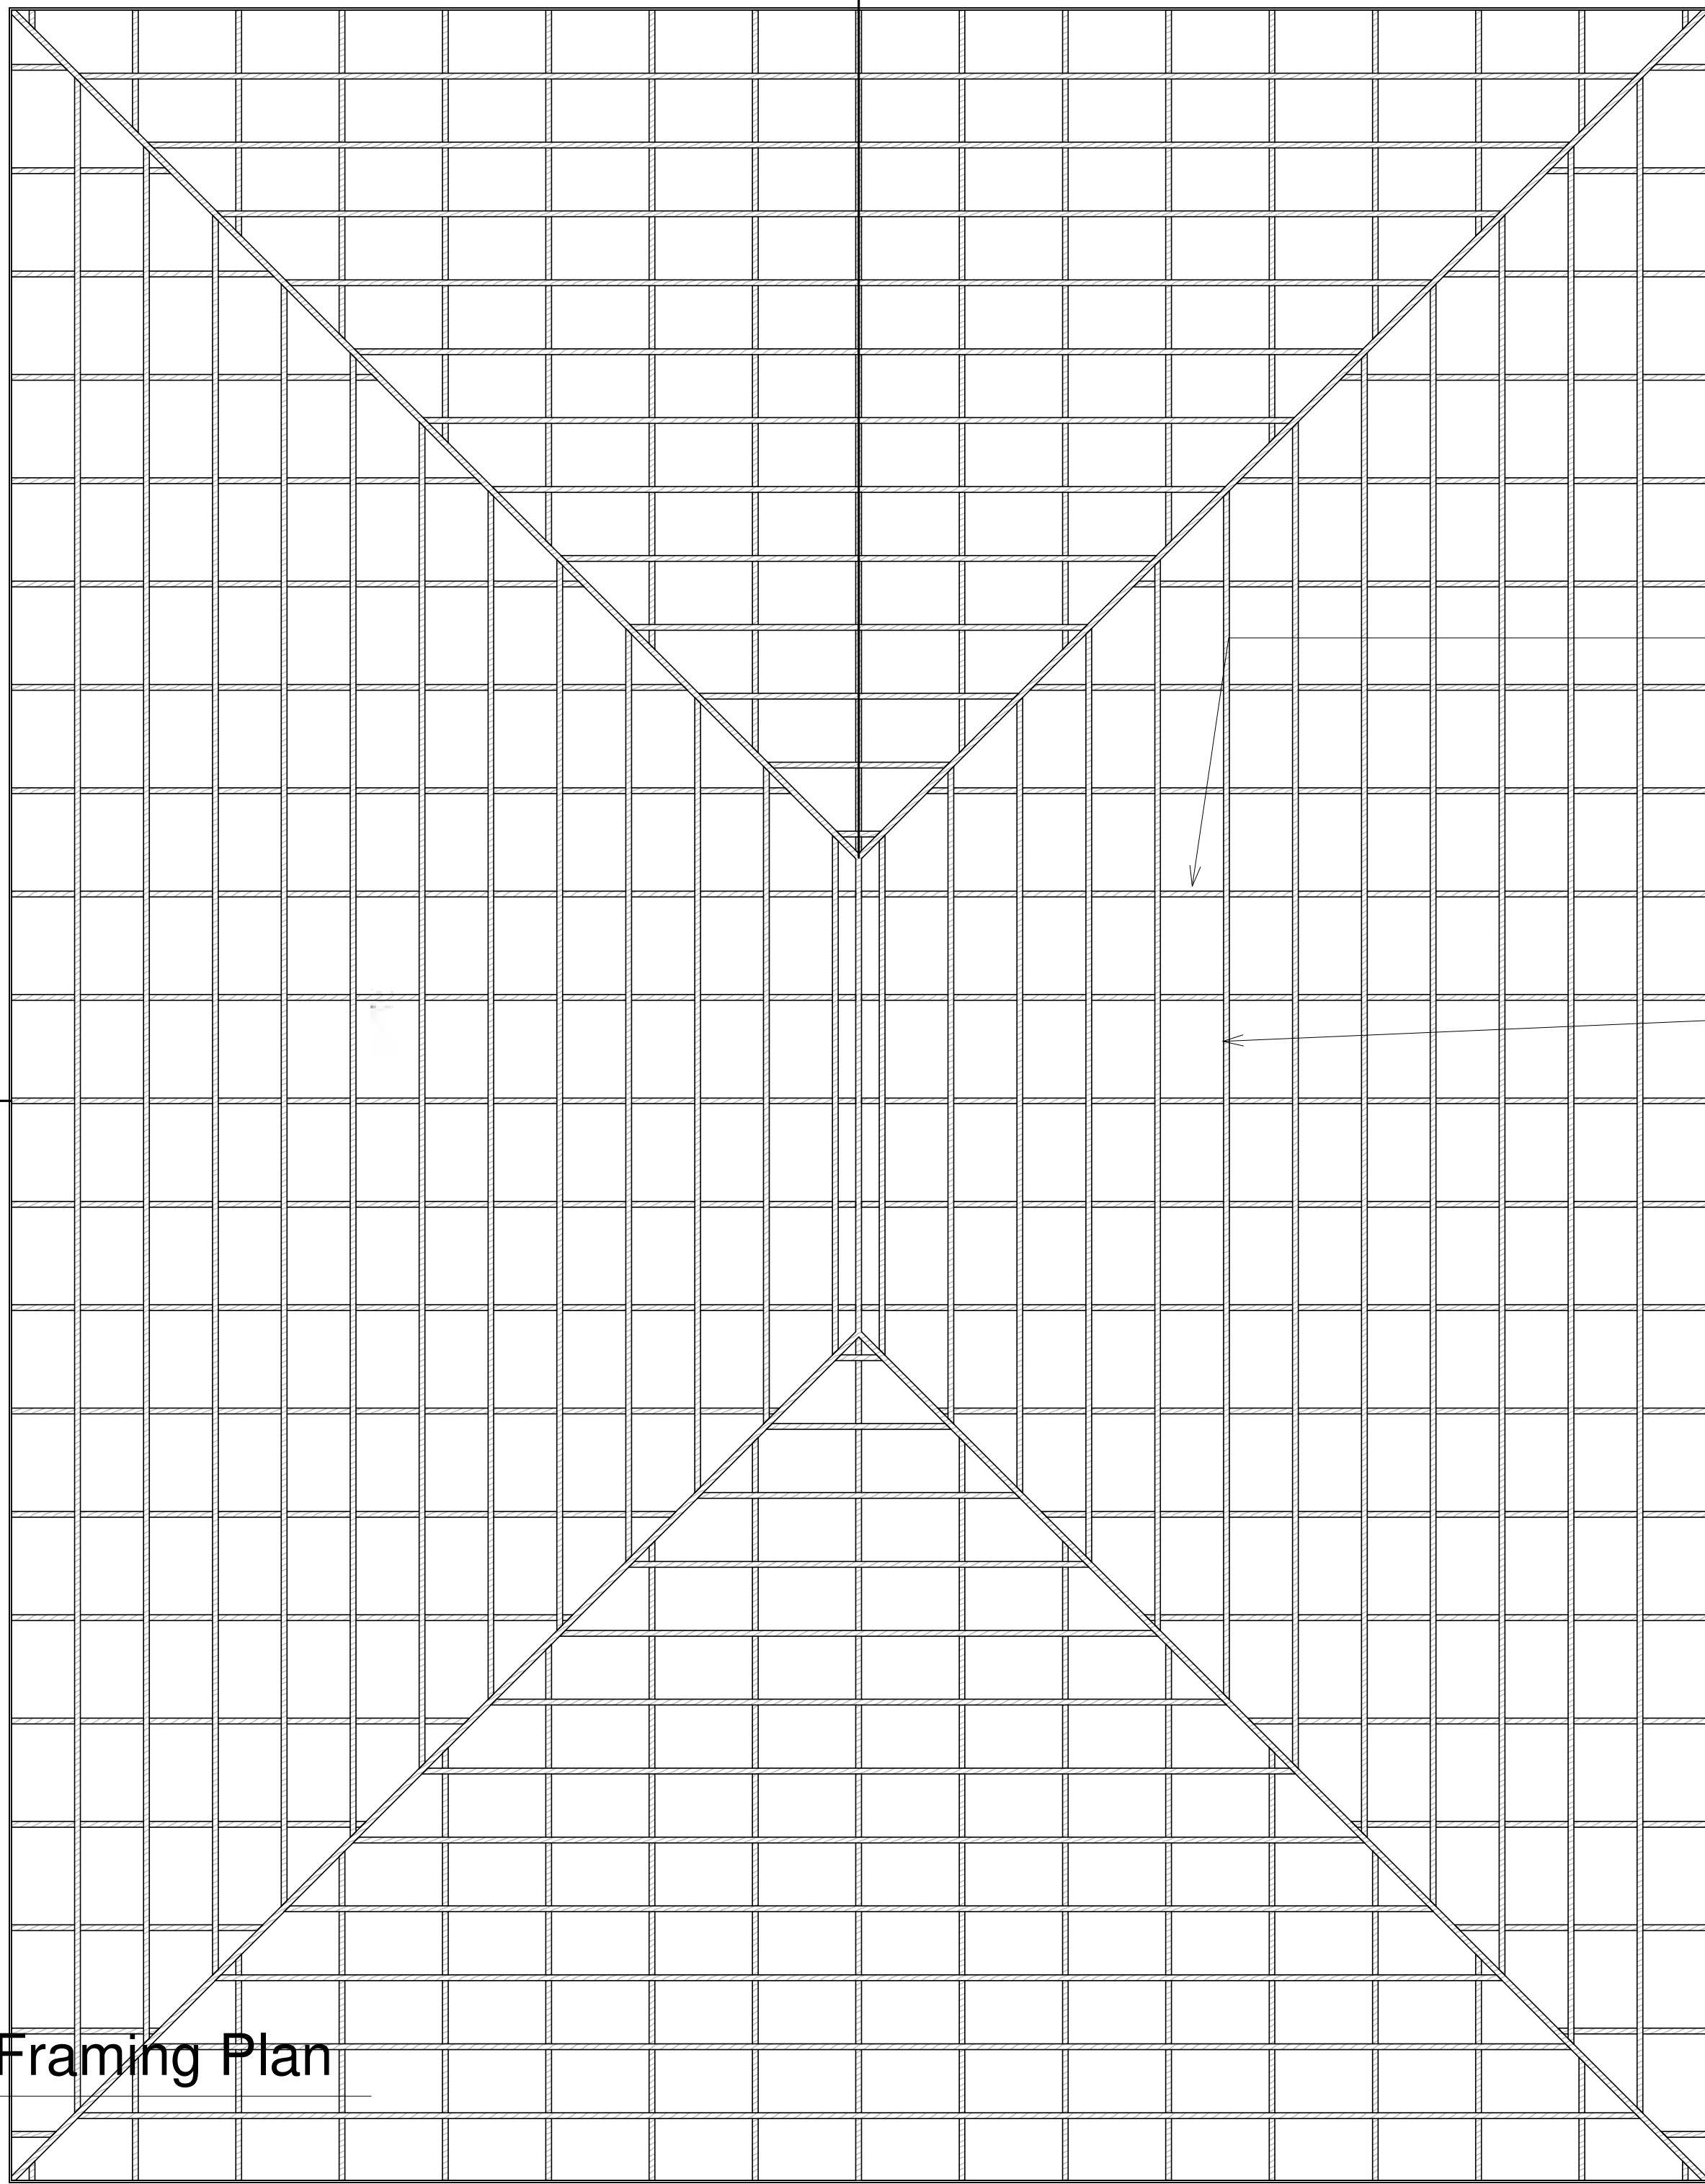

Hardwood 2" x4" Rafters @ 3' c/c

Hardwood 2" x2" Rafters @ 2' c/c

1 Roof Framing Plan
1 : 60

IFC DRAWING

Owner:
Ministry of Mines
and Energy


Project:
County Office

ROOF FRAMING

Project Number	002
Date	JULY 2026
Drawn By	MME Engineers
Checked By	

S104

Scale

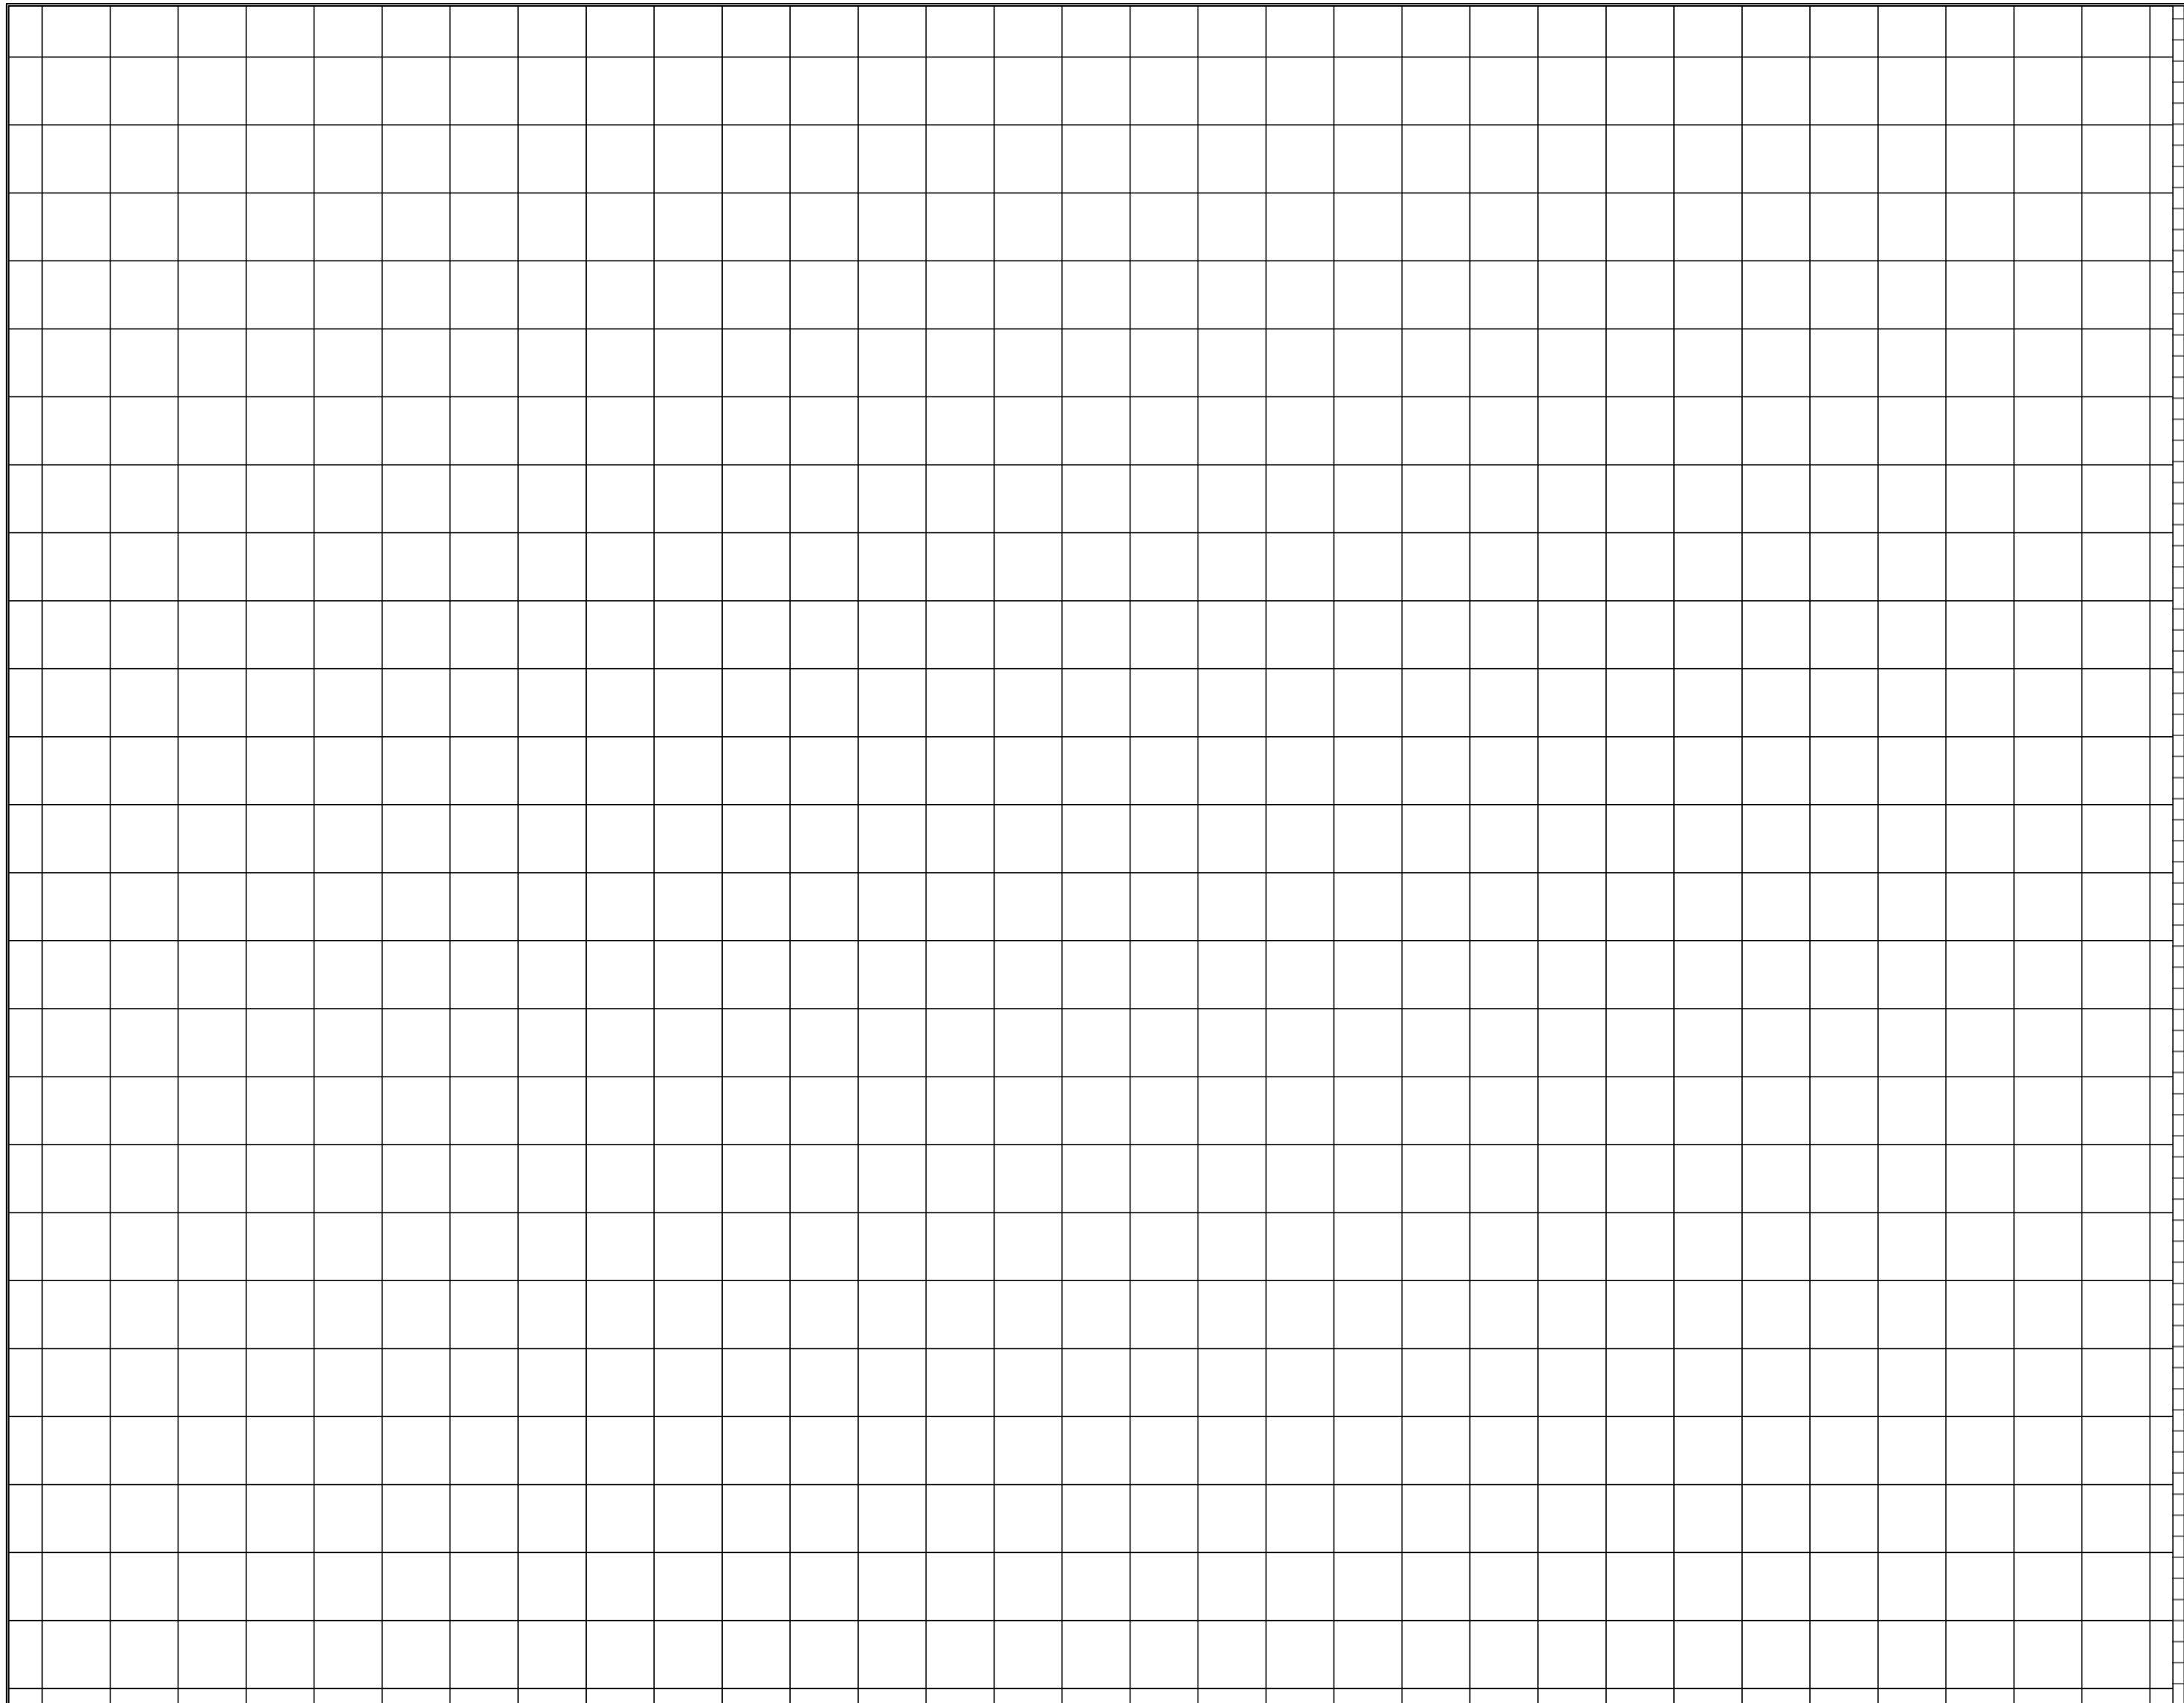

1 : 62
1
Ceiling Plan


IFC DRAWING

Owner:
Ministry of Mines
and Energy

Project:
County Office


CEILING PLAN

Project Number:	002
Date	JULY 2026
Drawn By	MME Engineers
Checked By	
A105	
Scale	

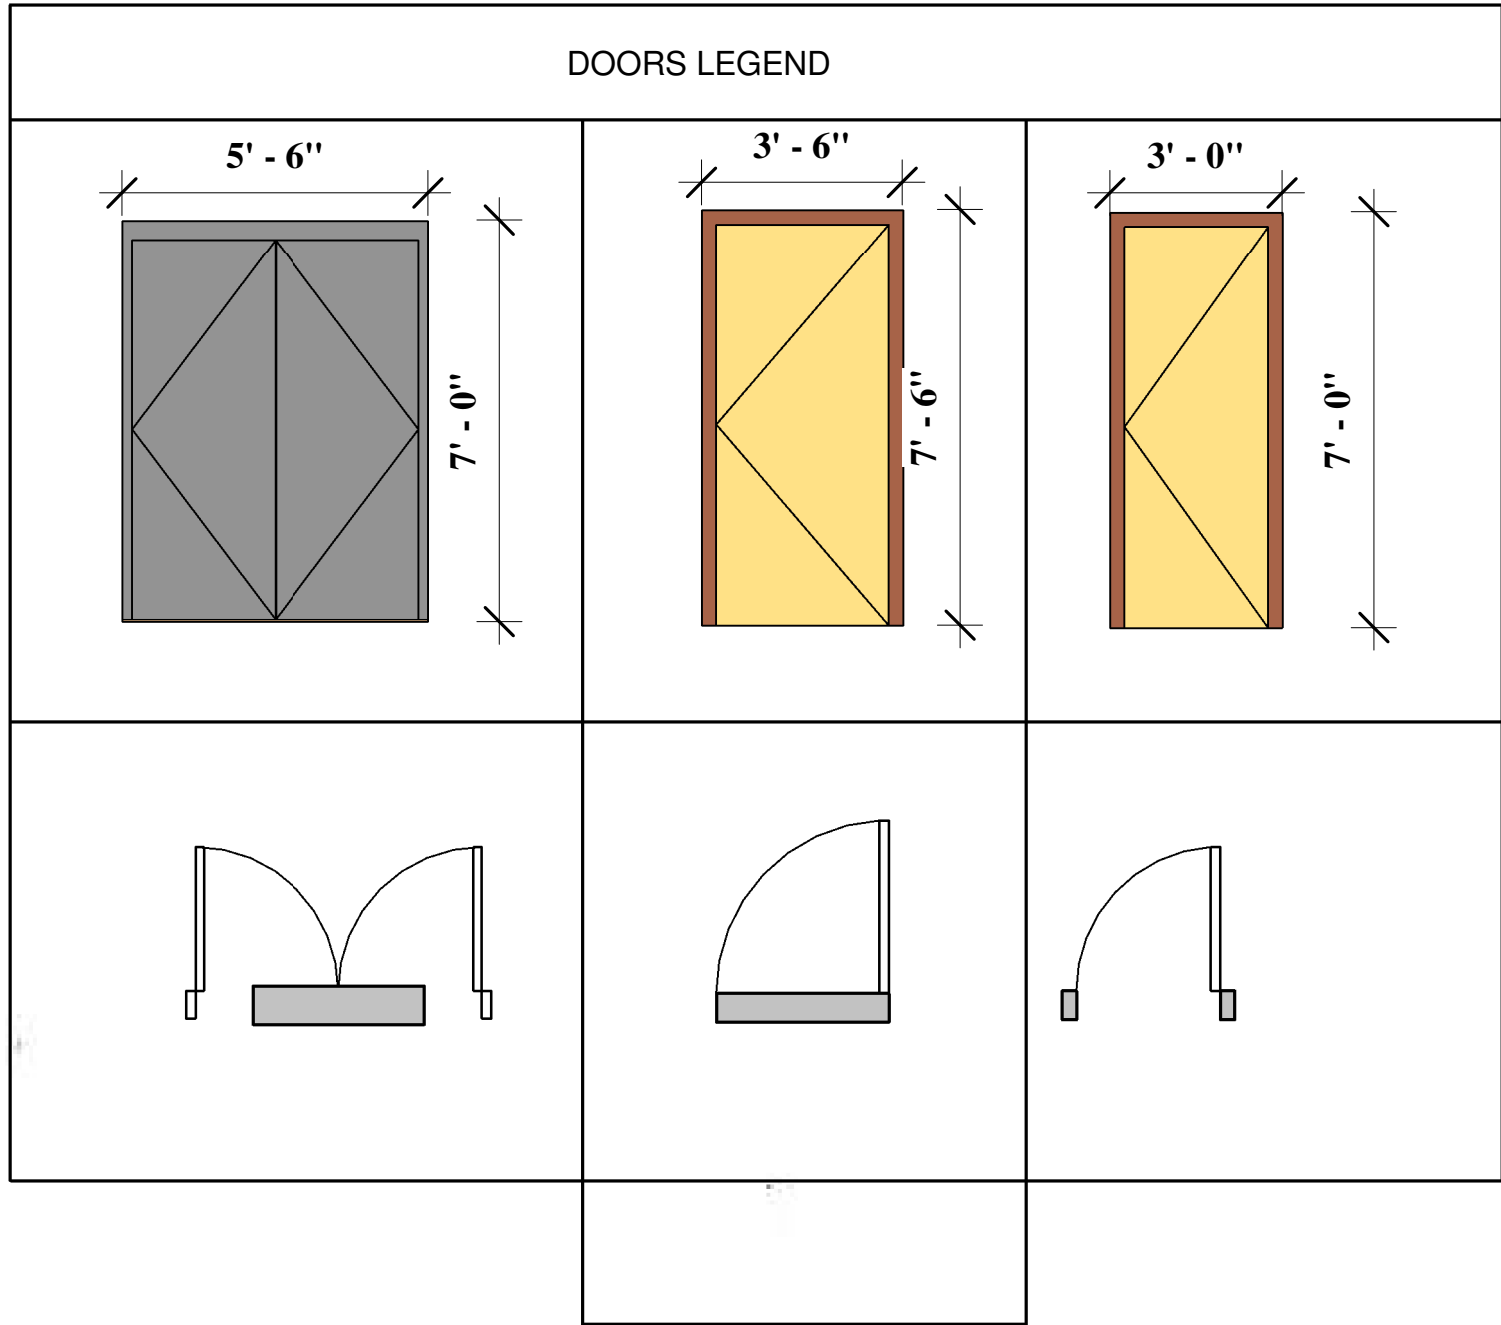

Doors Legend
1 : 50

Door Schedule					
Count	Height	Level	Thickness	Width	Type Mark
1	7' - 0"	First Floor	0' - 0"	5' - 0"	D2
1	6' - 6"	First Floor	0' - 0"	5' - 0"	D1
1	7' - 0"	First Floor	0' - 0"	3' - 0"	D2
1	6' - 6"	First Floor	0' - 0"	5' - 0"	D1
1	6' - 6"	First Floor	0' - 0"	5' - 0"	D1
1	7' - 0"	First Floor	0' - 0"	2' - 6"	D3
1	7' - 0"	First Floor	0' - 0"	2' - 6"	D3
1	7' - 0"	First Floor	0' - 0"	3' - 0"	D2

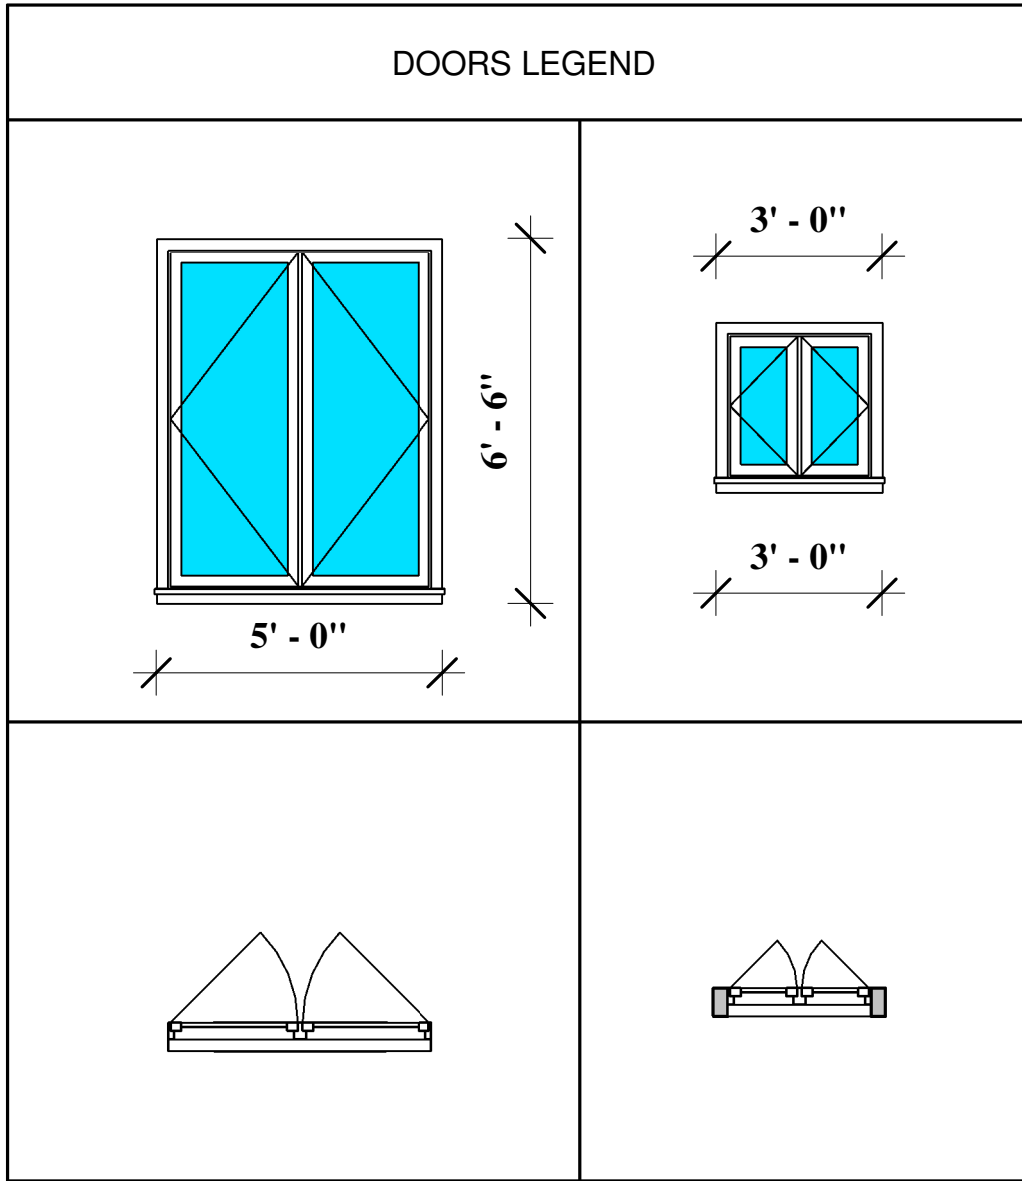

Window Schedule					
Count	Height	Level	Mark	Width	
1	2' - 6"	First Floor	W2	2' - 6"	
1	2' - 6"	First Floor	W2	2' - 6"	
1	6' - 0"	First Floor	W1	4' - 6"	
1	6' - 0"	First Floor	W1	4' - 6"	
1	6' - 0"	First Floor	W3	2' - 6"	


IFC DRAWING

Owner:
Ministry of Mines
and Energy


Project:
County Office

DOORS & WINDOWS


Project Number	002
Date	JULY 2026
Drawn By	MME Engineers
Checked By	
A106	
Scale	

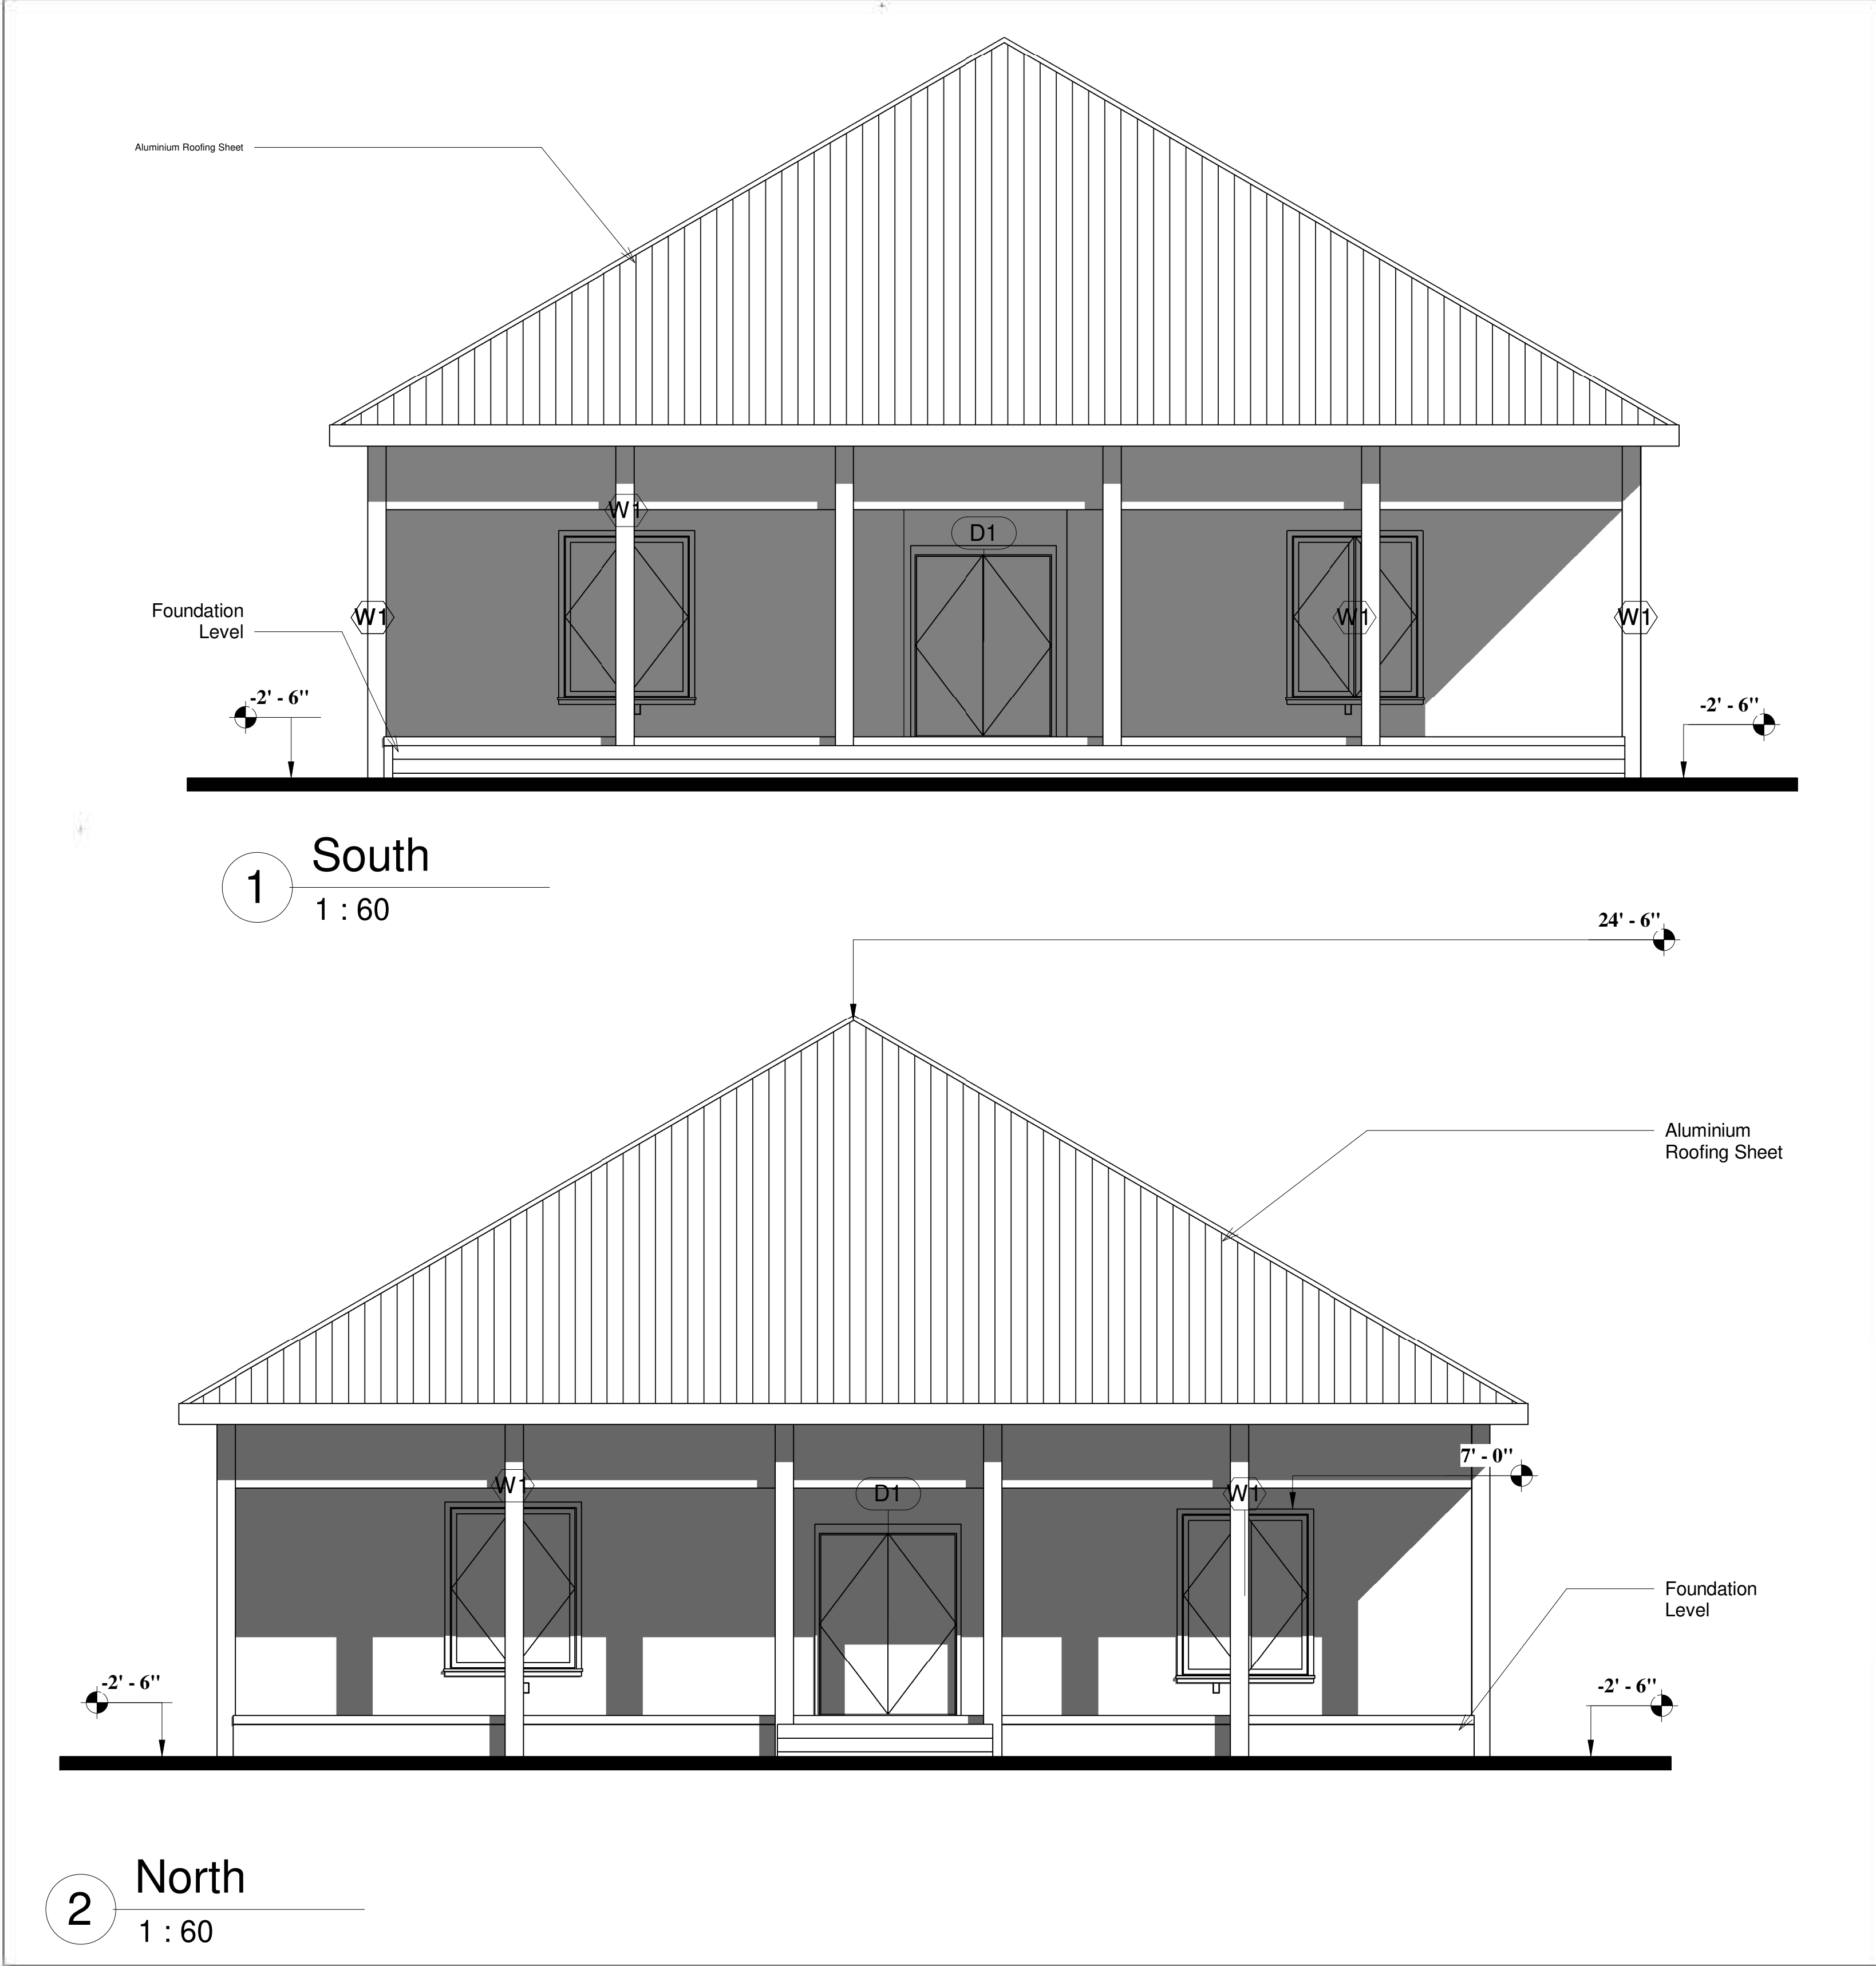

IFC DRAWING	
Owner: Ministry of Mines and Energy	
Project: County Office	
ELEVATIONS	
Project Number	002
Date	JULY 2026
Drawn By	MME Engineers
Checked By	
A107	
Scale	

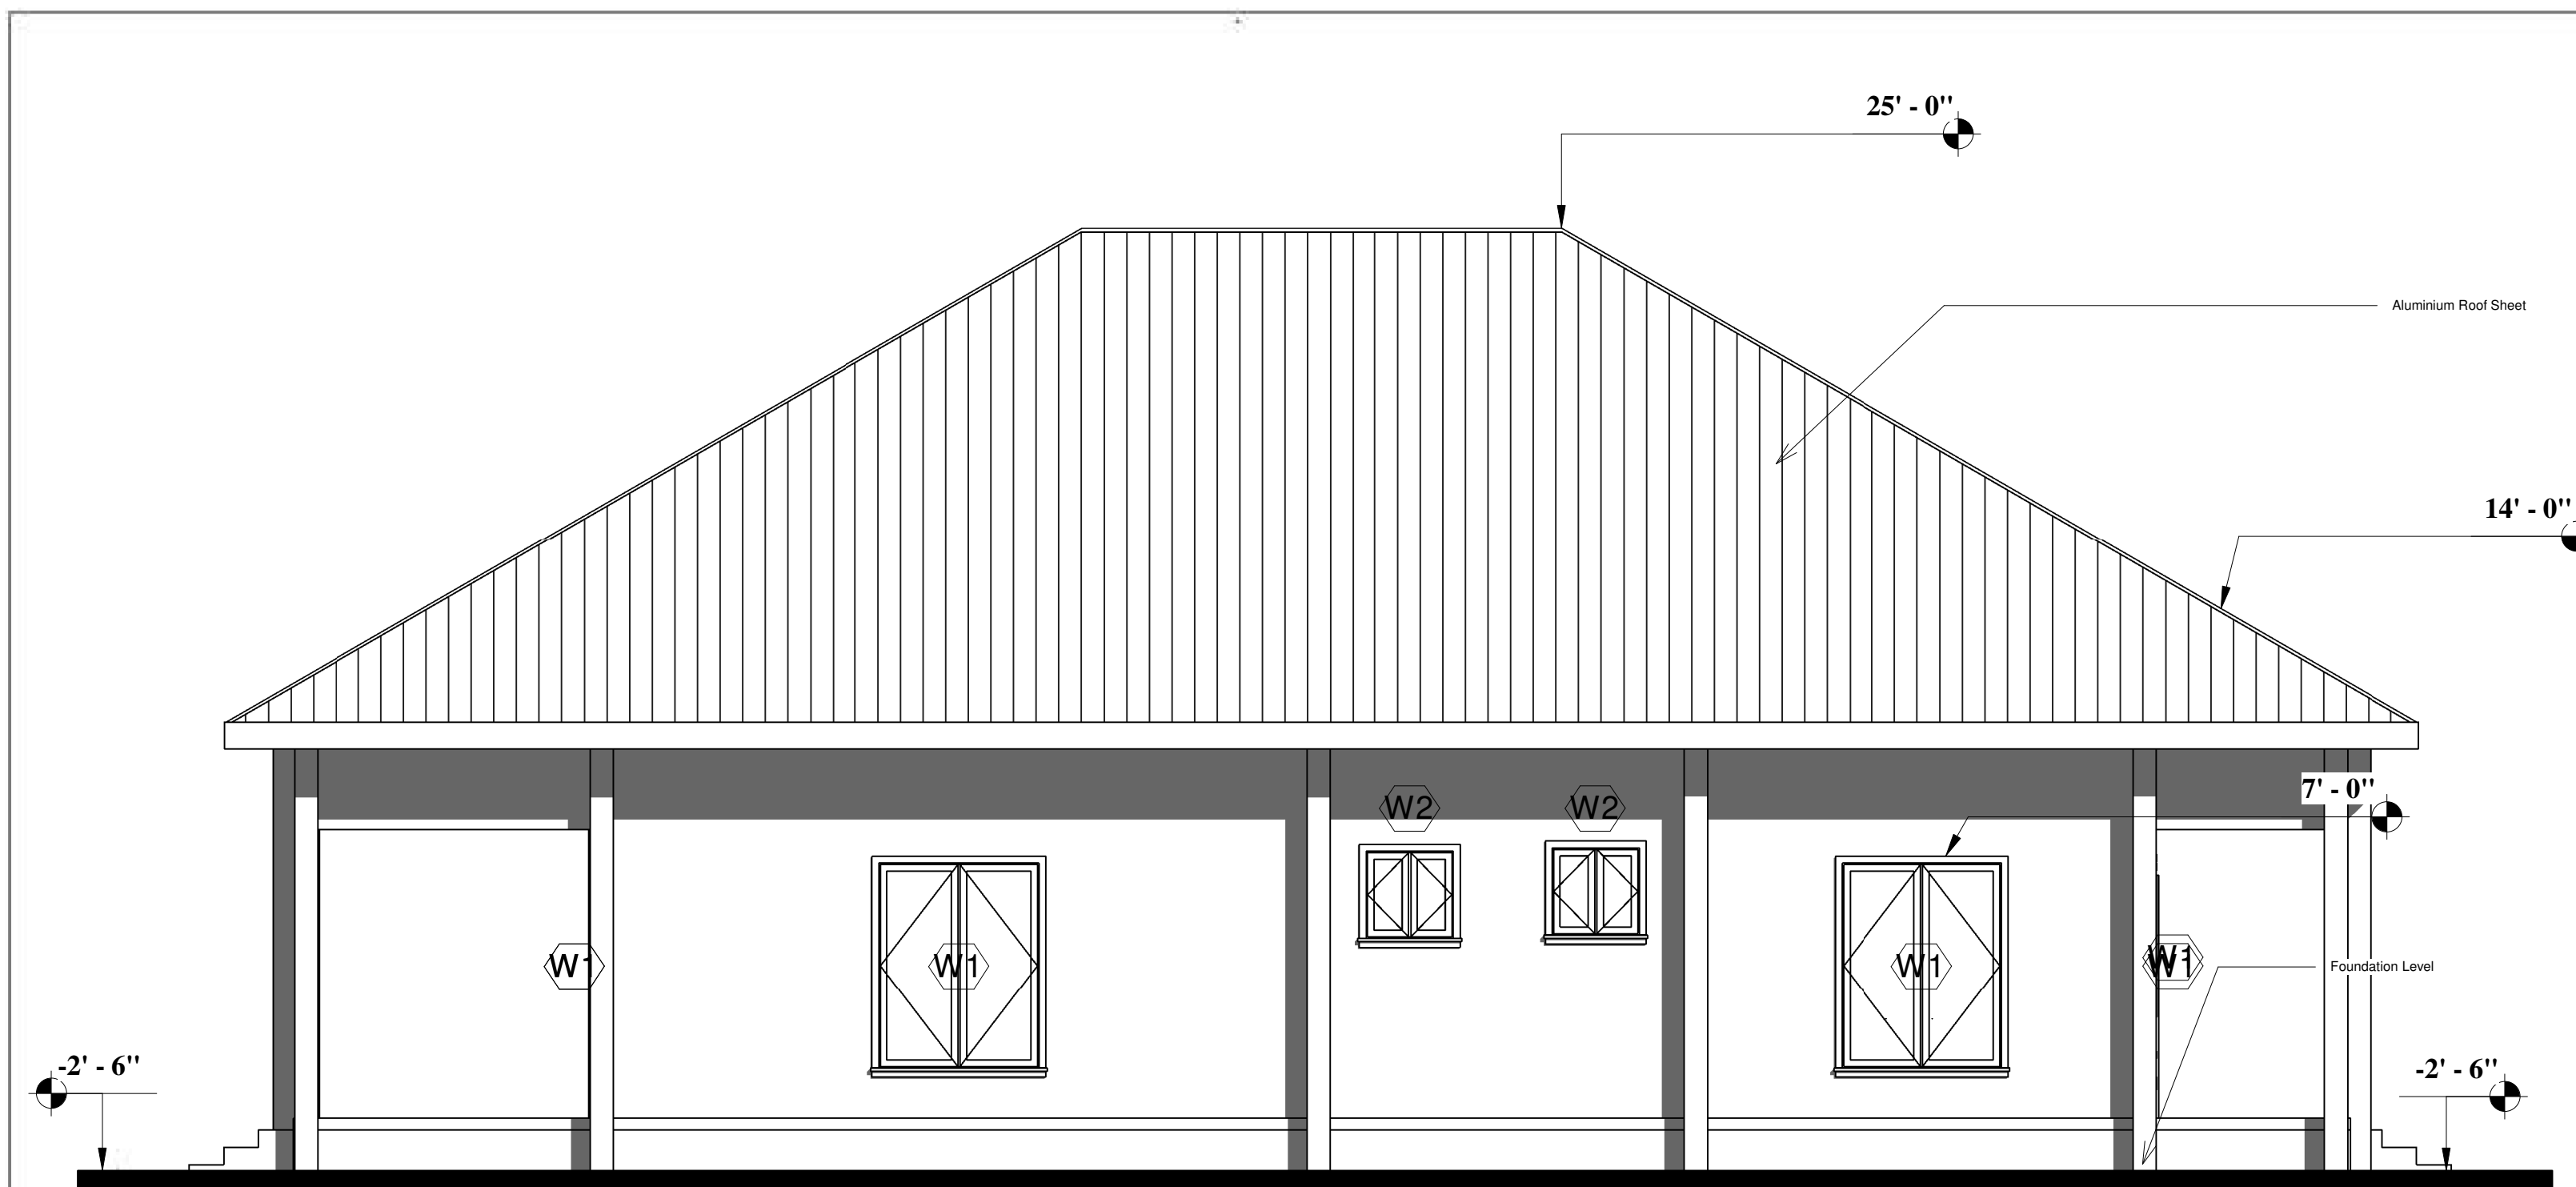

1 East
1 : 66

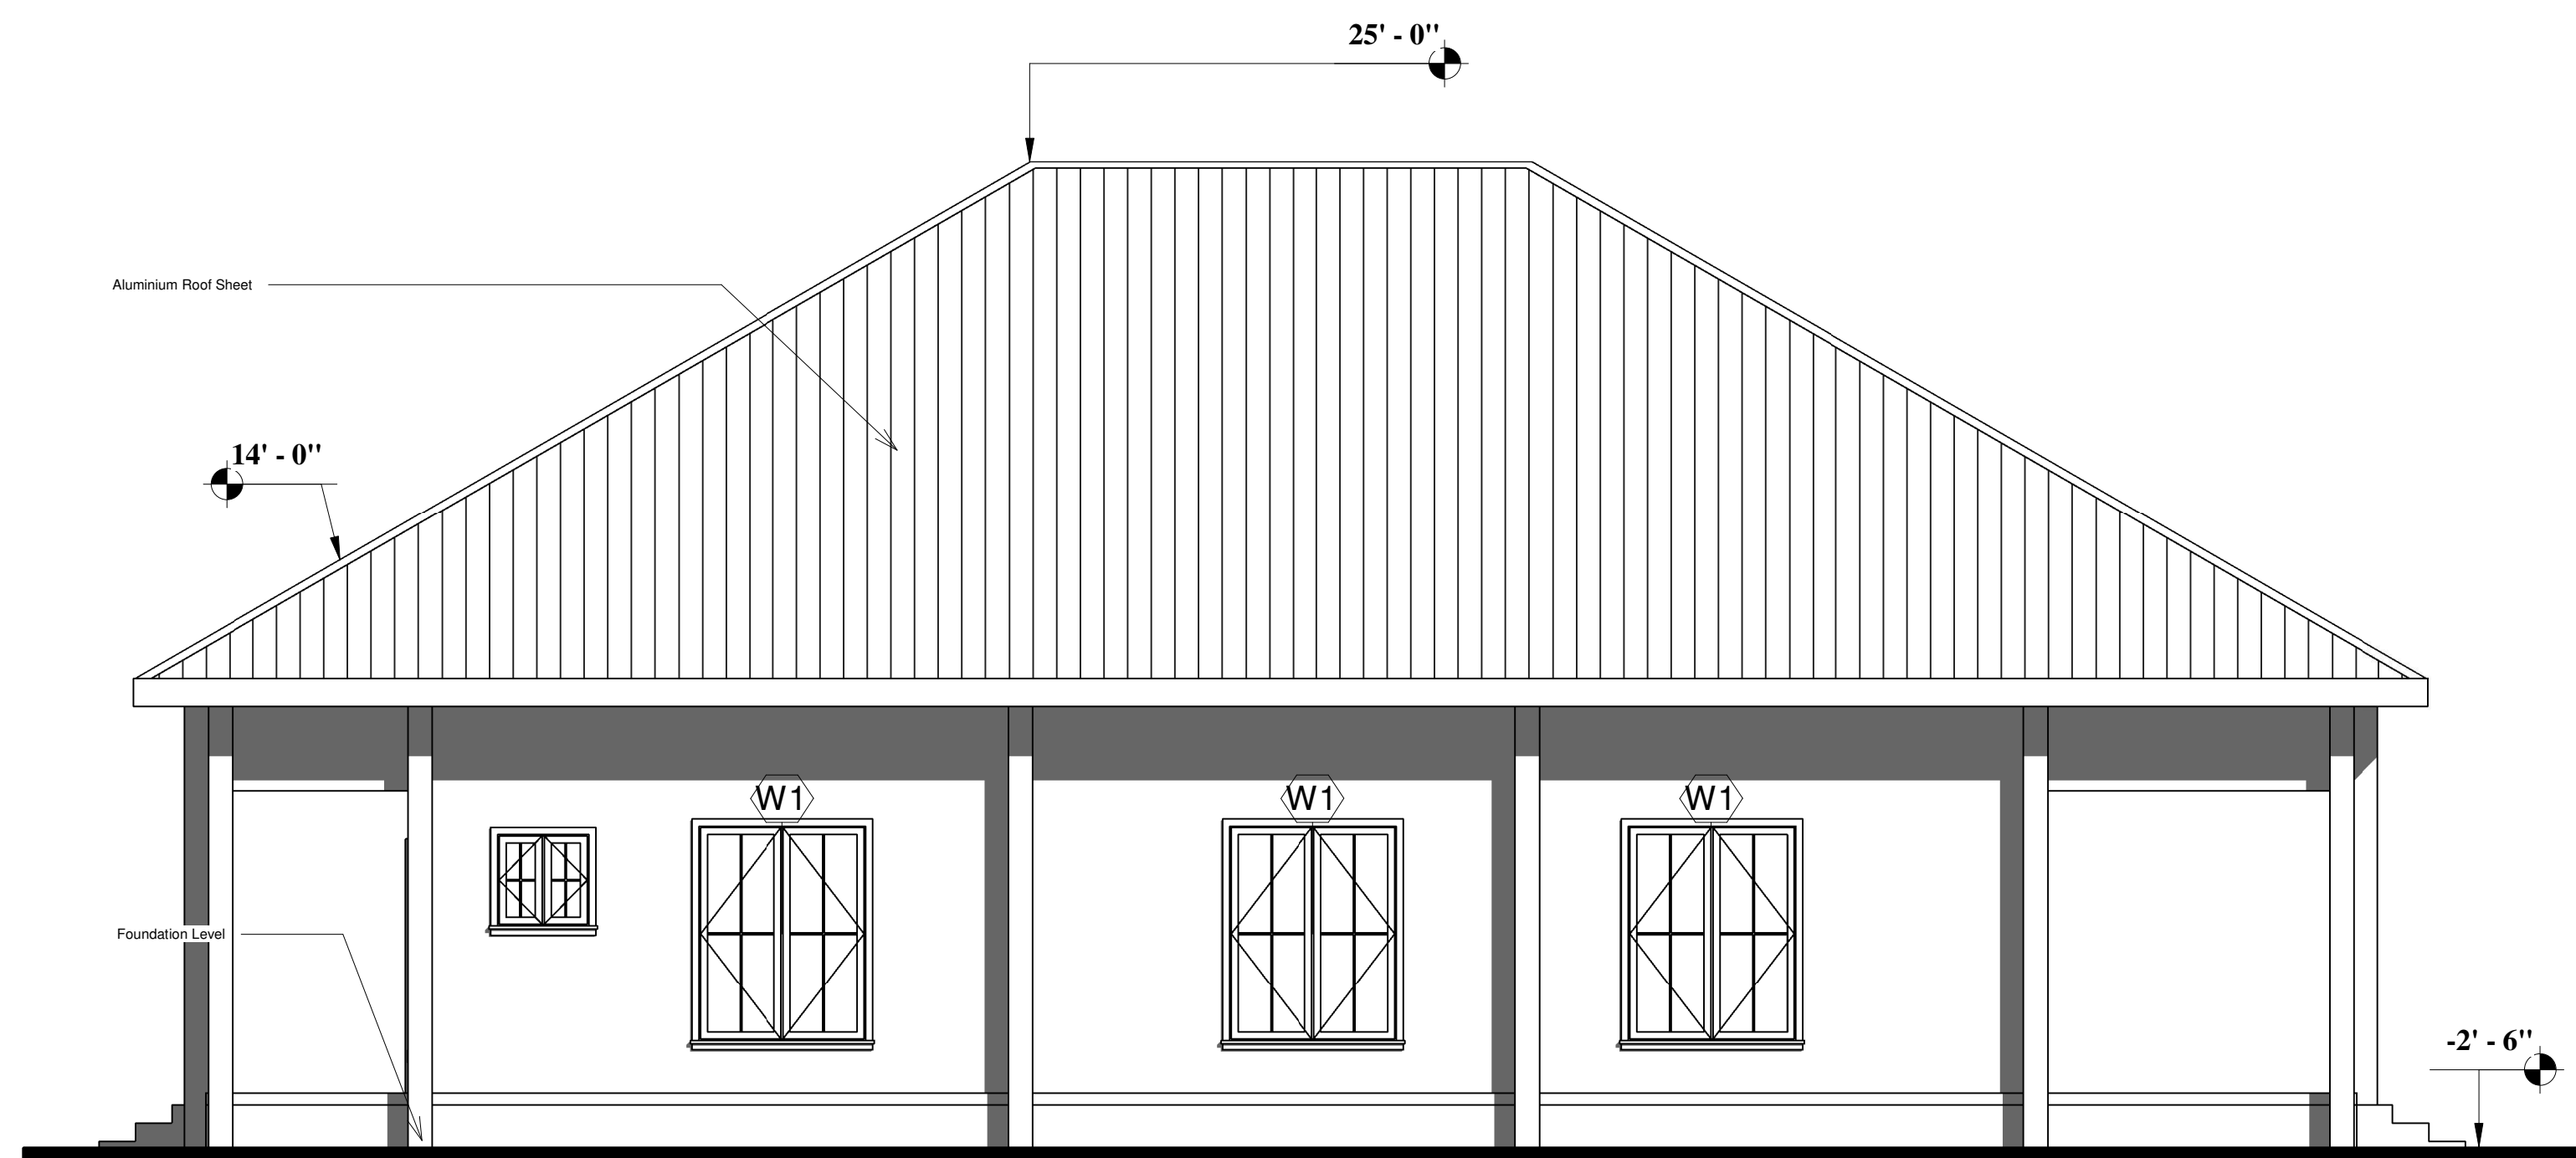

2 West
1 : 66

IFC DRAWING

Owner:
Ministry of Mines
and Energy


Project:
County Office

ELEVATIONS 1


Project Number	002
Date	JULY 2026
Drawn By	MME Engineers
Checked By	

A108

Scale

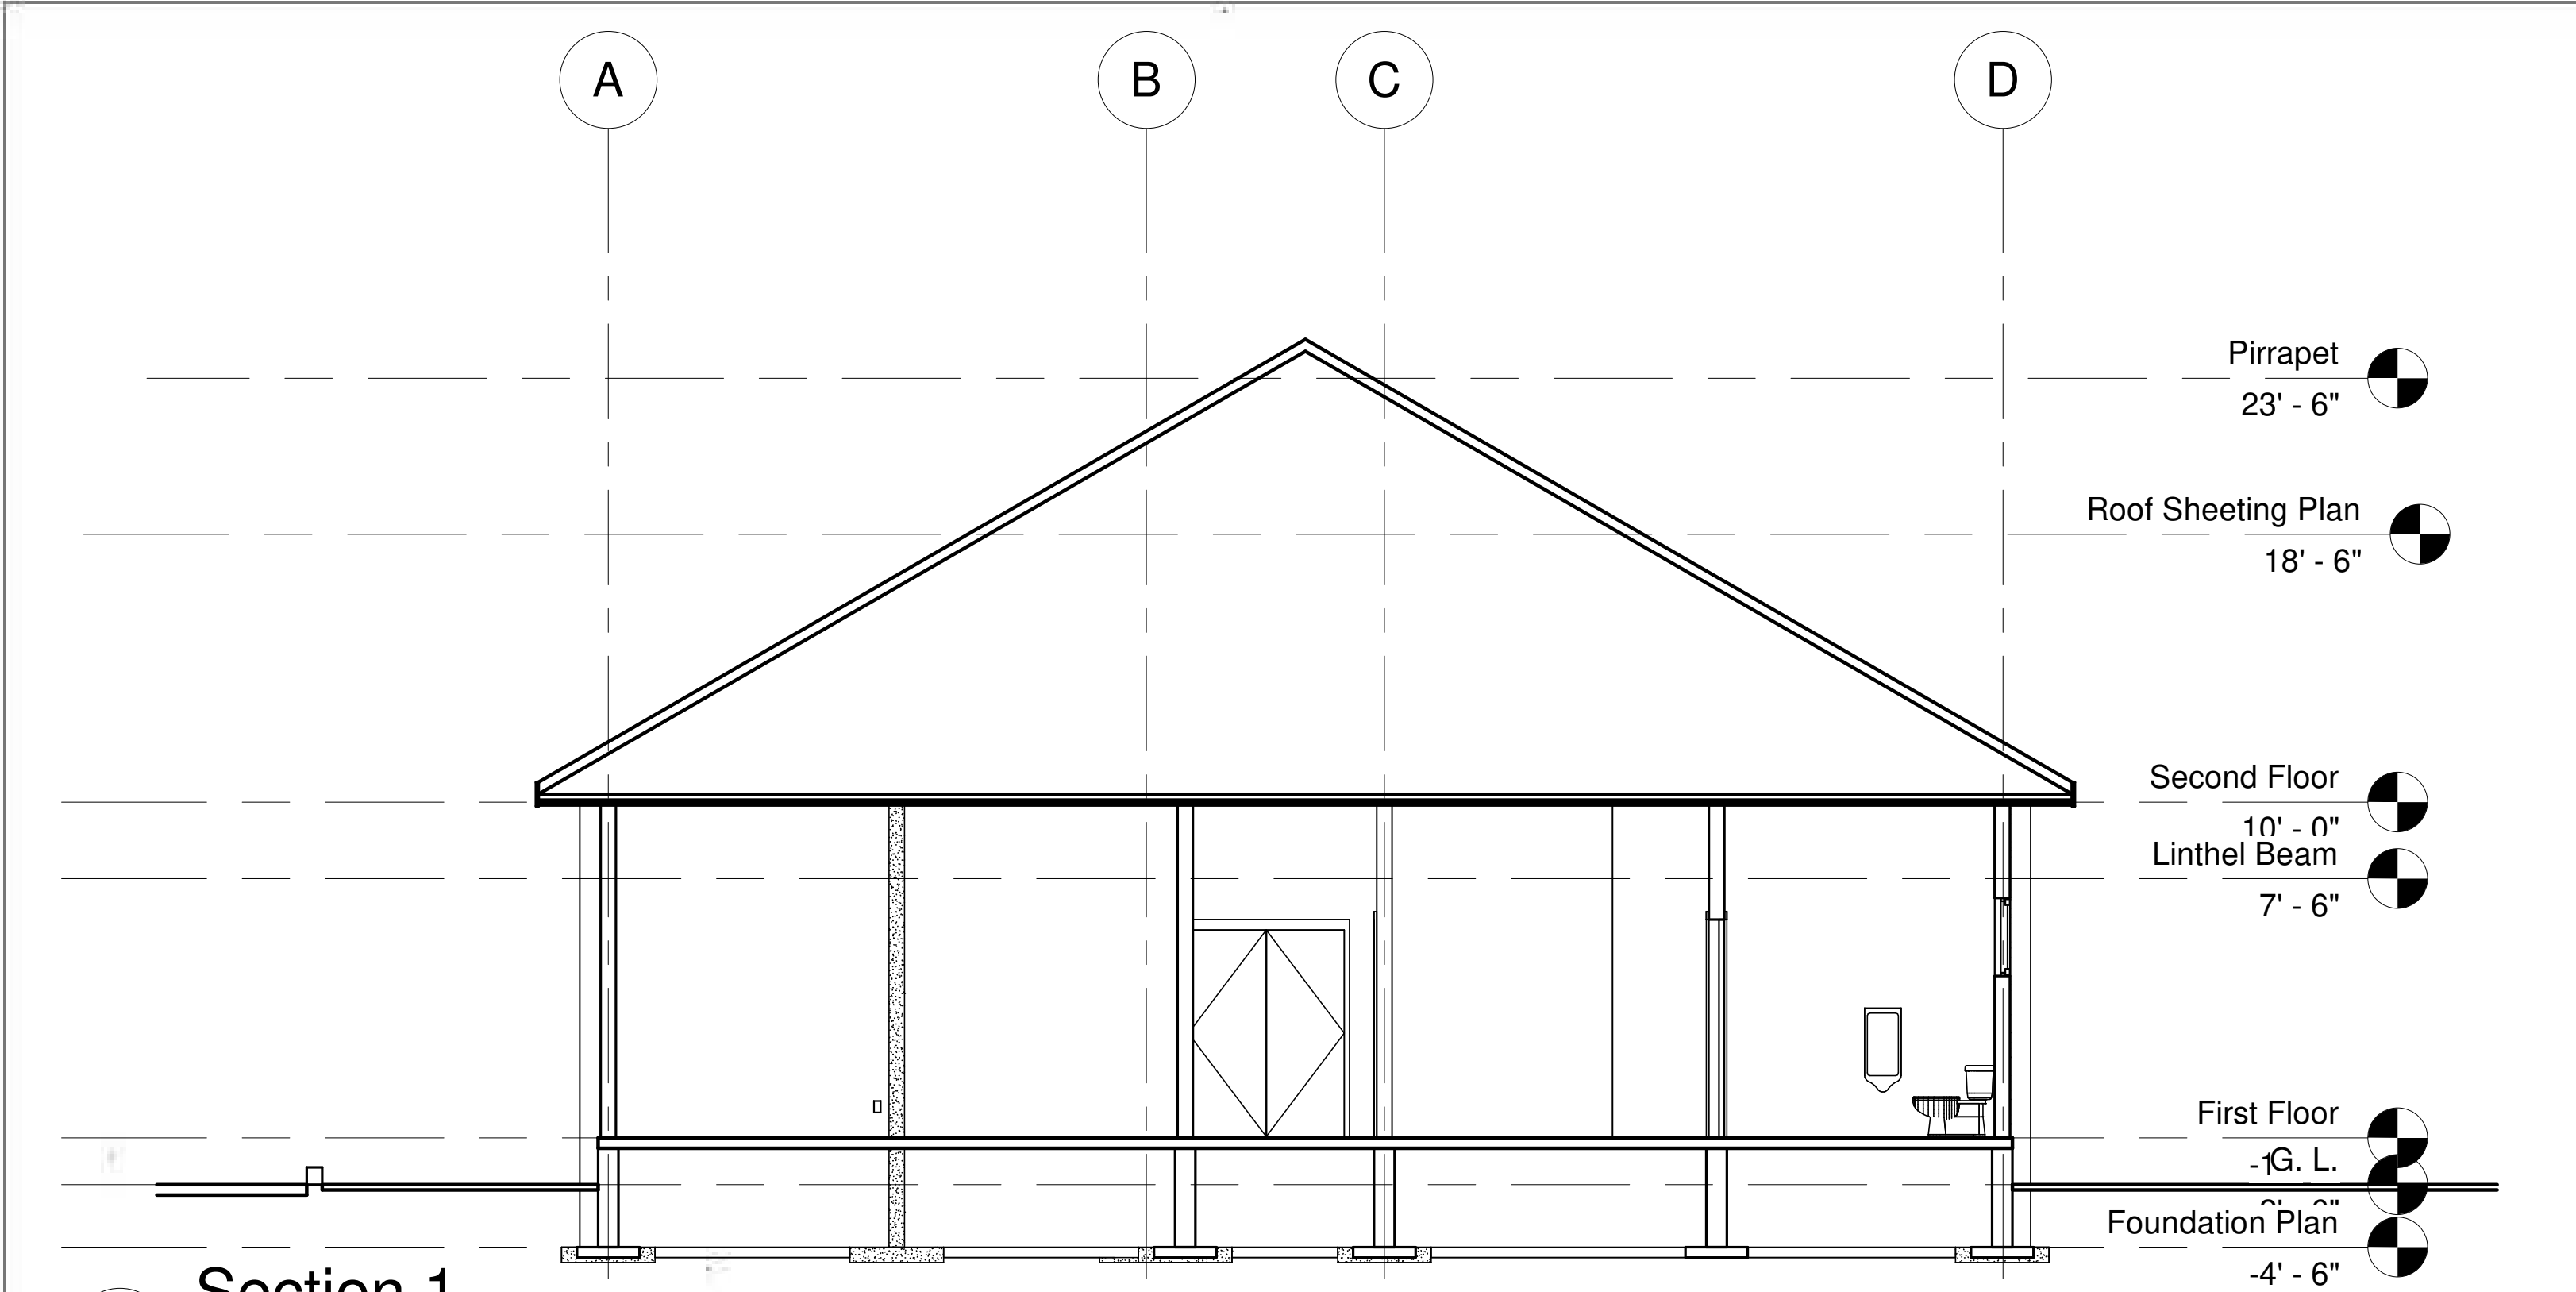

1 Section 1
1 : 73

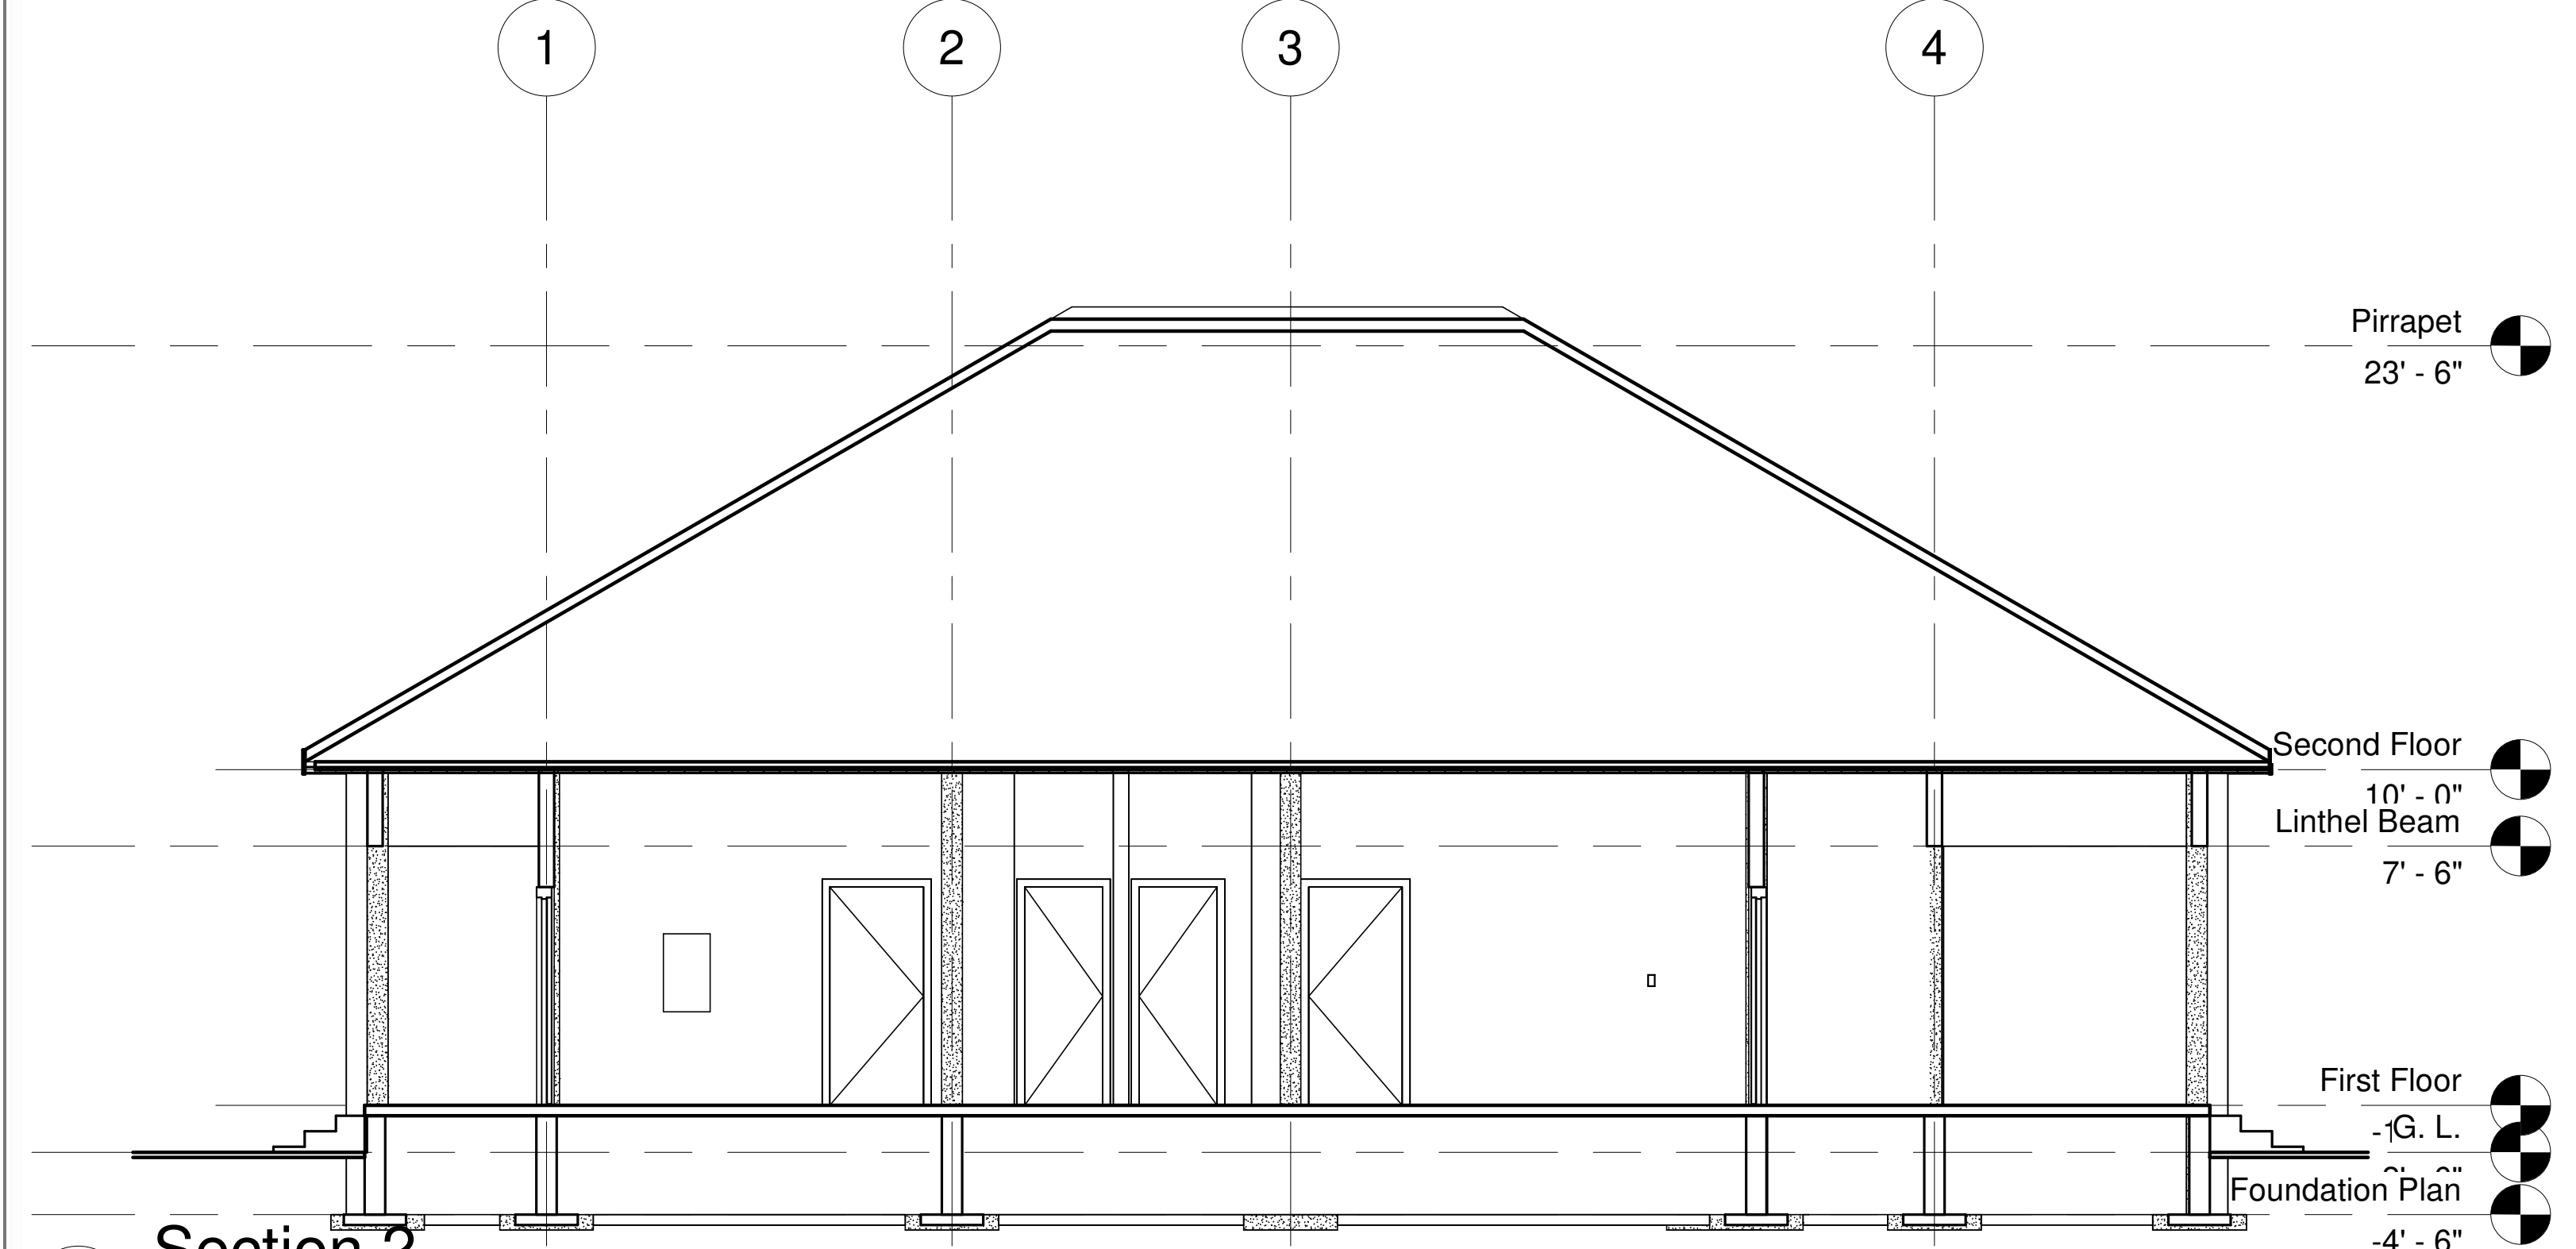

2 Section 2
1 : 73


IFC DRAWING

Owner:
Ministry of Mines
and Energy


Project:
County Office

SECTION DETAILS

Project Number	002
Date	JULY 2026
Drawn By	MME Engineers
Checked By	
S106	
Scale	

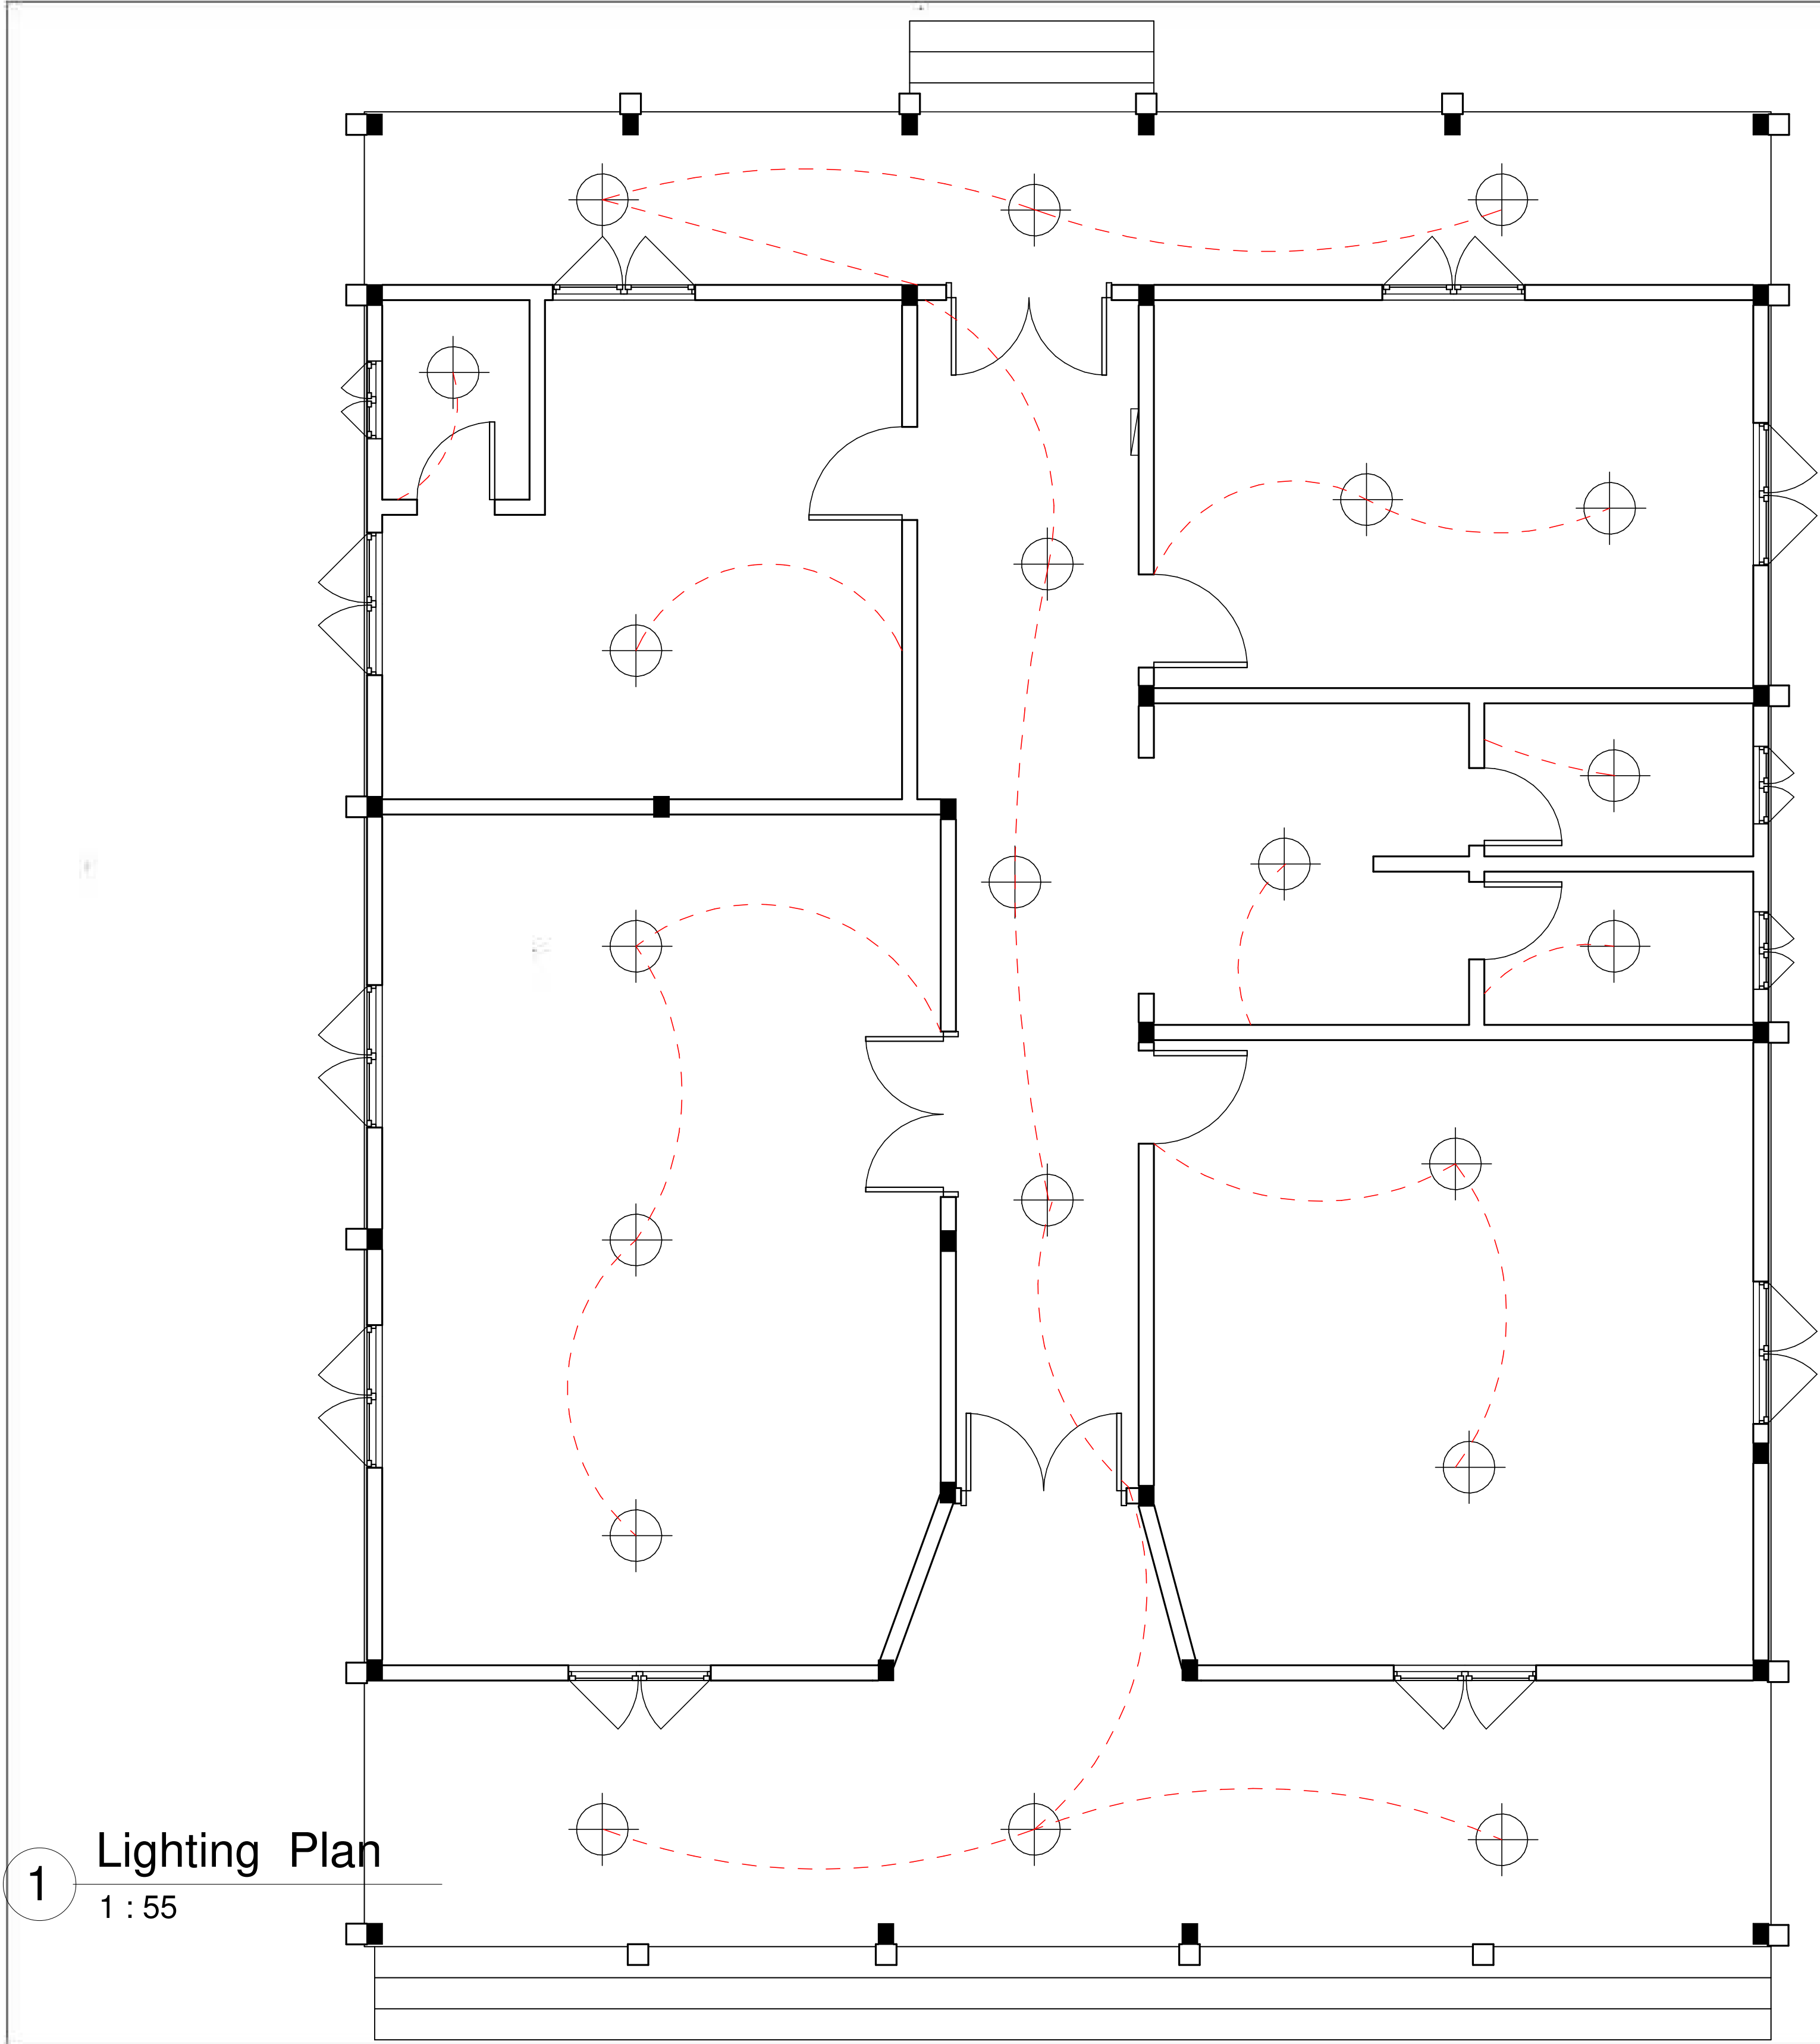

IFC DRAWING	
Owner: Ministry of Mines and Energy	
Project: County Office	
LIGHTING PLAN	
Project Number	002
Date	JULY 2026
Drawn By	MME Engineers
Checked By	
E101	
Scale	

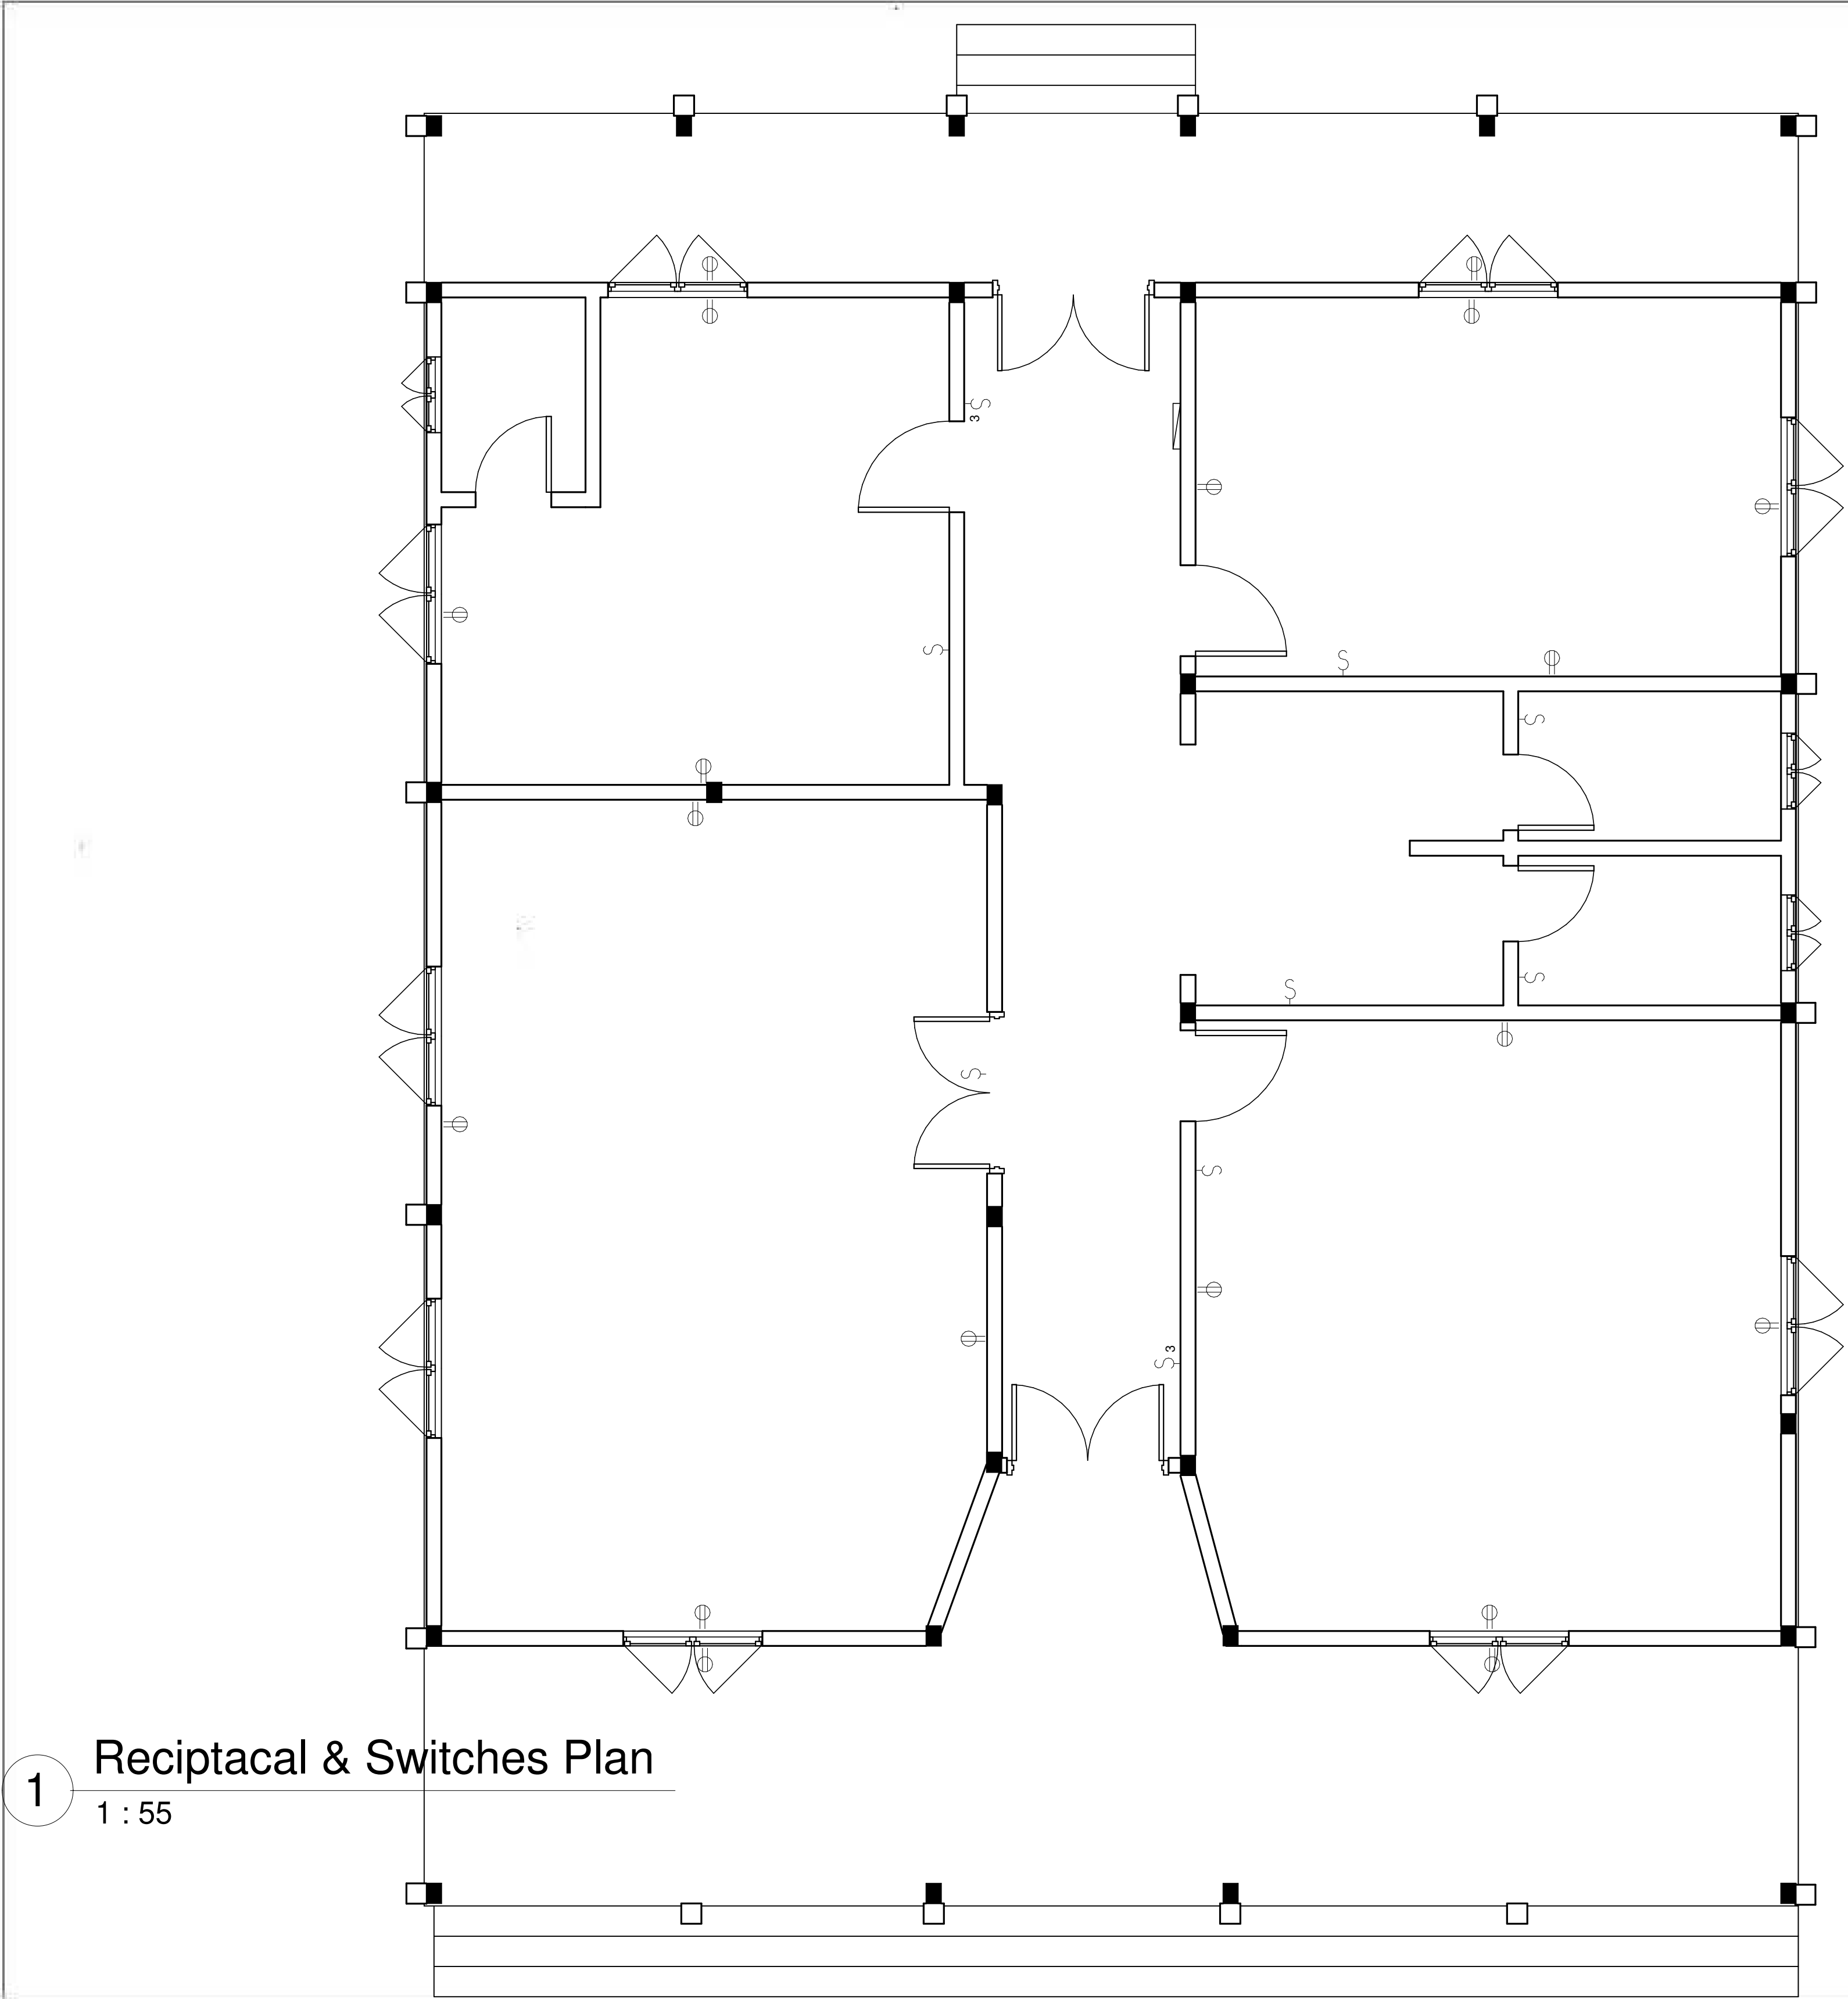

1 Reciptacal & Switches Plan
1 : 55

IFC DRAWING	
Owner: Ministry of Mines and Energy	
Project: County Office	
RECEPTICLE&SWITCHS	
Project Number	002
Date	JULY 2026
Drawn By	MME Engineers
Checked By	
E102	
Scale	

PANEL CONNECTION DIAGRAM

230 / 400 VOLTS, 3-PHASE, 50 HZ

4X NO. 4 AWG IN 2" C

100 AMP MAIN BREAKER

Circuit	Voltage	Current	Notes
LIGHTING CIRCUITS	230V	10A	
RECEPTACLES	230V	15 A	
LIGHTING CIRCUITS	230V	10A	
RECEPTACLES	230V	15 A	
CEILING FAN	230V	30A	
CEILING FAN	230V	30 A	
AIR CONDITIONAL	230V	30A	
AIR CONDITIONAL	230V	30 A	
RANGE	230V	30A	
RANGE	230V	30 A	
SOLAR CHARGER	230V	10A	
SOLAR CHARGER	230V	10A	
EMERGENCY LIGHTS	230V	10A	
EMERGENCY LIGHTS	230V	10A	
SPARE	230V	50A	
SPARE	230V	50A	
SPARE	230V	20A	
SPARE	230V	20A	

NEUTRAL

GROUNDING

NOTE: ALL POWER OUTLETS MUST HAVE 3-WIRES
ALL FLUORESCENT FIXTURES MUST BE GROUNDED

GENERATOR SYSTEMATIC DIAGRAM

The diagram illustrates the electrical connections from a generator (GEN Cb) to various loads. It includes three double pole switches (D.P.), a fused disconnector, an automatic voltage switcher (AVS), a contactor, and an automatic voltage regulator (AVR). The generator output is 3P+N+G. The system is connected to a load (L.C.) and a solar system. The diagram also shows the connection to a main panel, a sub-panel, and a load circuit. The system is protected by a primary feeder, a disconnect switch, a transformer, and a network protector. The load circuit is connected to a load circuit breaker and a load circuit.


LEGEND

- AVS (AUTOMATIC VOLTAGE SWITCHER)
- D.P. (DOUBLE POLE SWITCH)
- AVR (AUTOMATIC VOLTAGE REGULATOR)


Owner:
Ministry of Mines
and Energy

Project:
County Office




Project Number	002
Date	JULY 2026
Drawn By	MME Engineers
Checked By	
E103	
Scale	

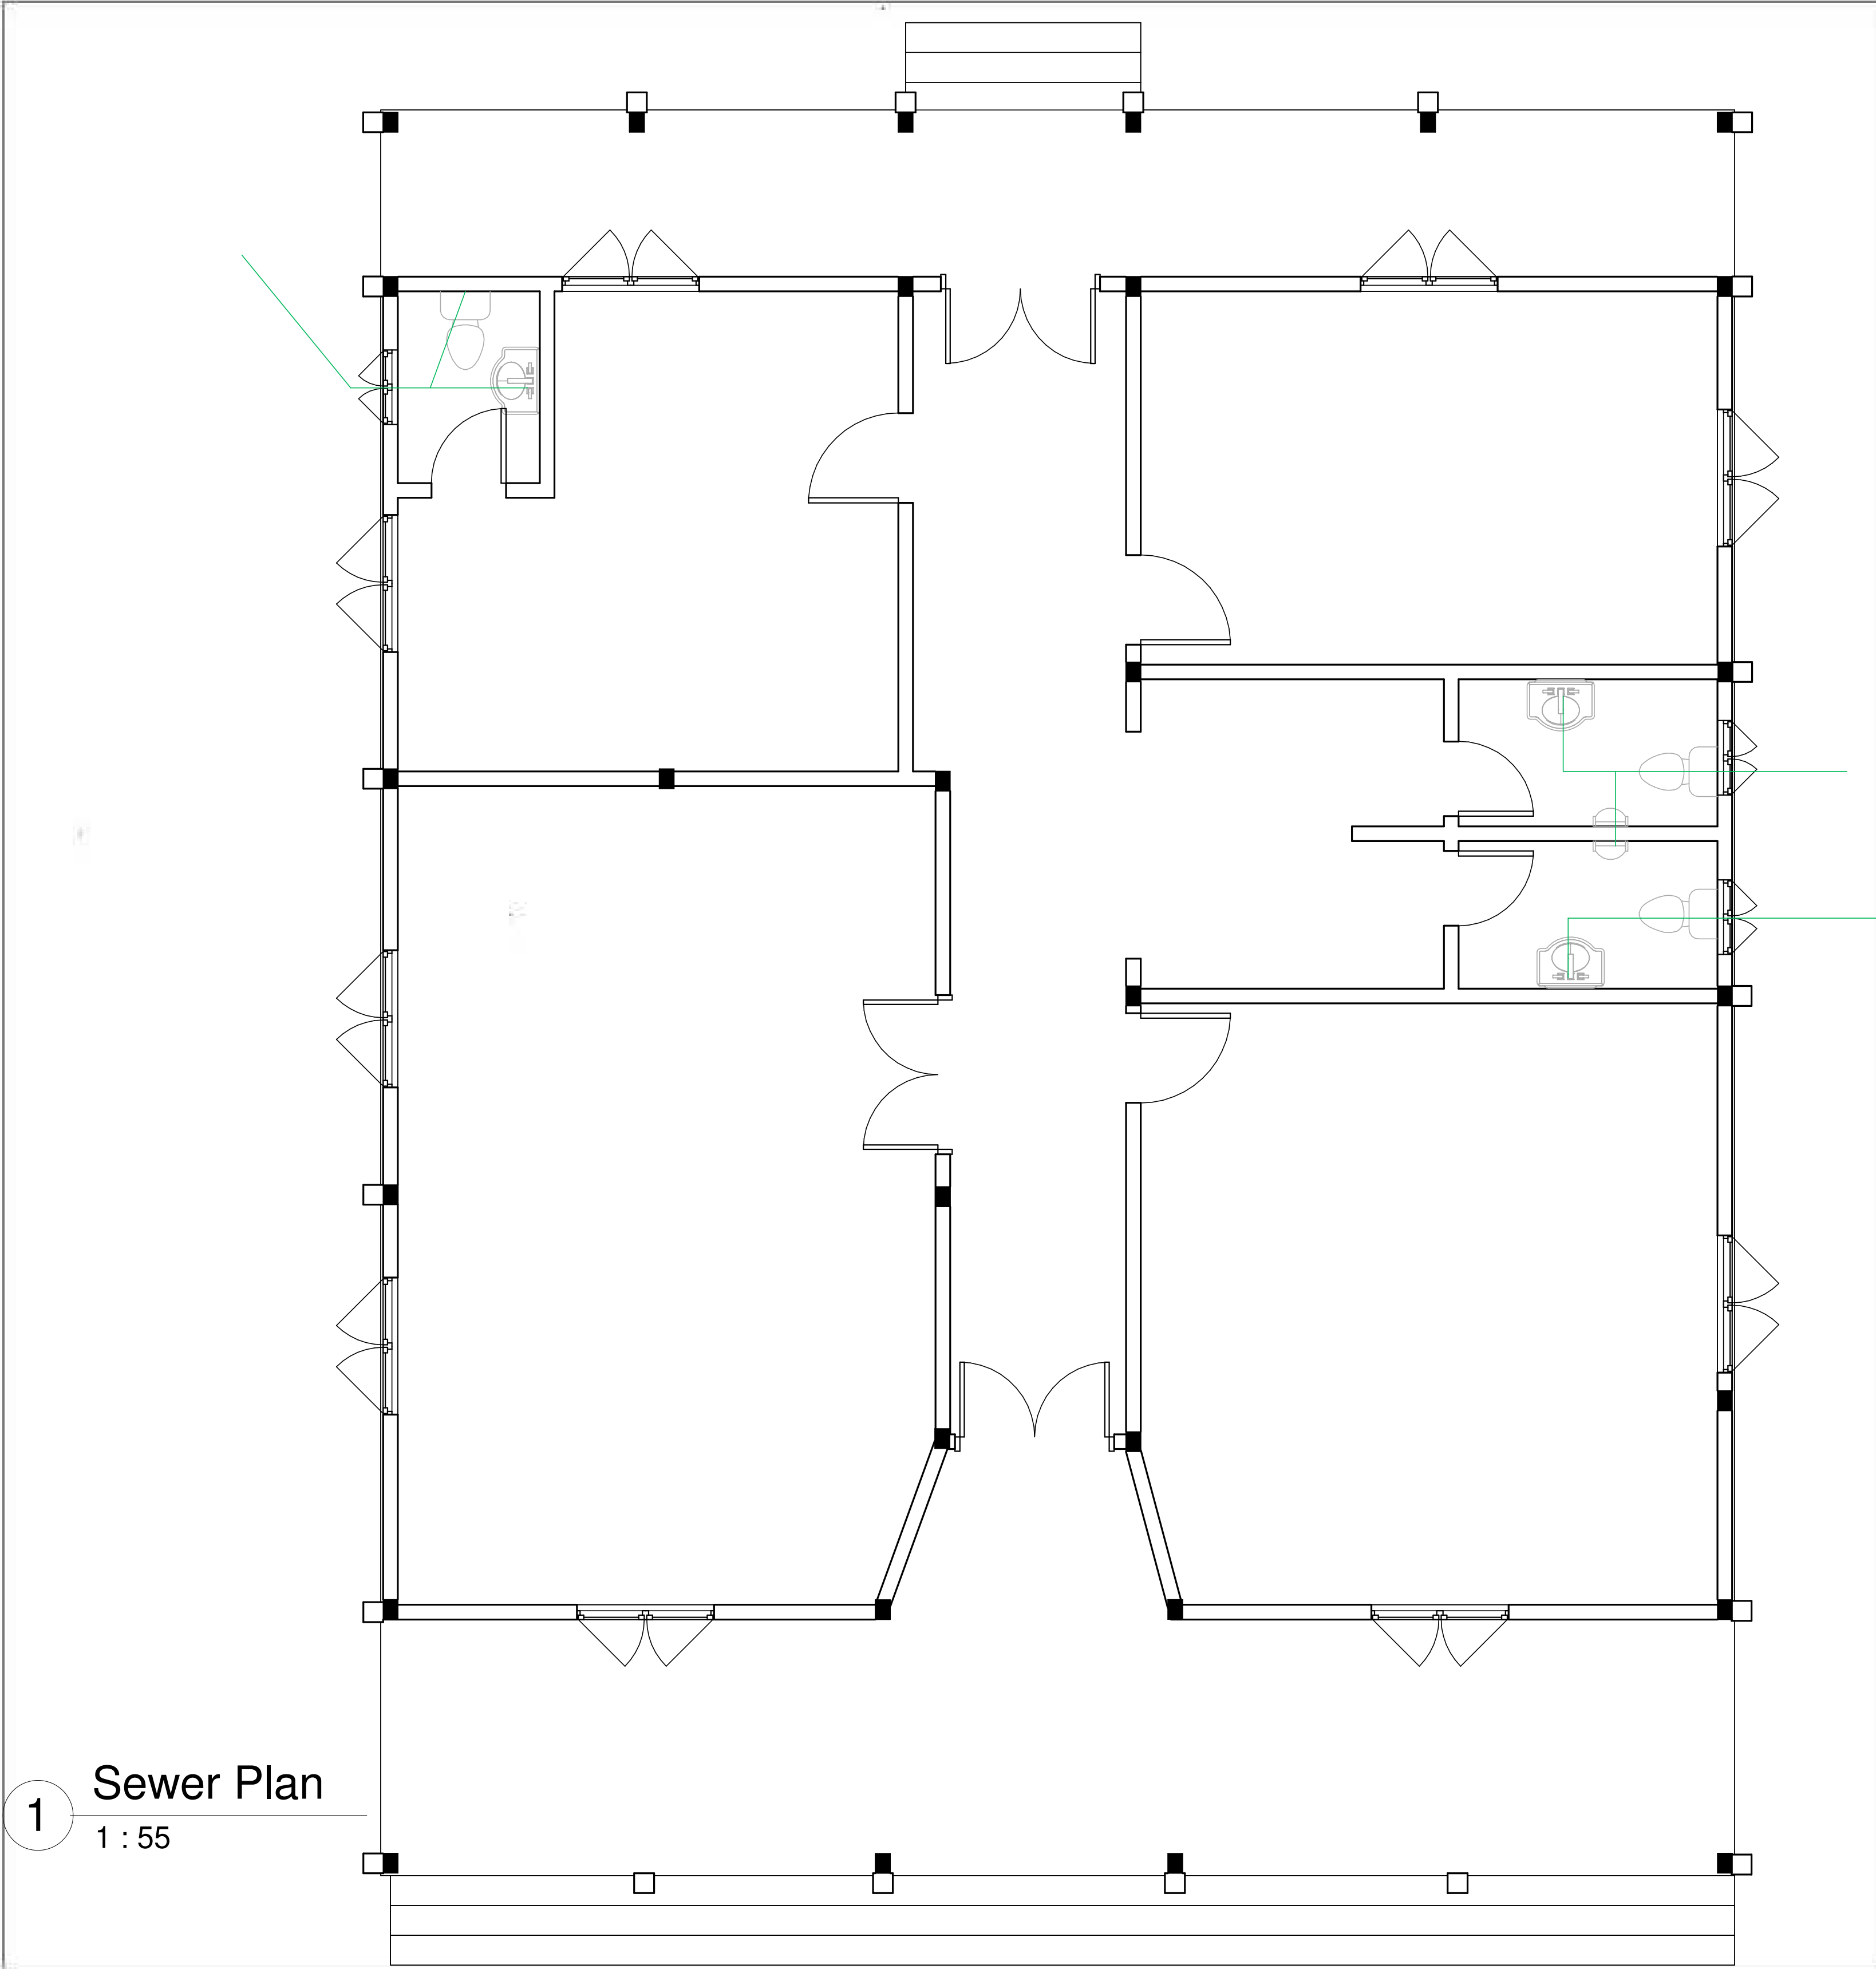

IFC DRAWING	
Owner: Ministry of Mines and Energy	
Project: County Office	
SEWER PLAN	
Project Number	002
Date	JULY 2026
Drawn By	MME Engineers
Checked By	
P101	
Scale	

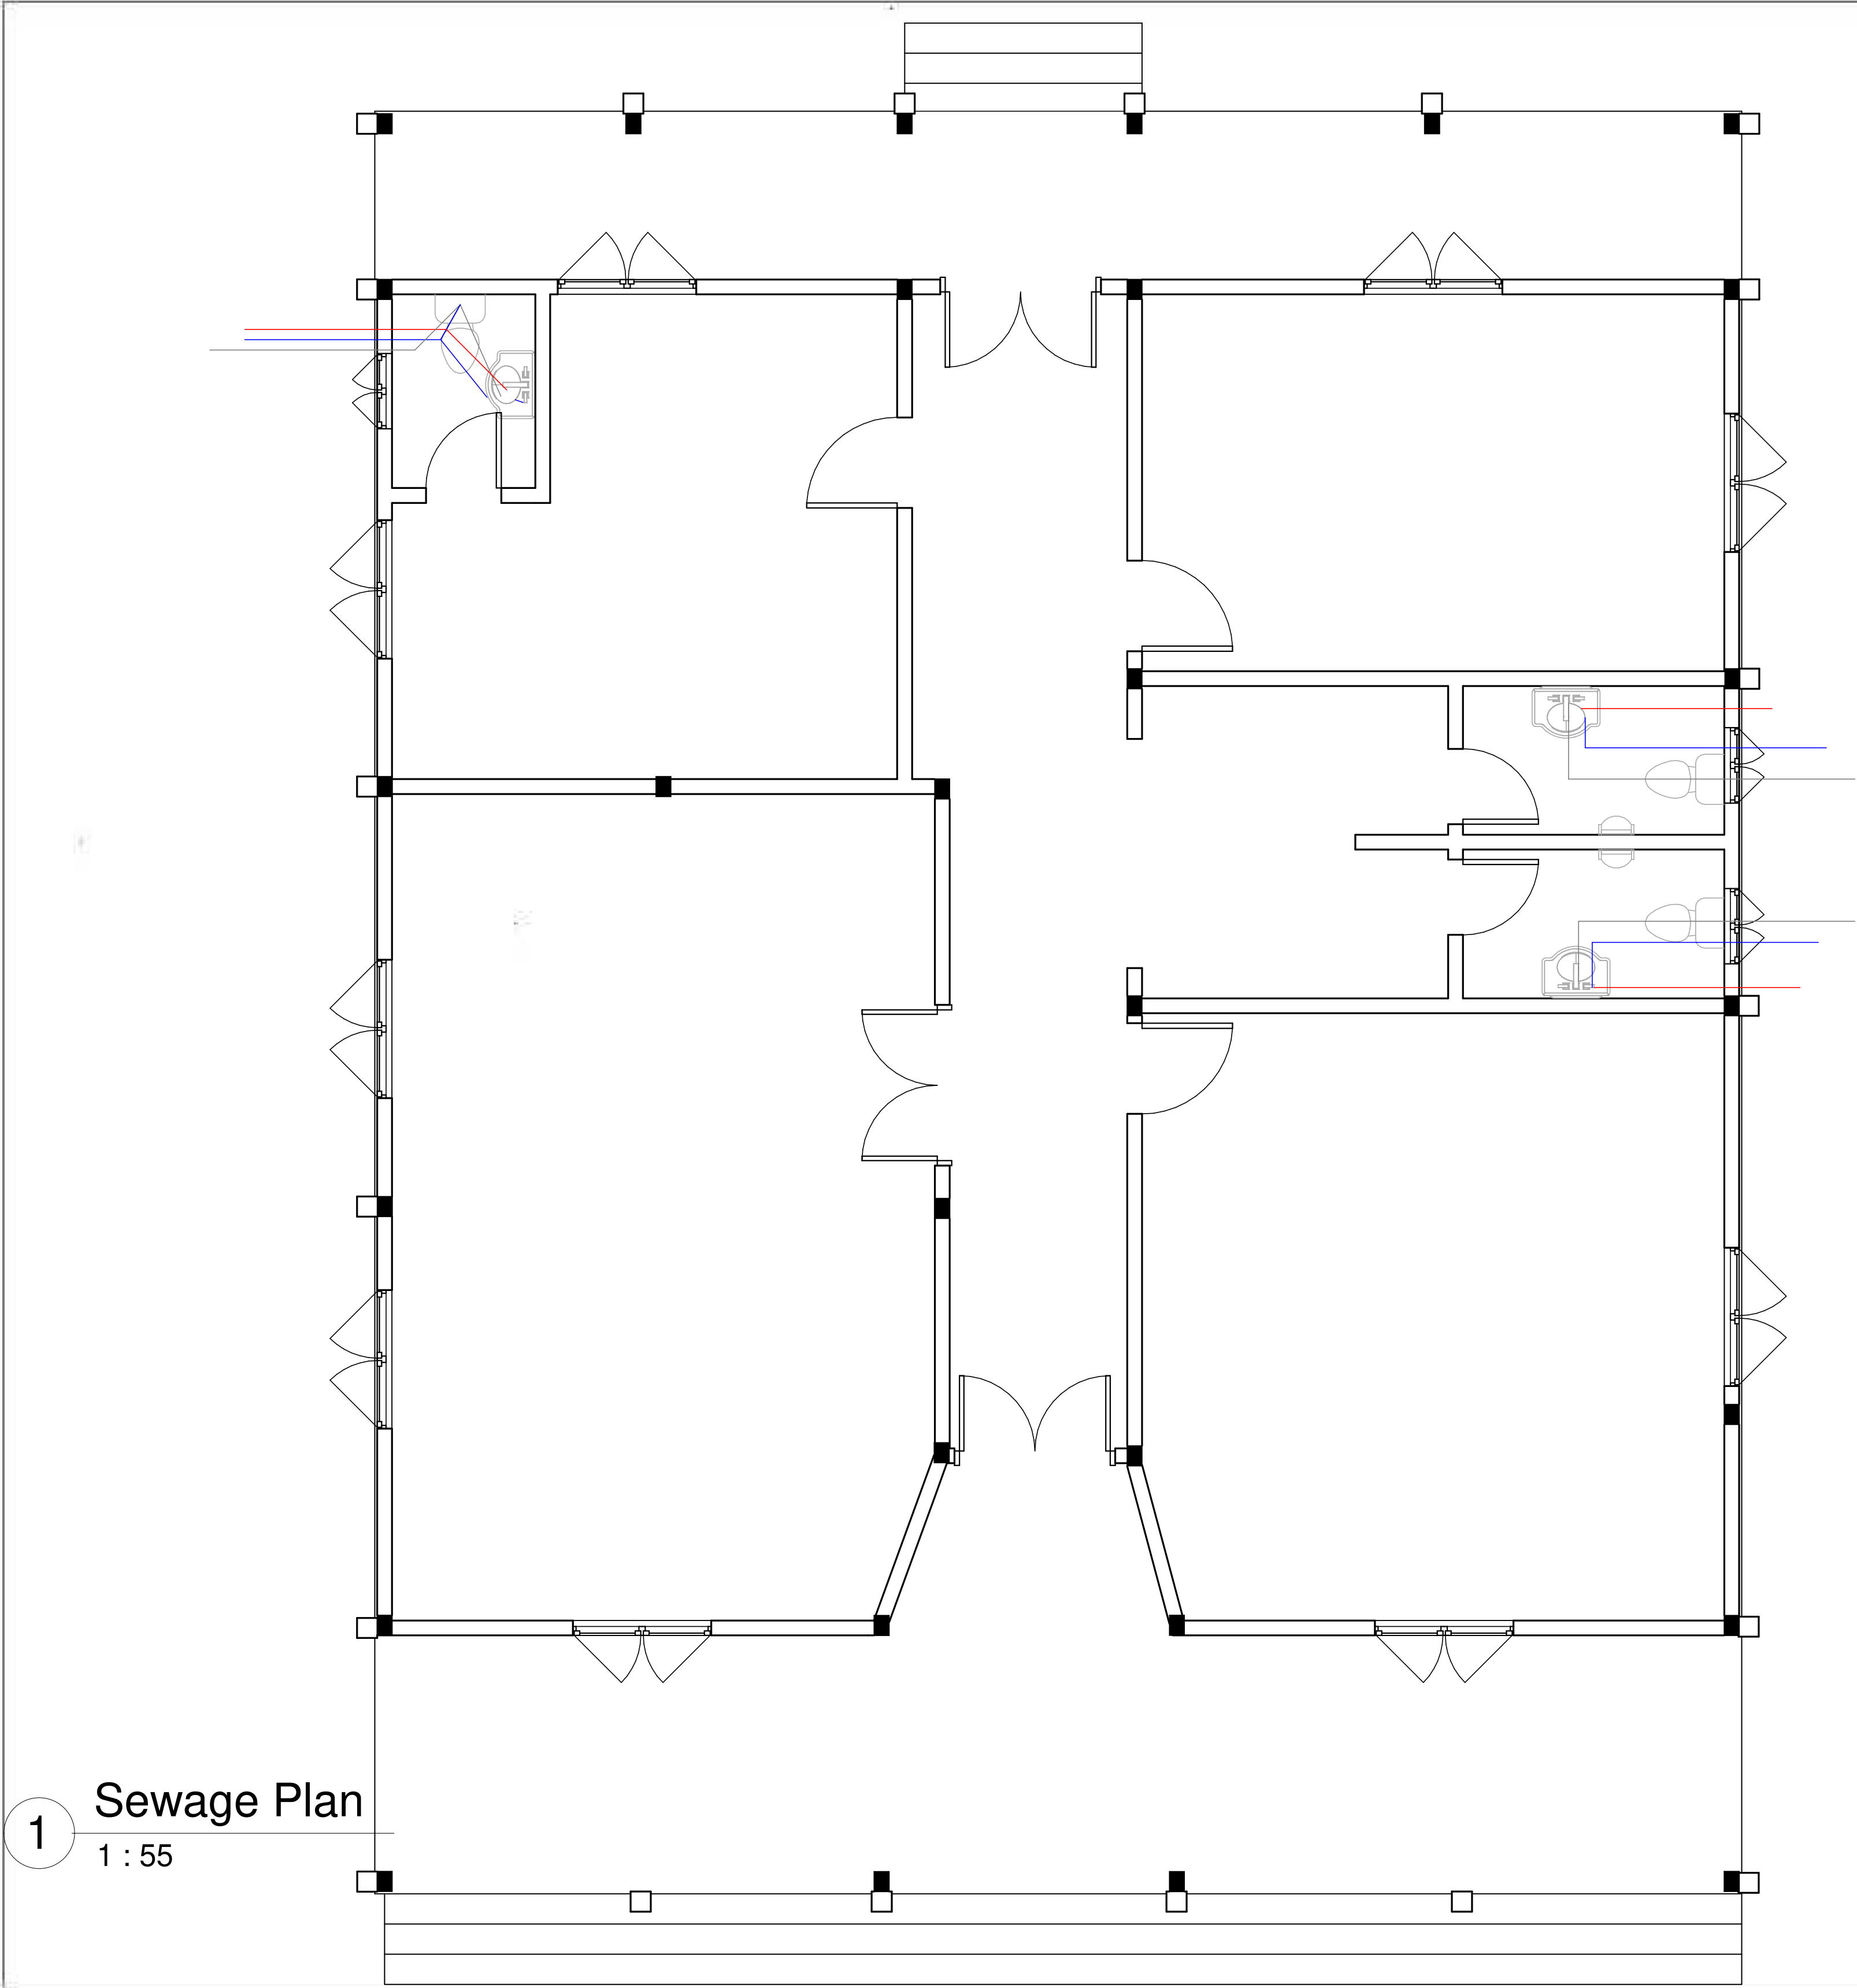

IFC DRAWING	
Owner: Ministry of Mines and Energy	
Project: County Office	
SEWAGE PLAN	
Project Number	002
Date	JULY 2026
Drawn By	MME Engineers
Checked By	
P102	
Scale	

 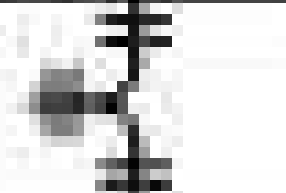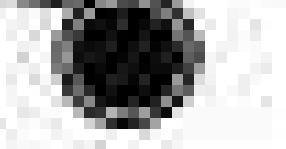SEWAGE DISPOSAL SYMBOLS	
	- 4" Ø PVC SEWAGE LINE
	- 2" Ø PVC SEWAGE LINE
	- 2" / 4" Ø PVC BENT
	- 2" / 4" Ø PVC TEE
	- DIRECTION OF FLOW
	- 2" Ø PVC CLEAN OUT PIPE
	- 2" Ø PVC VENT PIPE
	- 2" Ø PVC FLOOR DRAIN
	- MAN HOLE
	- GREASE TRAP
	- P - TRAP
	- 45° ELBOW JOINT
	SEPTIC TANK
	SOAK-AWAY PIT

IFC DRAWING
Owner: Ministry of Mines and Energy Project: County Office
PLUMBING DETAILS
Project Number: 002
Date: JULY 2026
Drawn By: MME Engineers
Checked By:
P103
Scale: